



GENERAL BANDSTAND NOTES:

1. FOR WHITE CEDAR, ALL WOOD SURFACES TO BE SEALED AND PAINTED WHITE OR GRAY, AS SPECIFIED IN THE DRAWINGS, PRIOR TO INSTALLATION (ITEM 2 AND 3 BELOW). ANY WOOD SURFACES EXPOSED DURING CONSTRUCTION TO BE REPAINTED/RESEALED AS SPECIFIED IN THE DRAWINGS.
2. FOR WOOD SURFACES PAINTED WHITE*, USE SIKKENS RUBBOL® SOLID DEK, COLOR WHITE 100.
3. FOR WOOD SURFACES PAINTED GRAY*, USE SIKKENS CETOL® SRD SEMI-TRANSPARENT STAIN, COLOR FOG GRAY.
4. SEE LANDSCAPE GENERAL NOTES SHEET LNS-2 FOR APPROVED MATERIAL ALTERNATES.
5. ALL WORK ON THIS SHEET SHALL BE PAID UNDER ITEM 900.645 SPECIAL PROVISION (RECONSTRUCT BANDSTAND).
6. COLLAR TIES, ROOF/CEILING FRAMING AND STRUCTURAL DESIGN TO BE DESIGNED BY THE CONTRACTOR. REFER TO SPECIAL PROVISIONS.
7. ORIGINAL DESIGN BY TRUOX CULLINGS & PARTNERS ARCHITECTS.

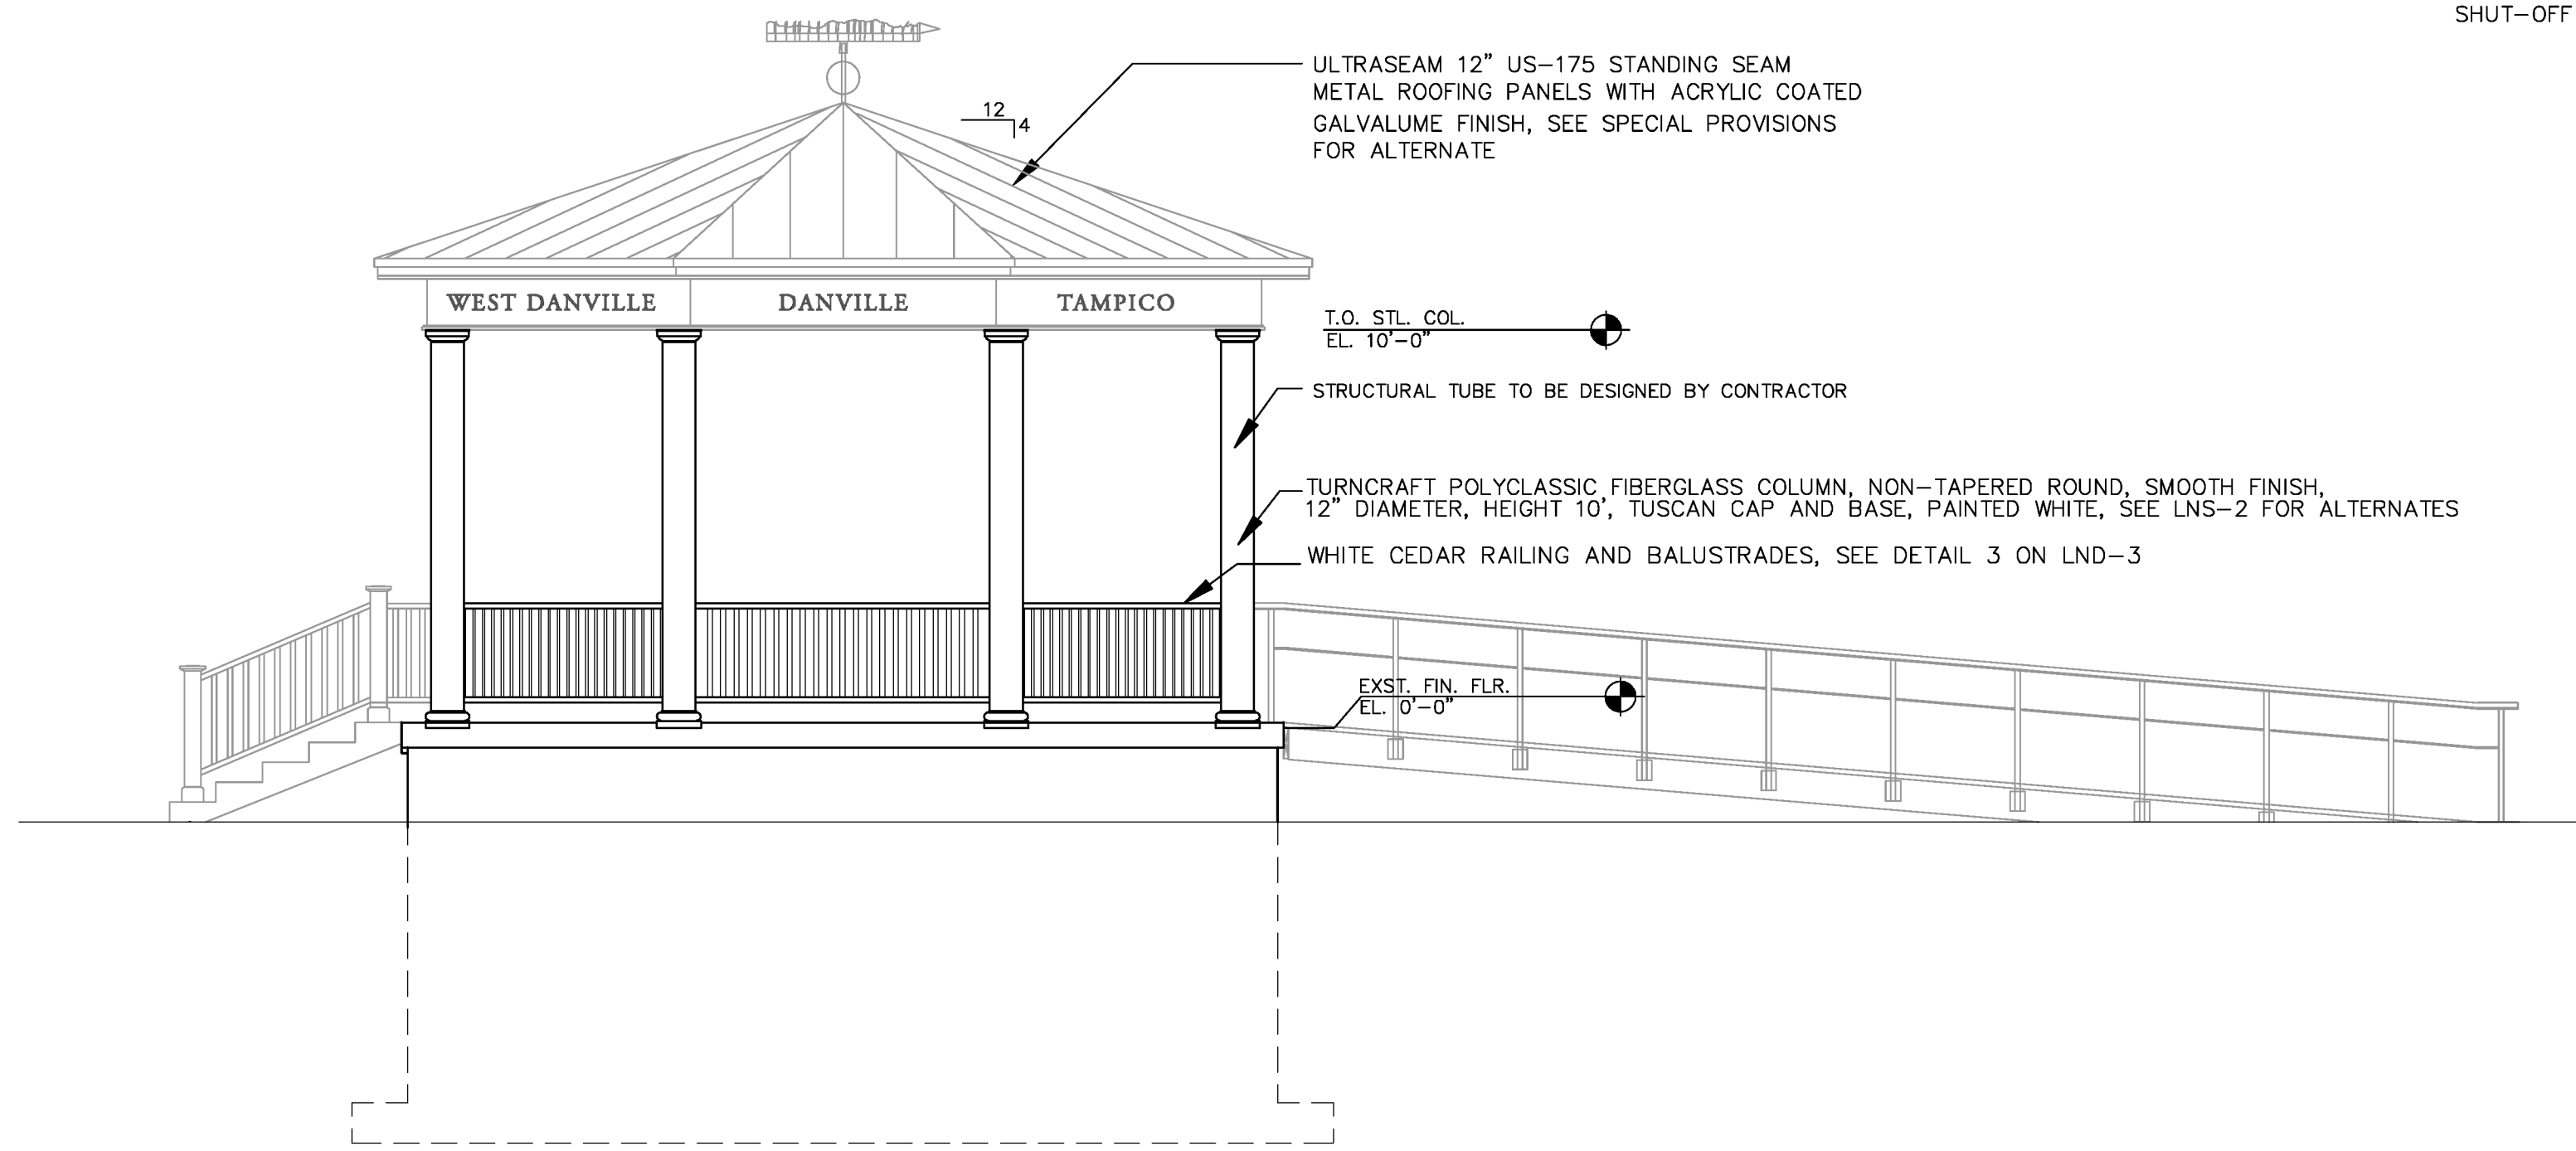

1 EAST ELEVATION
BSP-2 SCALE: 1/4"=1'-0"

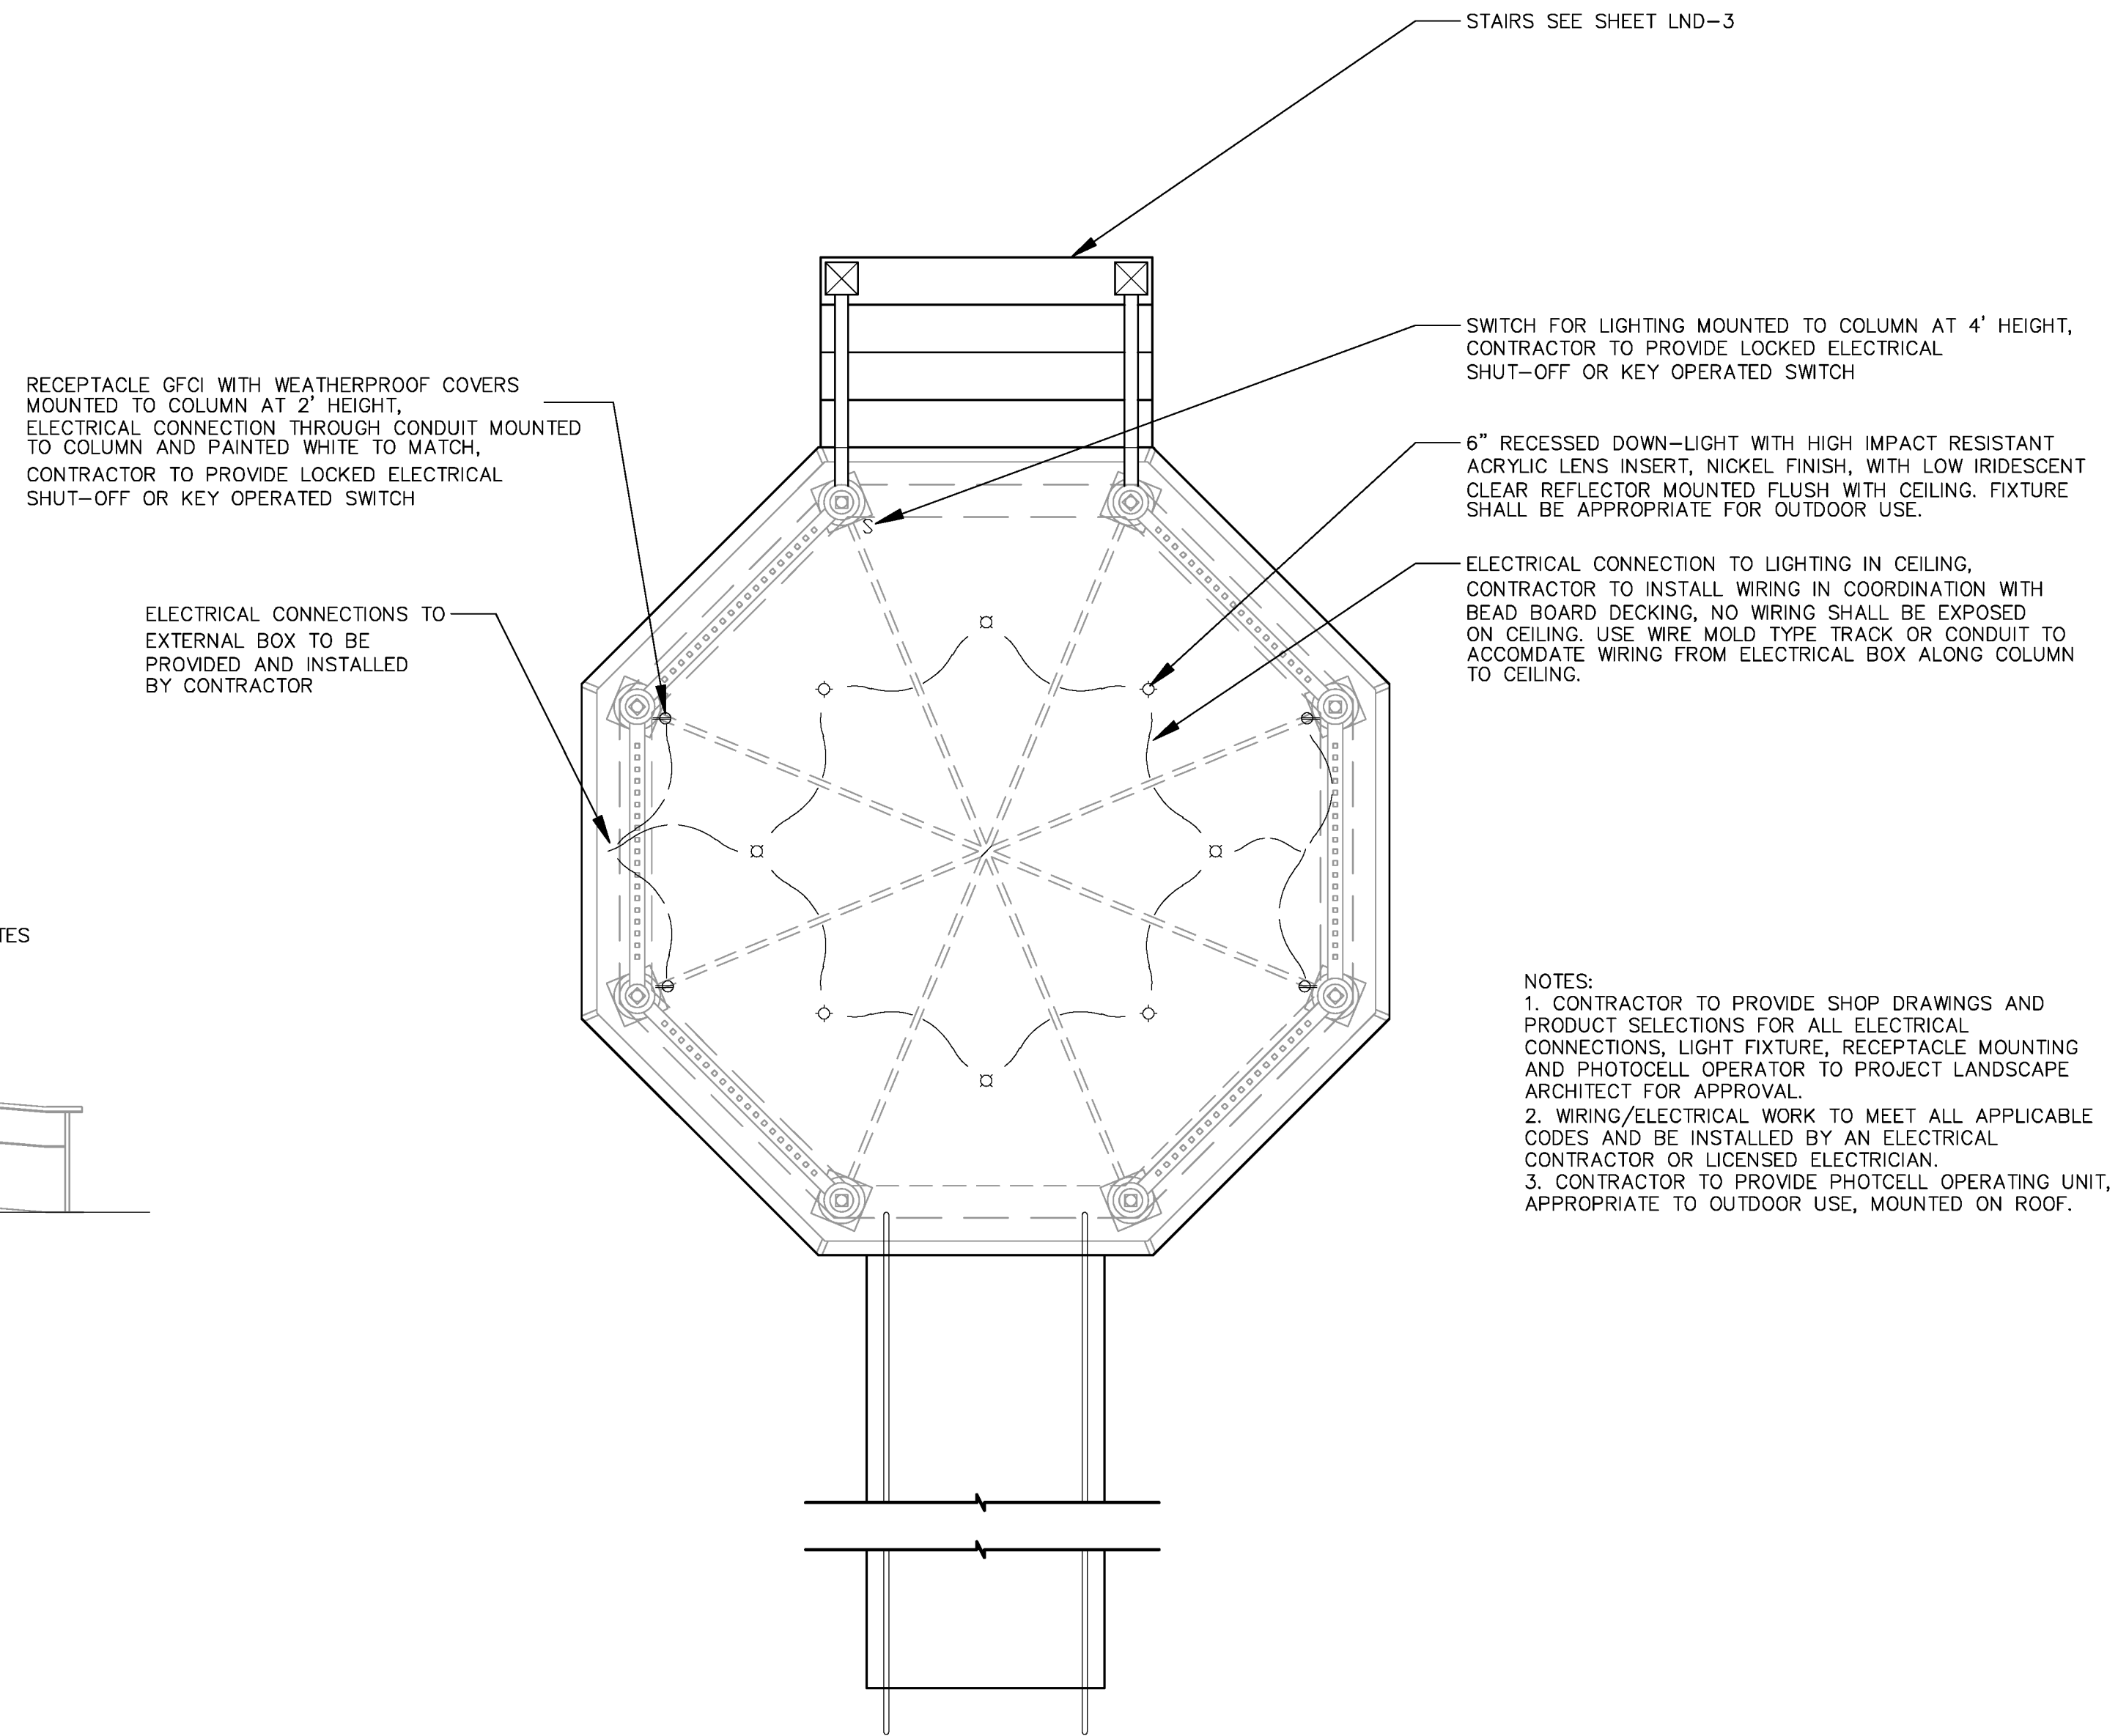

1 ELECTRICAL/ LIGHTING PLAN
BSP-2 SCALE: 1/4"=1'-0"

- NOTES:
1. CONTRACTOR TO PROVIDE SHOP DRAWINGS AND PRODUCT SELECTIONS FOR ALL ELECTRICAL CONNECTIONS, LIGHT FIXTURE, RECEPTACLE MOUNTING AND PHOTOCELL OPERATOR TO PROJECT LANDSCAPE ARCHITECT FOR APPROVAL.
 2. WIRING/ELECTRICAL WORK TO MEET ALL APPLICABLE CODES AND BE INSTALLED BY AN ELECTRICAL CONTRACTOR OR LICENSED ELECTRICIAN.
 3. CONTRACTOR TO PROVIDE PHOTOCELL OPERATING UNIT, APPROPRIATE TO OUTDOOR USE, MOUNTED ON ROOF.

TRUOX CULLINGS &
PARTNERS ARCHITECTS
802 658 2775

ELEVATIONS

PROJECT NAME: DANVILLE
PROJECT NUMBER: F EGC 028-3(32)

FILE NAME: BSP 2	PLOT DATE: 1.19.2011
DESIGN SUPERVISOR: DR	DRAWN BY: LANDWORKS
DESIGNED BY: LANDWORKS	CHECKED BY: DR
BAND STAND PLAN BSP-2	SHEET 206 OF 306