

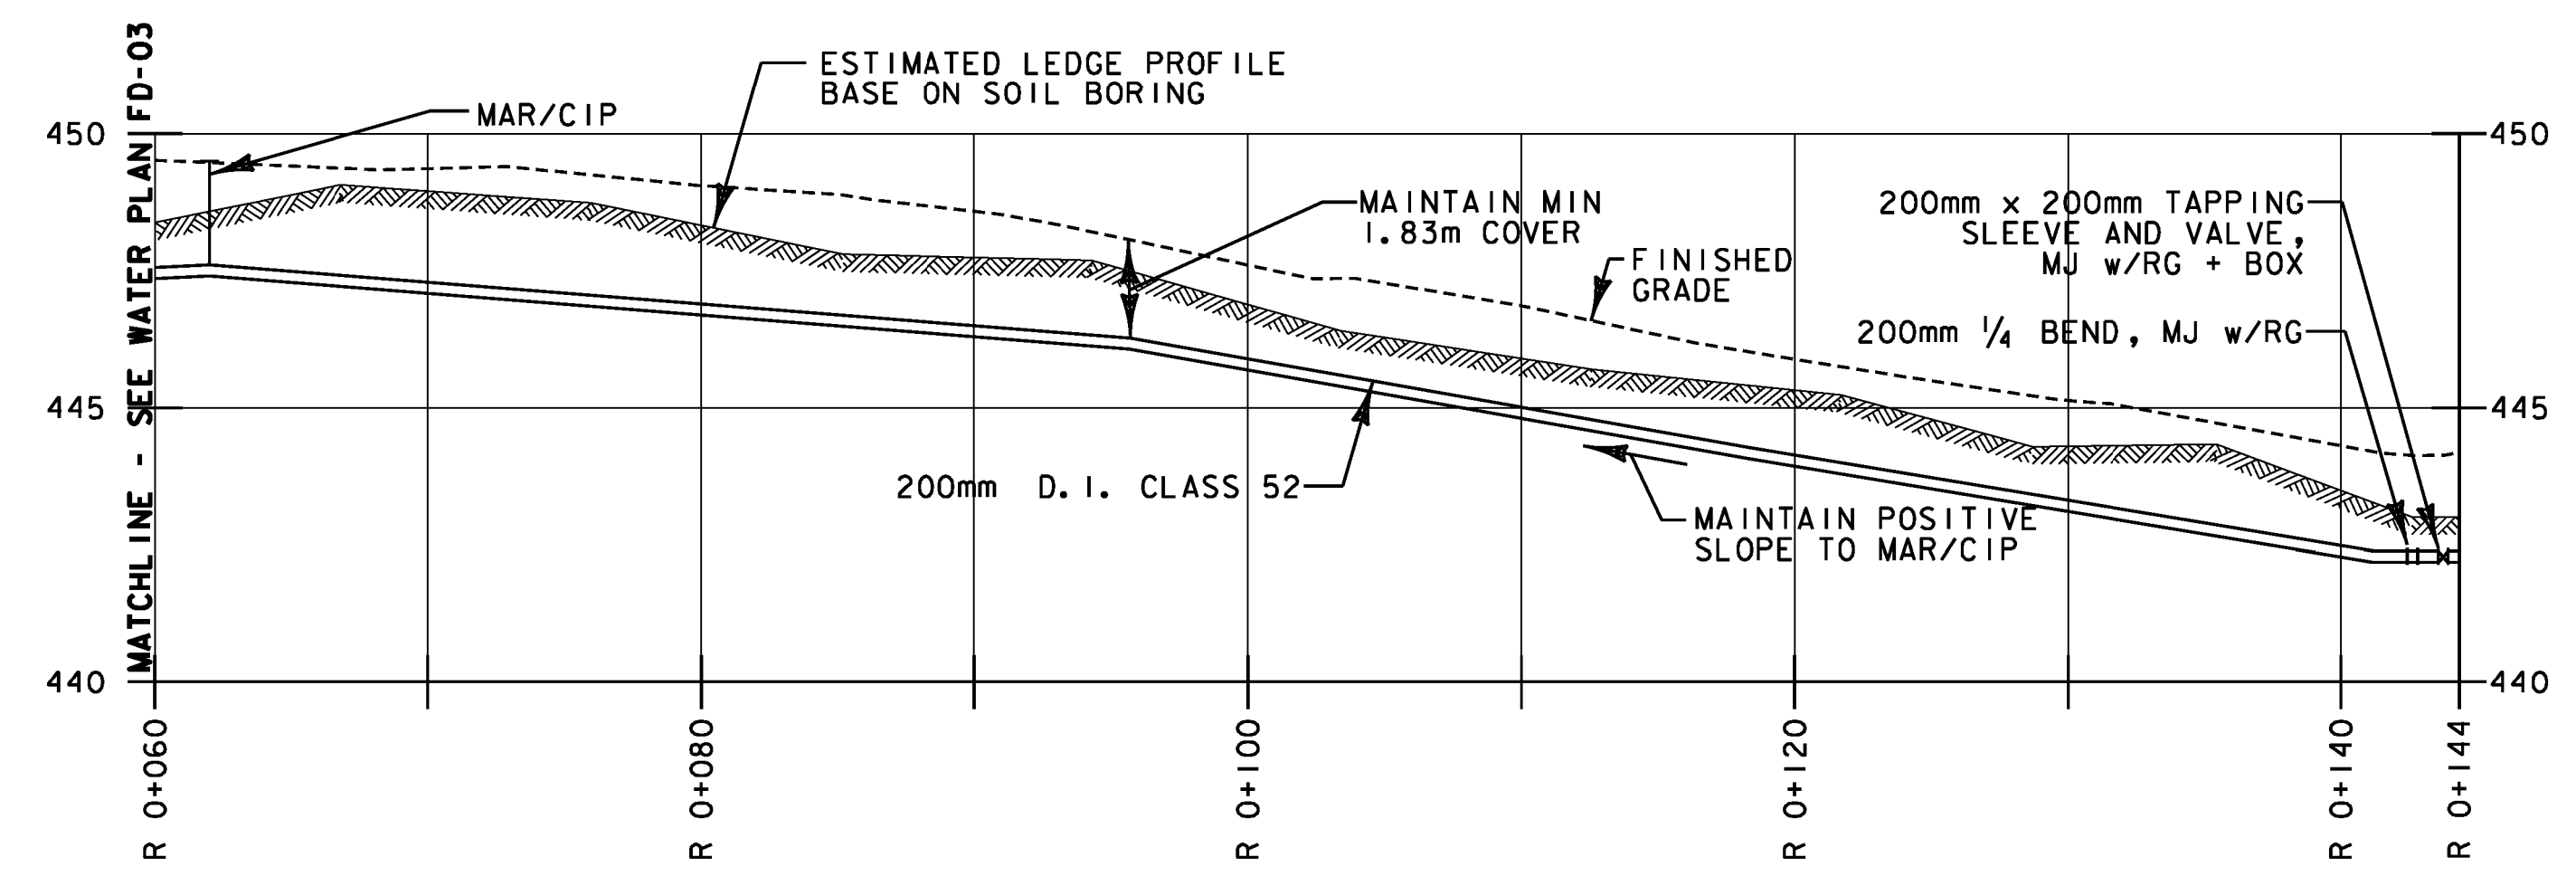



SITE PLAN

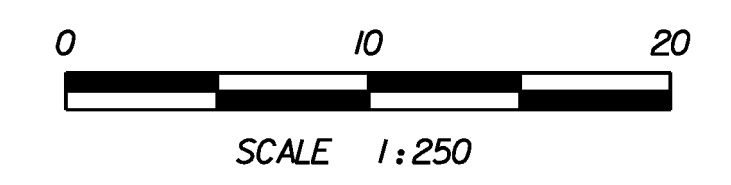

WATER MAIN PROFILE

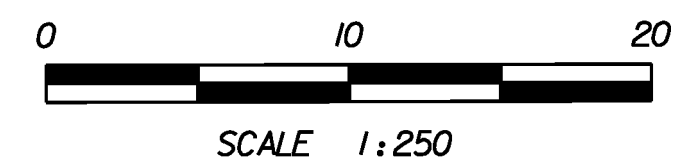

HORIZONTAL

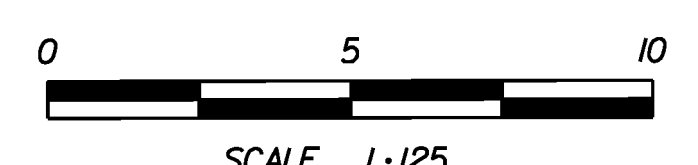

VERTICAL

**REPLACEMENT SHEETS
ISSUED 10/5/11**

STA. R 0+060 TO STA. R 0+144

PROJECT NAME: DANVILLE	PLOT DATE: 10/4/2011
PROJECT NUMBER: F EGC 028-3(32)	DRAWN BY: STANTEC
FILE NAME: ...\\Utilities\PlotFiles\FD-04.ptf	CHECKED BY: STANTEC
DESIGNED BY: STANTEC	SHEET 293 OF 306
FIRE DISTRICT WATER PLANS FD-04	



10/4/2011 12:18 PM V:\N953\active\9530033\092\Utilities\PlotFiles\FD-04.ptf