

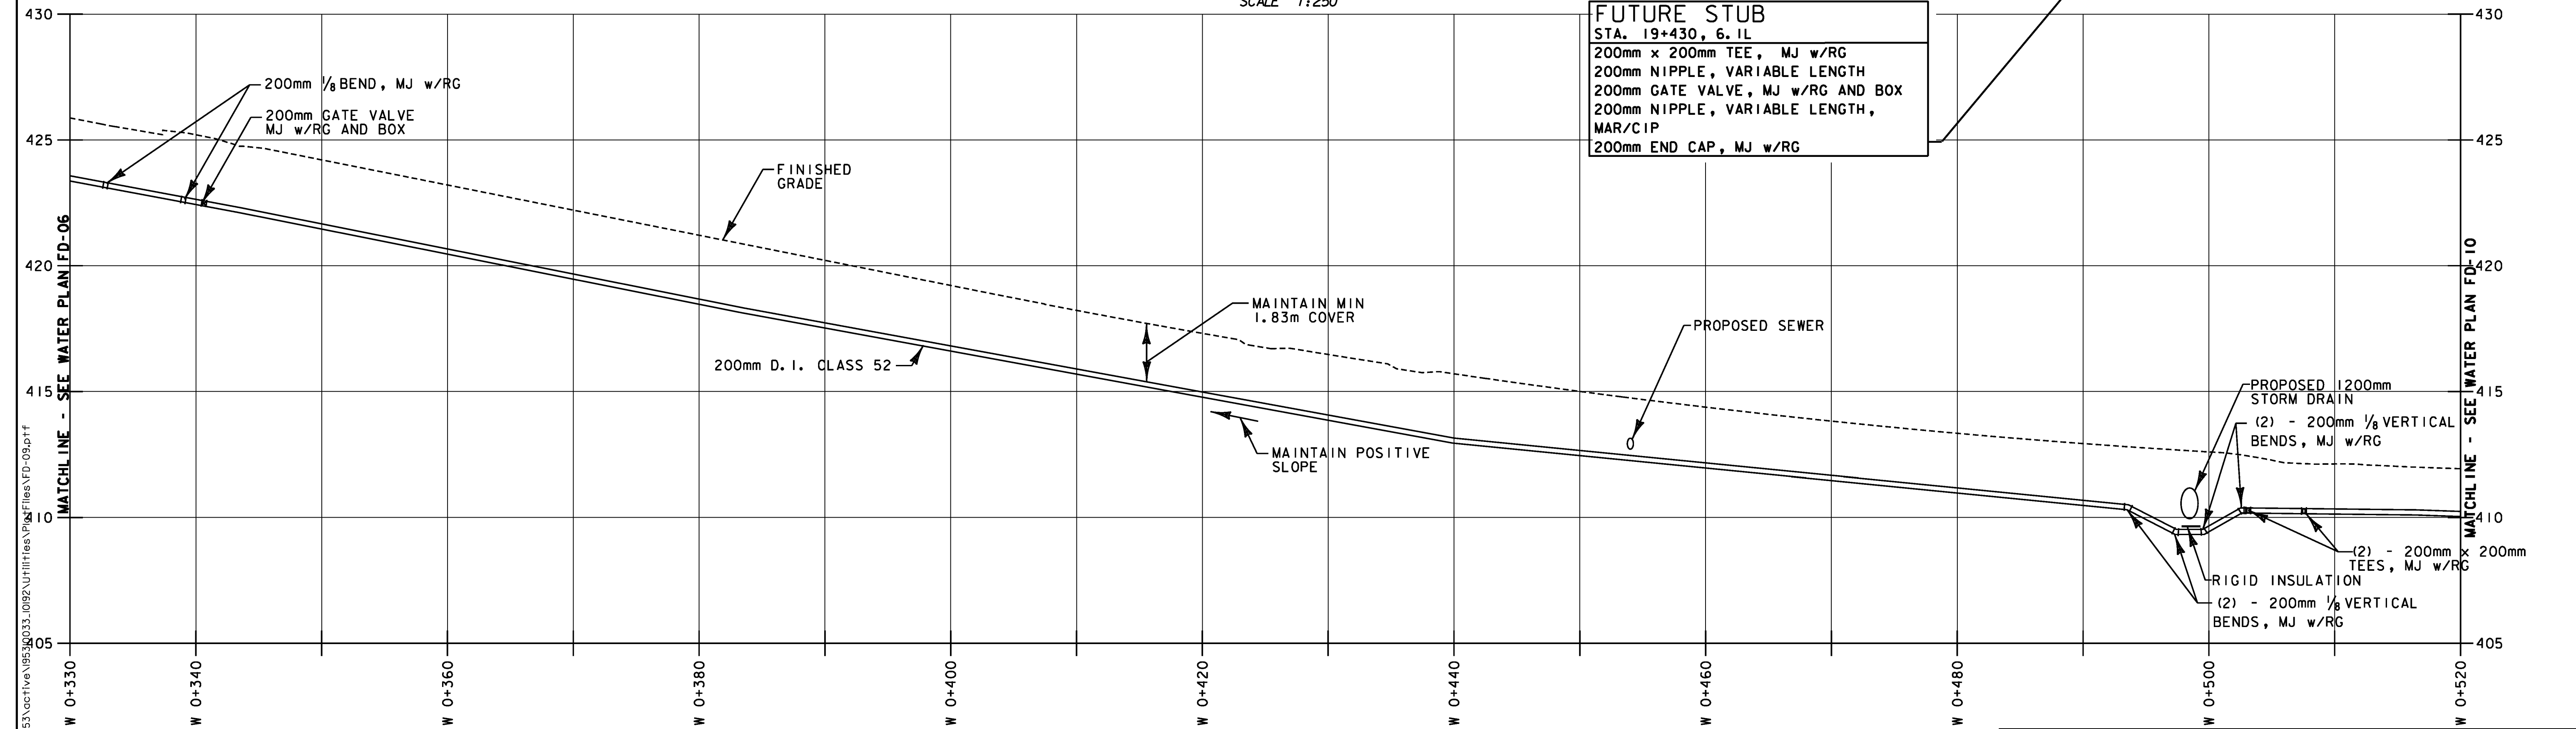


SITE PLAN

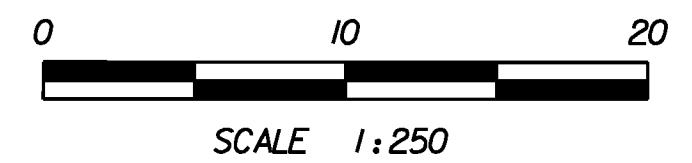

WATER MAIN PROFILE

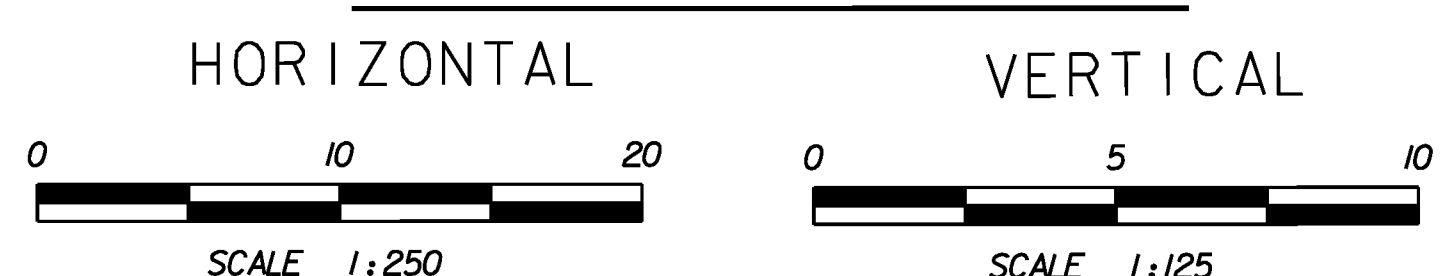

REPLACEMENT SHEETS
ISSUED 10/5/11

PROJECT NAME: DANVILLE
 PROJECT NUMBER: F EGC 028-3(32)
 FILE NAME: ...\\ut\Titles\PlotFiles\FD-09.p1f PLOT DATE: 10/4/2011
 DESIGN SUPERVISOR: TOM NESBITT DRAWN BY: STANTEC
 DESIGNED BY: STANTEC CHECKED BY: STANTEC
FIRE DISTRICT WATER PLANS FD-09 SHEET 298 OF 306



STA. W 0+330 TO STA. W 0+520