


DRAINAGE LAYOUT SHEET 7

- | | | | |
|--|--|---|--|
| <p>EXISTING DRAINAGE</p> <ul style="list-style-type: none"> 52 49+70 RT ~ 50+44 RT
EXISTING PIPE - CONNECT TO
NEW CB @ 50+44.0 RT 53 50+44 RT ~ 50+58 RT
EXISTING PIPE & DI - REMOVE 54 50+58 LT
EXISTING PIPE - ABANDON 55 50+59 RT ~ 50+60 RT
EXISTING DI - REMOVE 56 50+60 RT ~ 50+66 RT
EXISTING PIPE - ABANDON 57 52+44 RT ~ 52+46 LT
EXISTING DI @ 52+46 LT - ABANDON
EXISTING PIPE - ABANDON 58 52+46 LT ~ 52+44 RT - REMOVE
EXISTING DI @ 52+44 RT - REMOVE 59 54+75 LT ~ 54+83 RT
EXISTING DI - ABANDON
EXISTING PIPE - REMOVE 60 40+40 RT (DEVIN ST) ~ 54+83 RT
EXISTING DI - REMOVE
EXISTING PIPE - ABANDON | <p>NEW DRAINAGE</p> <ul style="list-style-type: none"> 73 50+30.0 RT ~ 49+40.0 RT
NEW 18"x86" RCP/CPEP (SL)
W/MB @ 50+30.0 RT 74 50+44.0 RT ~ 50+30.0 RT
NEW 18"x20" RCP/CPEP (SL)
W/CB @ 50+44.0 RT
CONNECT TO EXISTING PIPE 75 35+38.8 RT ~ 35+35.2 LT (GONDREAU ST)
NEW 18"x18" RCP/CPEP (SL)
W/CB @ 35+38.8 RT 76 35+35.2 LT (GONDREAU ST) ~ 52+45.0 RT
NEW 18"x26" RCP/CPEP (SL)
W/CB @ 35+35.2 LT 77 52+45.0 RT ~ 52+45.0 RT
NEW 18"x46" RCP/CPEP (SL)
W/CB @ 52+45.0 RT 78 52+45.0 RT ~ 54+00.0 RT
NEW 18"x63" RCP/CPEP (SL)
W/MB @ 52+45.0 RT 79 54+00.0 LT ~ 54+00.0 RT
NEW 18"x34" RCP/CPEP (SL)
W/CB @ 54+00.0 LT 80 54+00.0 RT ~ 55+12.0 RT
NEW 18"x68" RCP/CPEP (SL)
W/CB @ 54+00.0 RT 81 40+36 RT ~ 40+36 LT (DEVIN ST)
NEW 18"x42" RCP/CPEP (SL)
W/CB @ 40+36 RT 82 40+36 LT (DEVIN ST) ~ 55+12.0 RT
NEW 18"x20" RCP/CPEP (SL)
W/CB @ 40+36 LT | <p>8" UNDERDRAIN (MOD.)</p> <ul style="list-style-type: none"> 43 47+12 RT ~ 50+30 RT
NEW 8"x30" UNDERDRAIN
W/F.B. @ 50+30 RT 44 49+43 LT ~ 51+50 LT
NEW 8"x206" UNDERDRAIN
W/F.B. @ 51+50 LT 45 51+50 LT ~ 54+00 LT
NEW 8"x250" UNDERDRAIN
W/F.B. @ 54+00 LT 46 54+00 LT ~ 56+75 LT
NEW 8"x274" UNDERDRAIN
W/F.B. @ 54+00 LT 47 50+45 RT ~ 51+85 RT
NEW 8"x38" UNDERDRAIN
W/F.B. @ 51+85 RT 48 52+45 RT ~ 54+60 RT
NEW 8"x214" UNDERDRAIN
W/F.B. @ 52+45 RT | <p>8" UNDERDRAIN CARRIER PIPE (MOD.)</p> <ul style="list-style-type: none"> 49 50+30 RT ~ 50+35 RT
NEW 8"x4" UNDERDRAIN CARRIER PIPE
W/F.B. @ 50+30 RT 50 54+60 RT ~ 40+36 RT (DEVIN ST)
NEW 8"x22" UNDERDRAIN CARRIER PIPE
W/F.B. @ 54+60 RT |
|--|--|---|--|

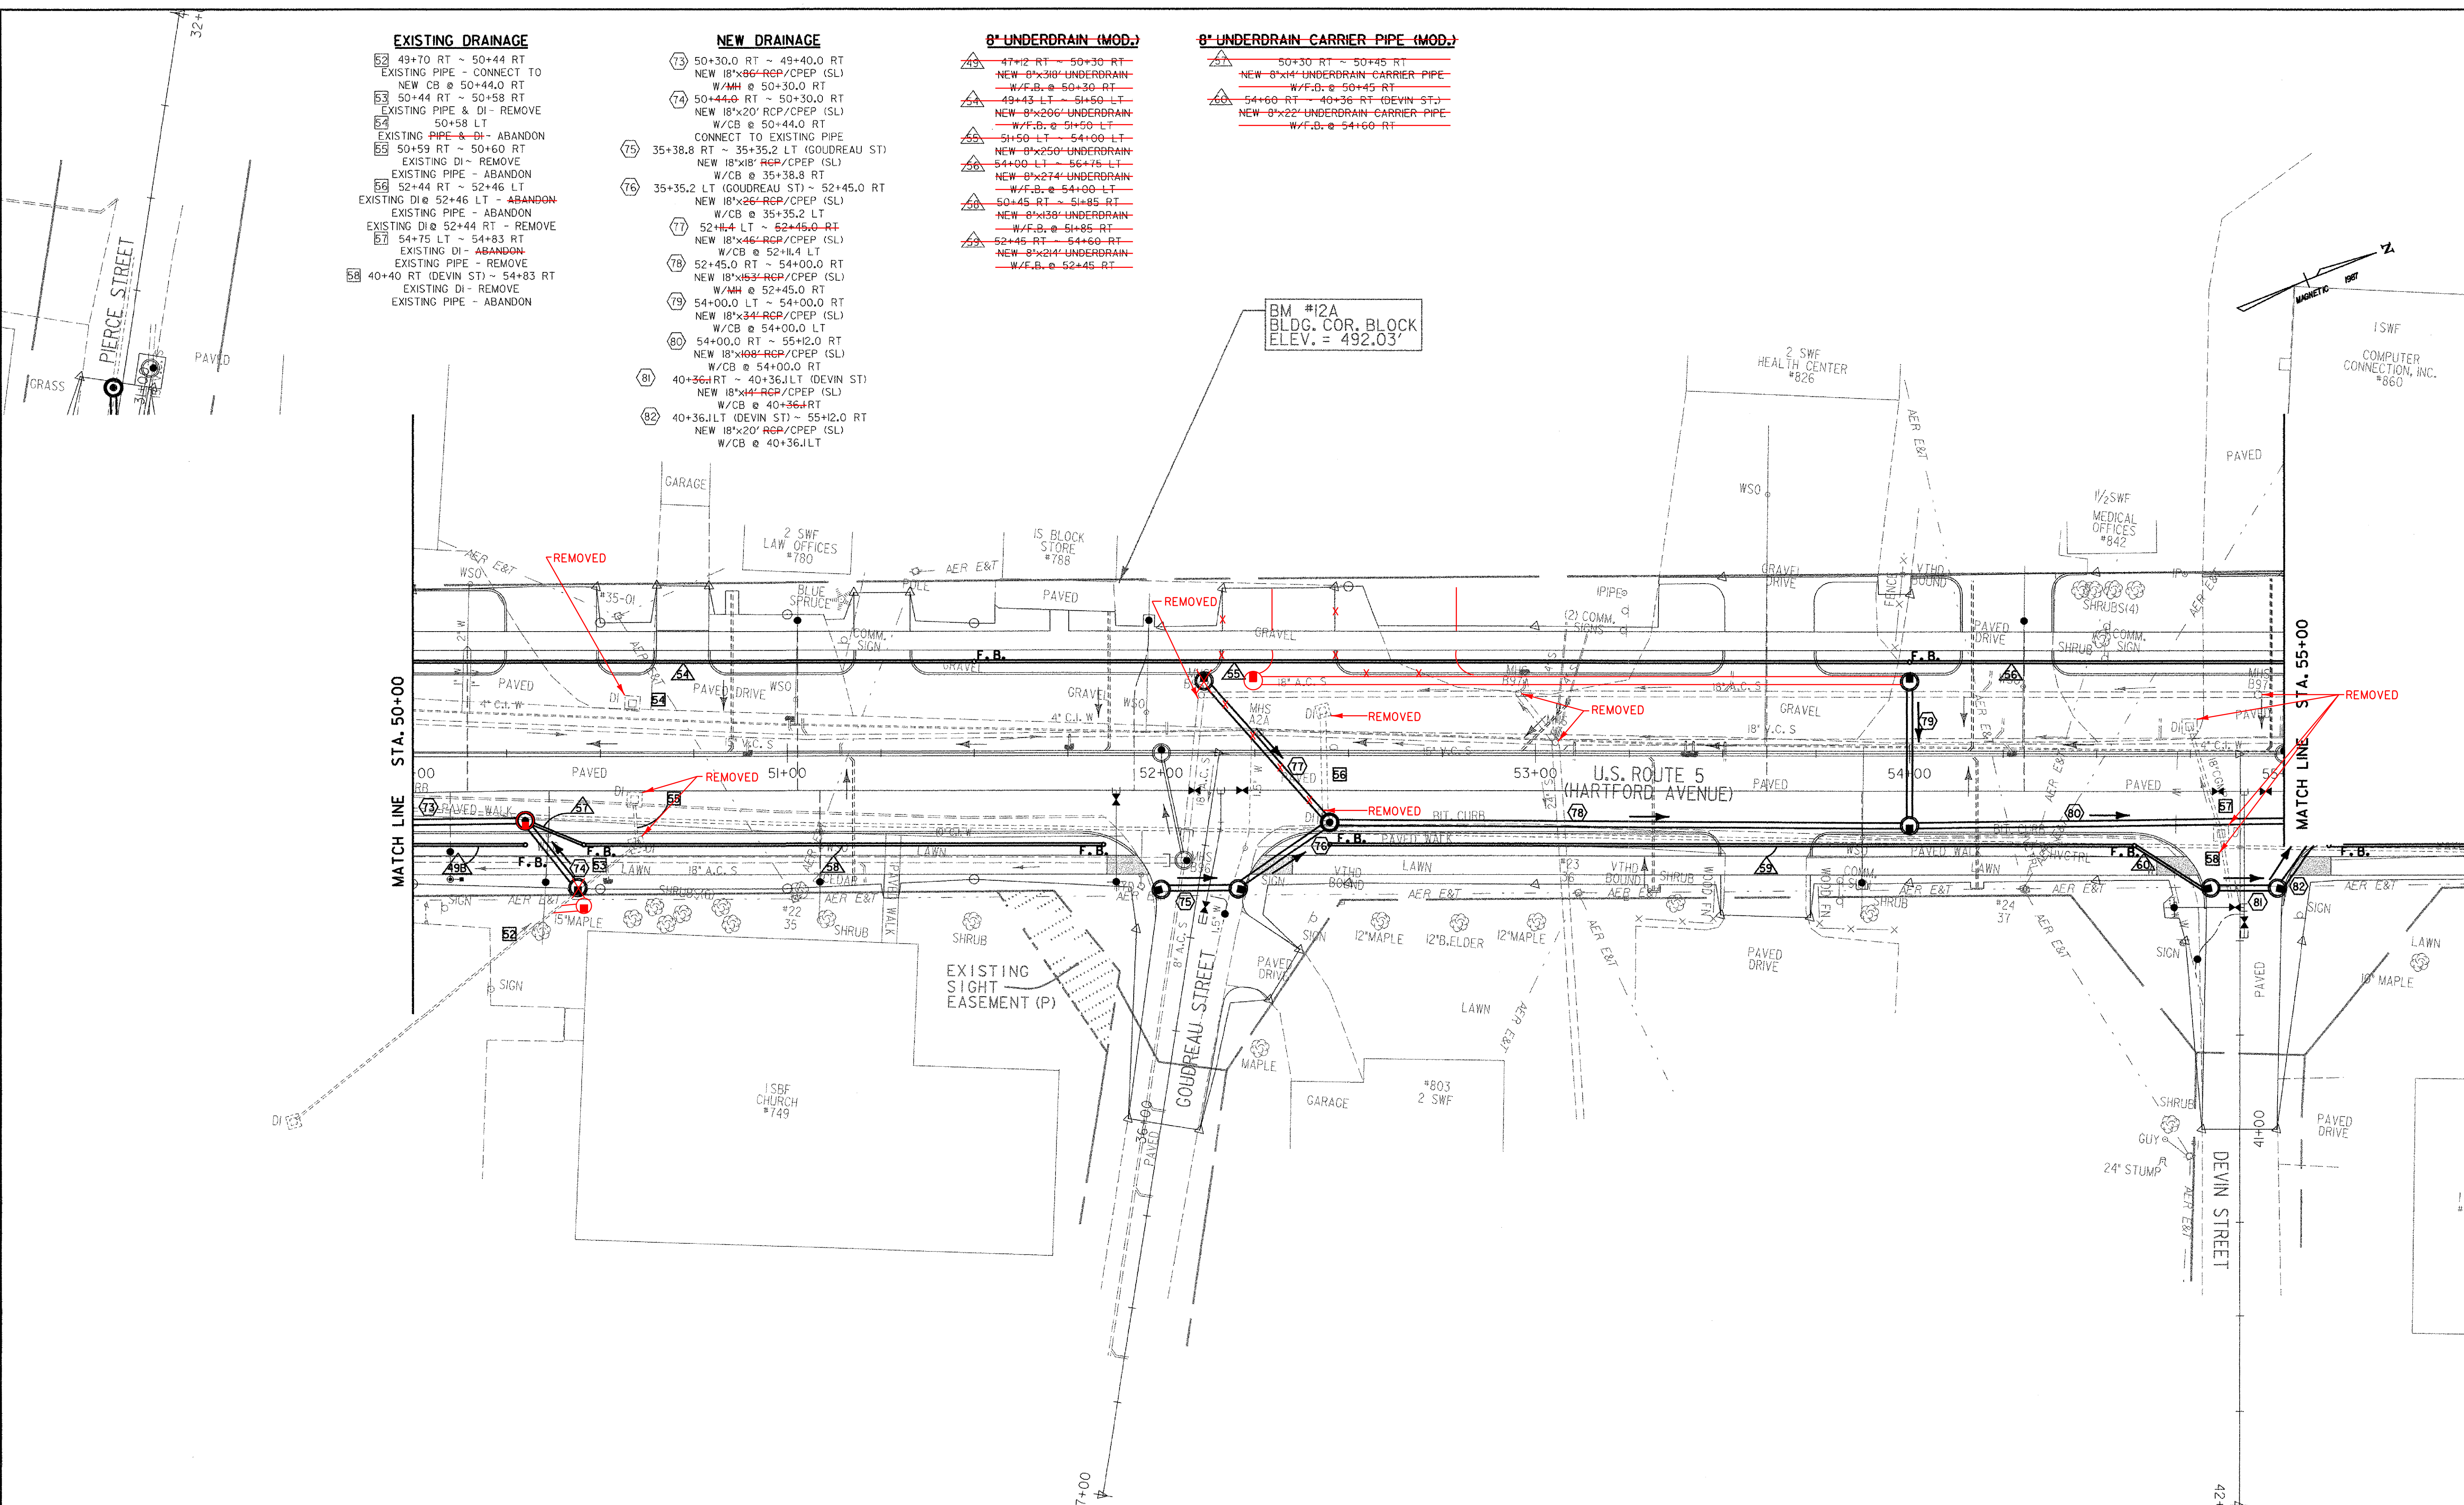

DATUM
 VERTICAL NGVD 1929
 HORIZONTAL N/A



- NOTES:**
- 1) SEE UTILITY CONSTRUCTION GENERAL NOTES SHEET FOR PROPOSED STORM DRAINAGE CONSTRUCTION NOTES.
 - 2) REFER TO WATER AND SANITARY SEWER LAYOUT SHEETS FOR PROPOSED WATER AND SEWER LAYOUT.
 - 3) SEE ROADWAY LAYOUT SHEETS FOR PLACEMENT OF STONE FILL.

PROJECT: HARTFORD	PROJECT NO.: RS 0113(40)
DESIGN FILE NAME: z86c027drnbnr.DGN	PLOT DATE: 1/31/2007
IPARM FILE NAME:	SURVEY DATE: 1/87
SURVEYED BY: FANTONI	DRAWN BY: E. ATKINS
SQUAD LEADER: KEN UPMAL	SHEET: 86 OF 239