


**PIPE PROFILE**

HORIZONTAL SCALE: 1" = 10'-0"  
 VERTICAL SCALE: 1" = 10'-0"

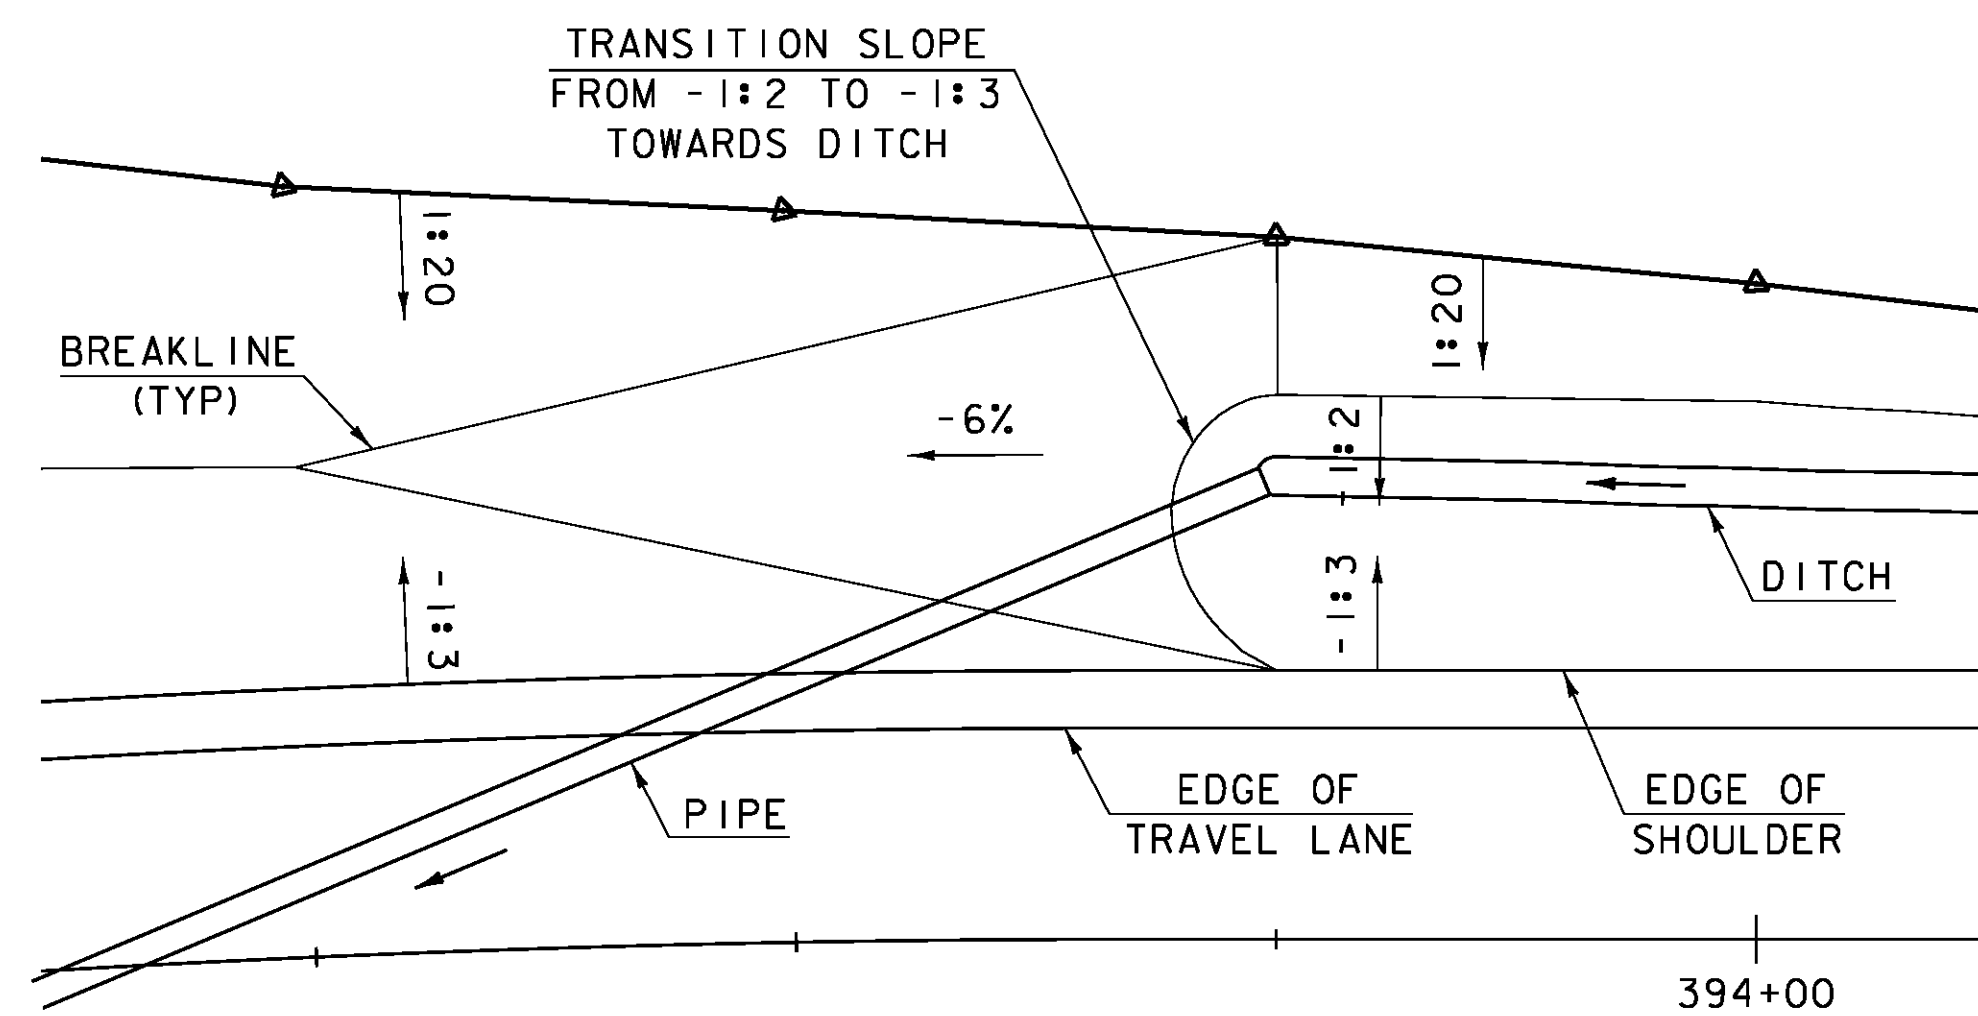

**GRADING PLAN**

SCALE: 1" = 10'-0"

|                                     |                         |
|-------------------------------------|-------------------------|
| PROJECT NAME: ROYALTON              | PLLOT DATE: 08-OCT-2013 |
| PROJECT NUMBER: BRS 0147 (13)       | DRAWN BY: G. ROY        |
| FILE NAME: \BR 27\s86e055xsl.27.dgn | CHECKED BY: D. PETERSON |
| PROJECT LEADER: C. CARLSON          | SHEET 62 OF 186         |
| DESIGNED BY: G. ROY                 |                         |
| BRIDGE 27 VT 14 PIPE PROFILE        |                         |