


BED T #11
15+35 39.5' LT

BED HH #4
15+35 26.2' LT


16+95 TO 20+50
CONDUIT BUILT PER PLAN

2 - ADDITIONAL 4" BED DUCTS
FROM HH #4 TO EXISTING DUCTS
TO CHARLEBOIS GARAGE AT 16+95 LT.

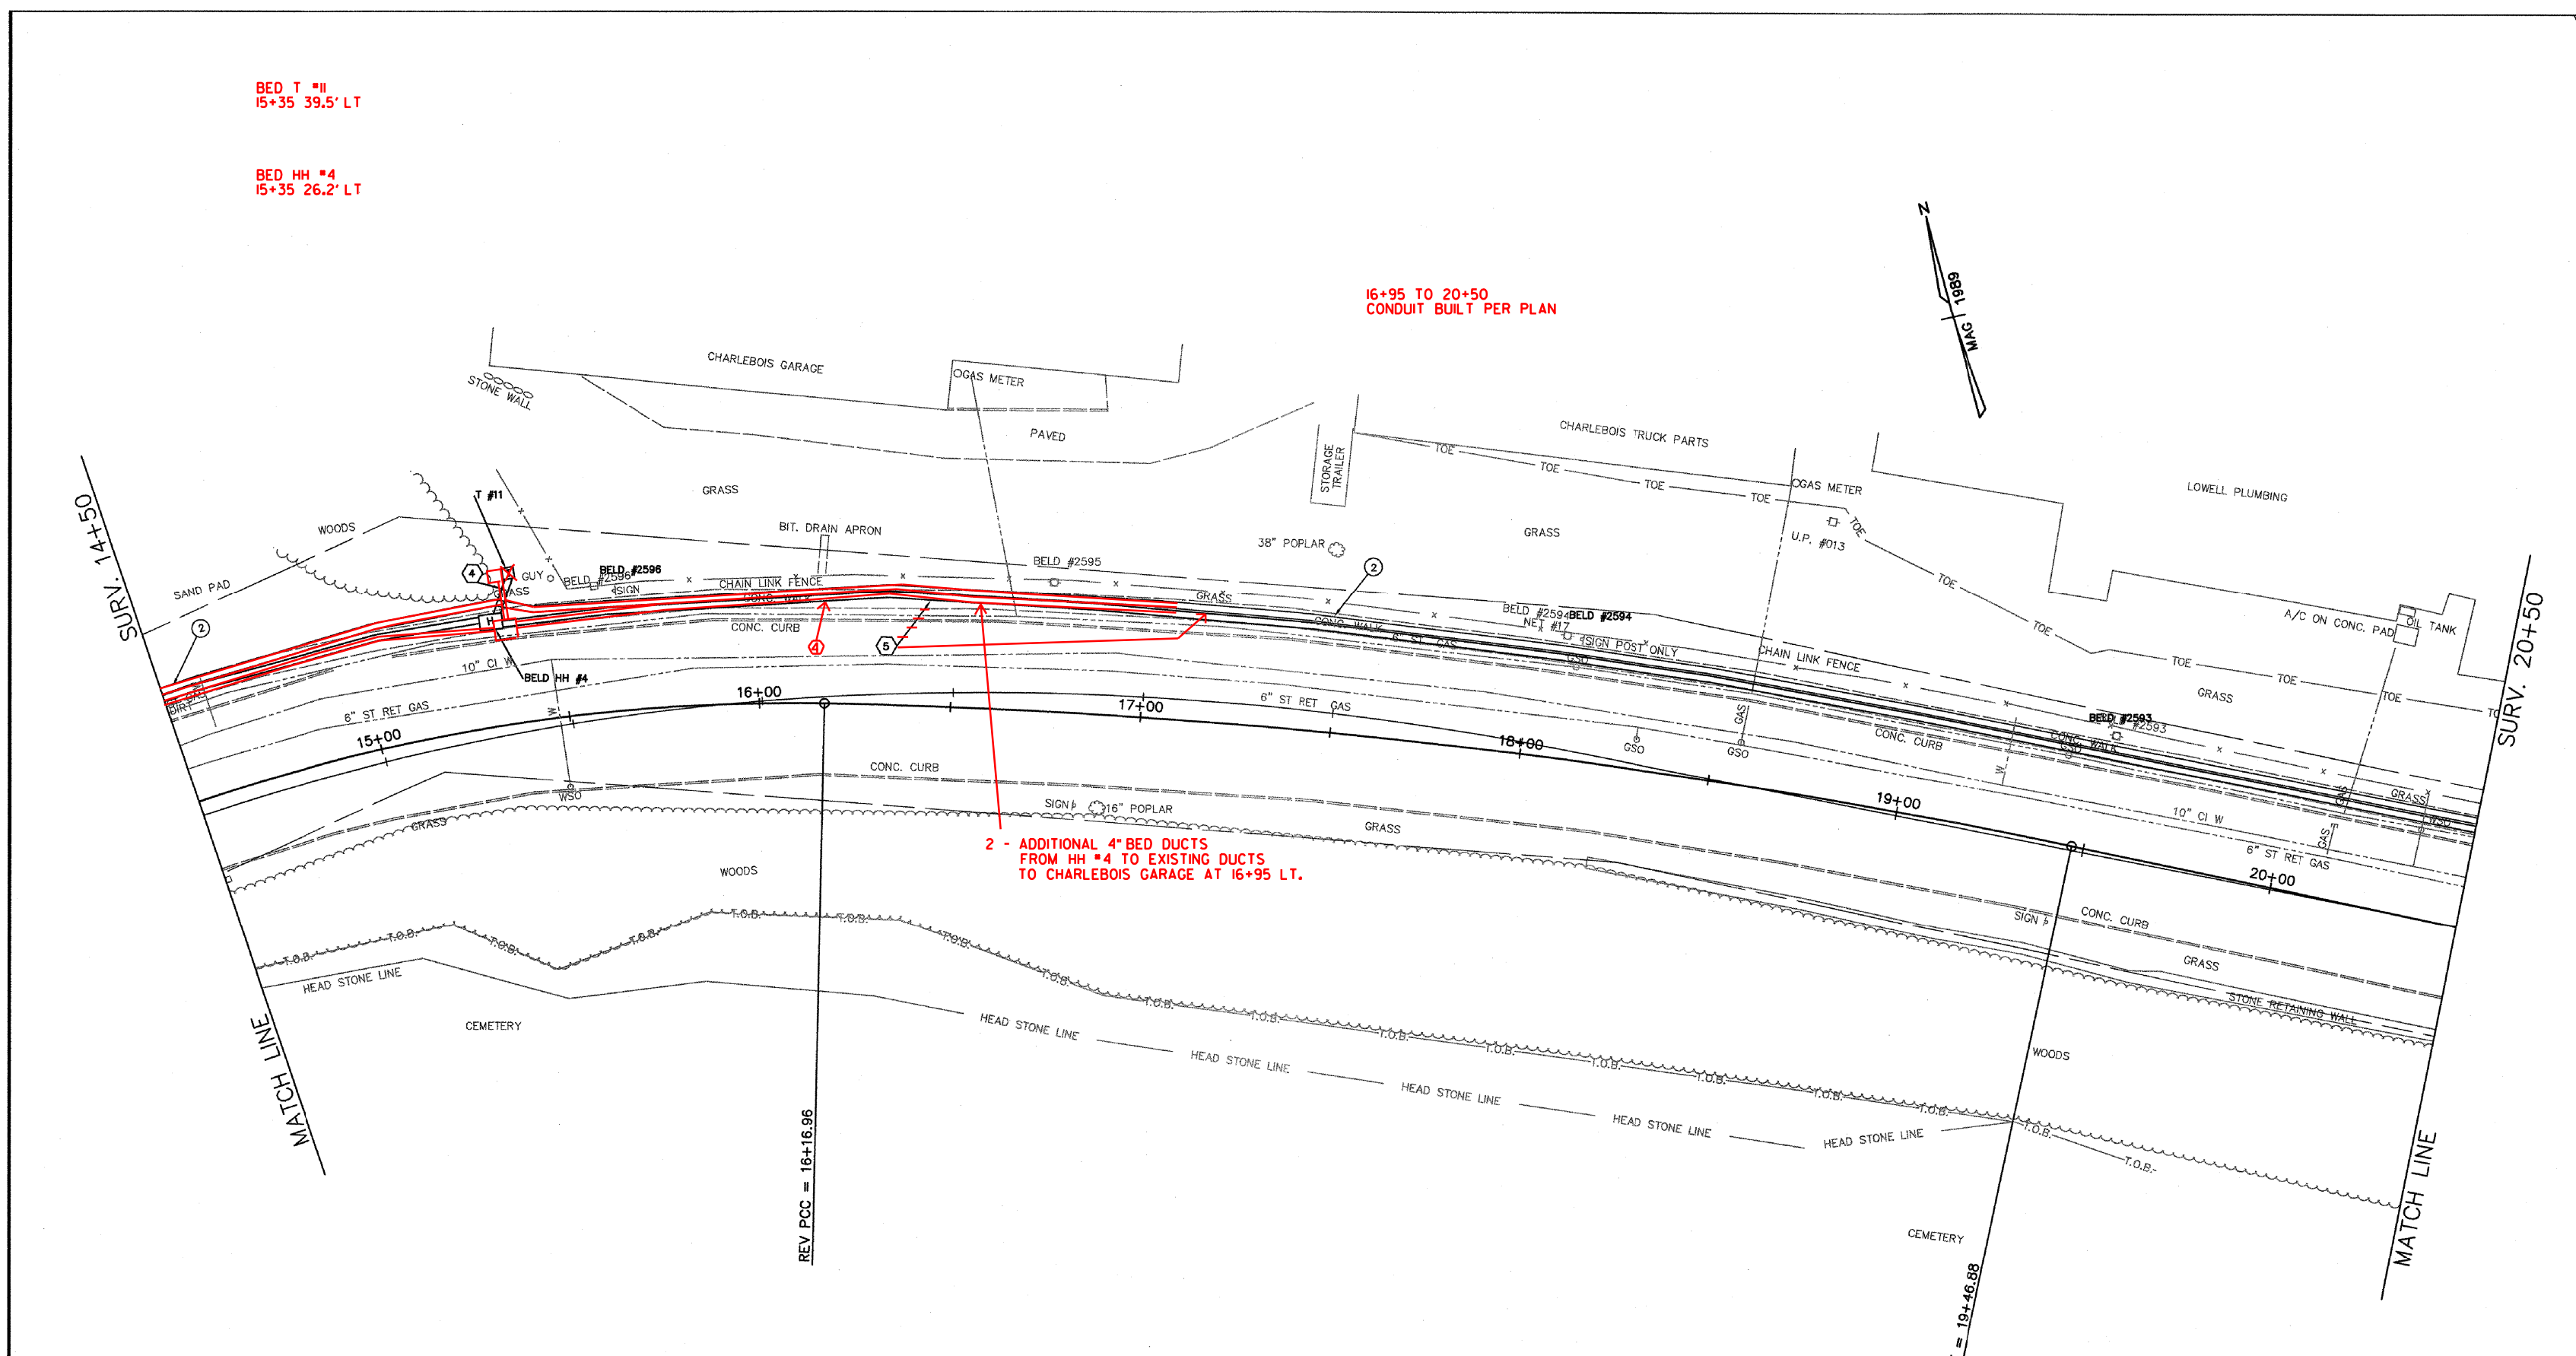

VIEW: CS2

DATUM	
VERTICAL	NGVD 1929
HORIZONTAL	N/A

 

UNDERGROUND UTILITY PLAN			
SURVEYED BY	CLD	DATE	7/89
DRAWN BY	TUS	DATE	10/93
SQUAD LEADER	JAW		
DESIGN FILE NO.	89-108		
IPARM FILE		DATE PLOTTED	JUN 30 2004
PROJECT NAME:	BURLINGTON		
PROJECT NUMBER:	MEGC 5000(15)		
SHEET 85 OF 252 SHEETS			