


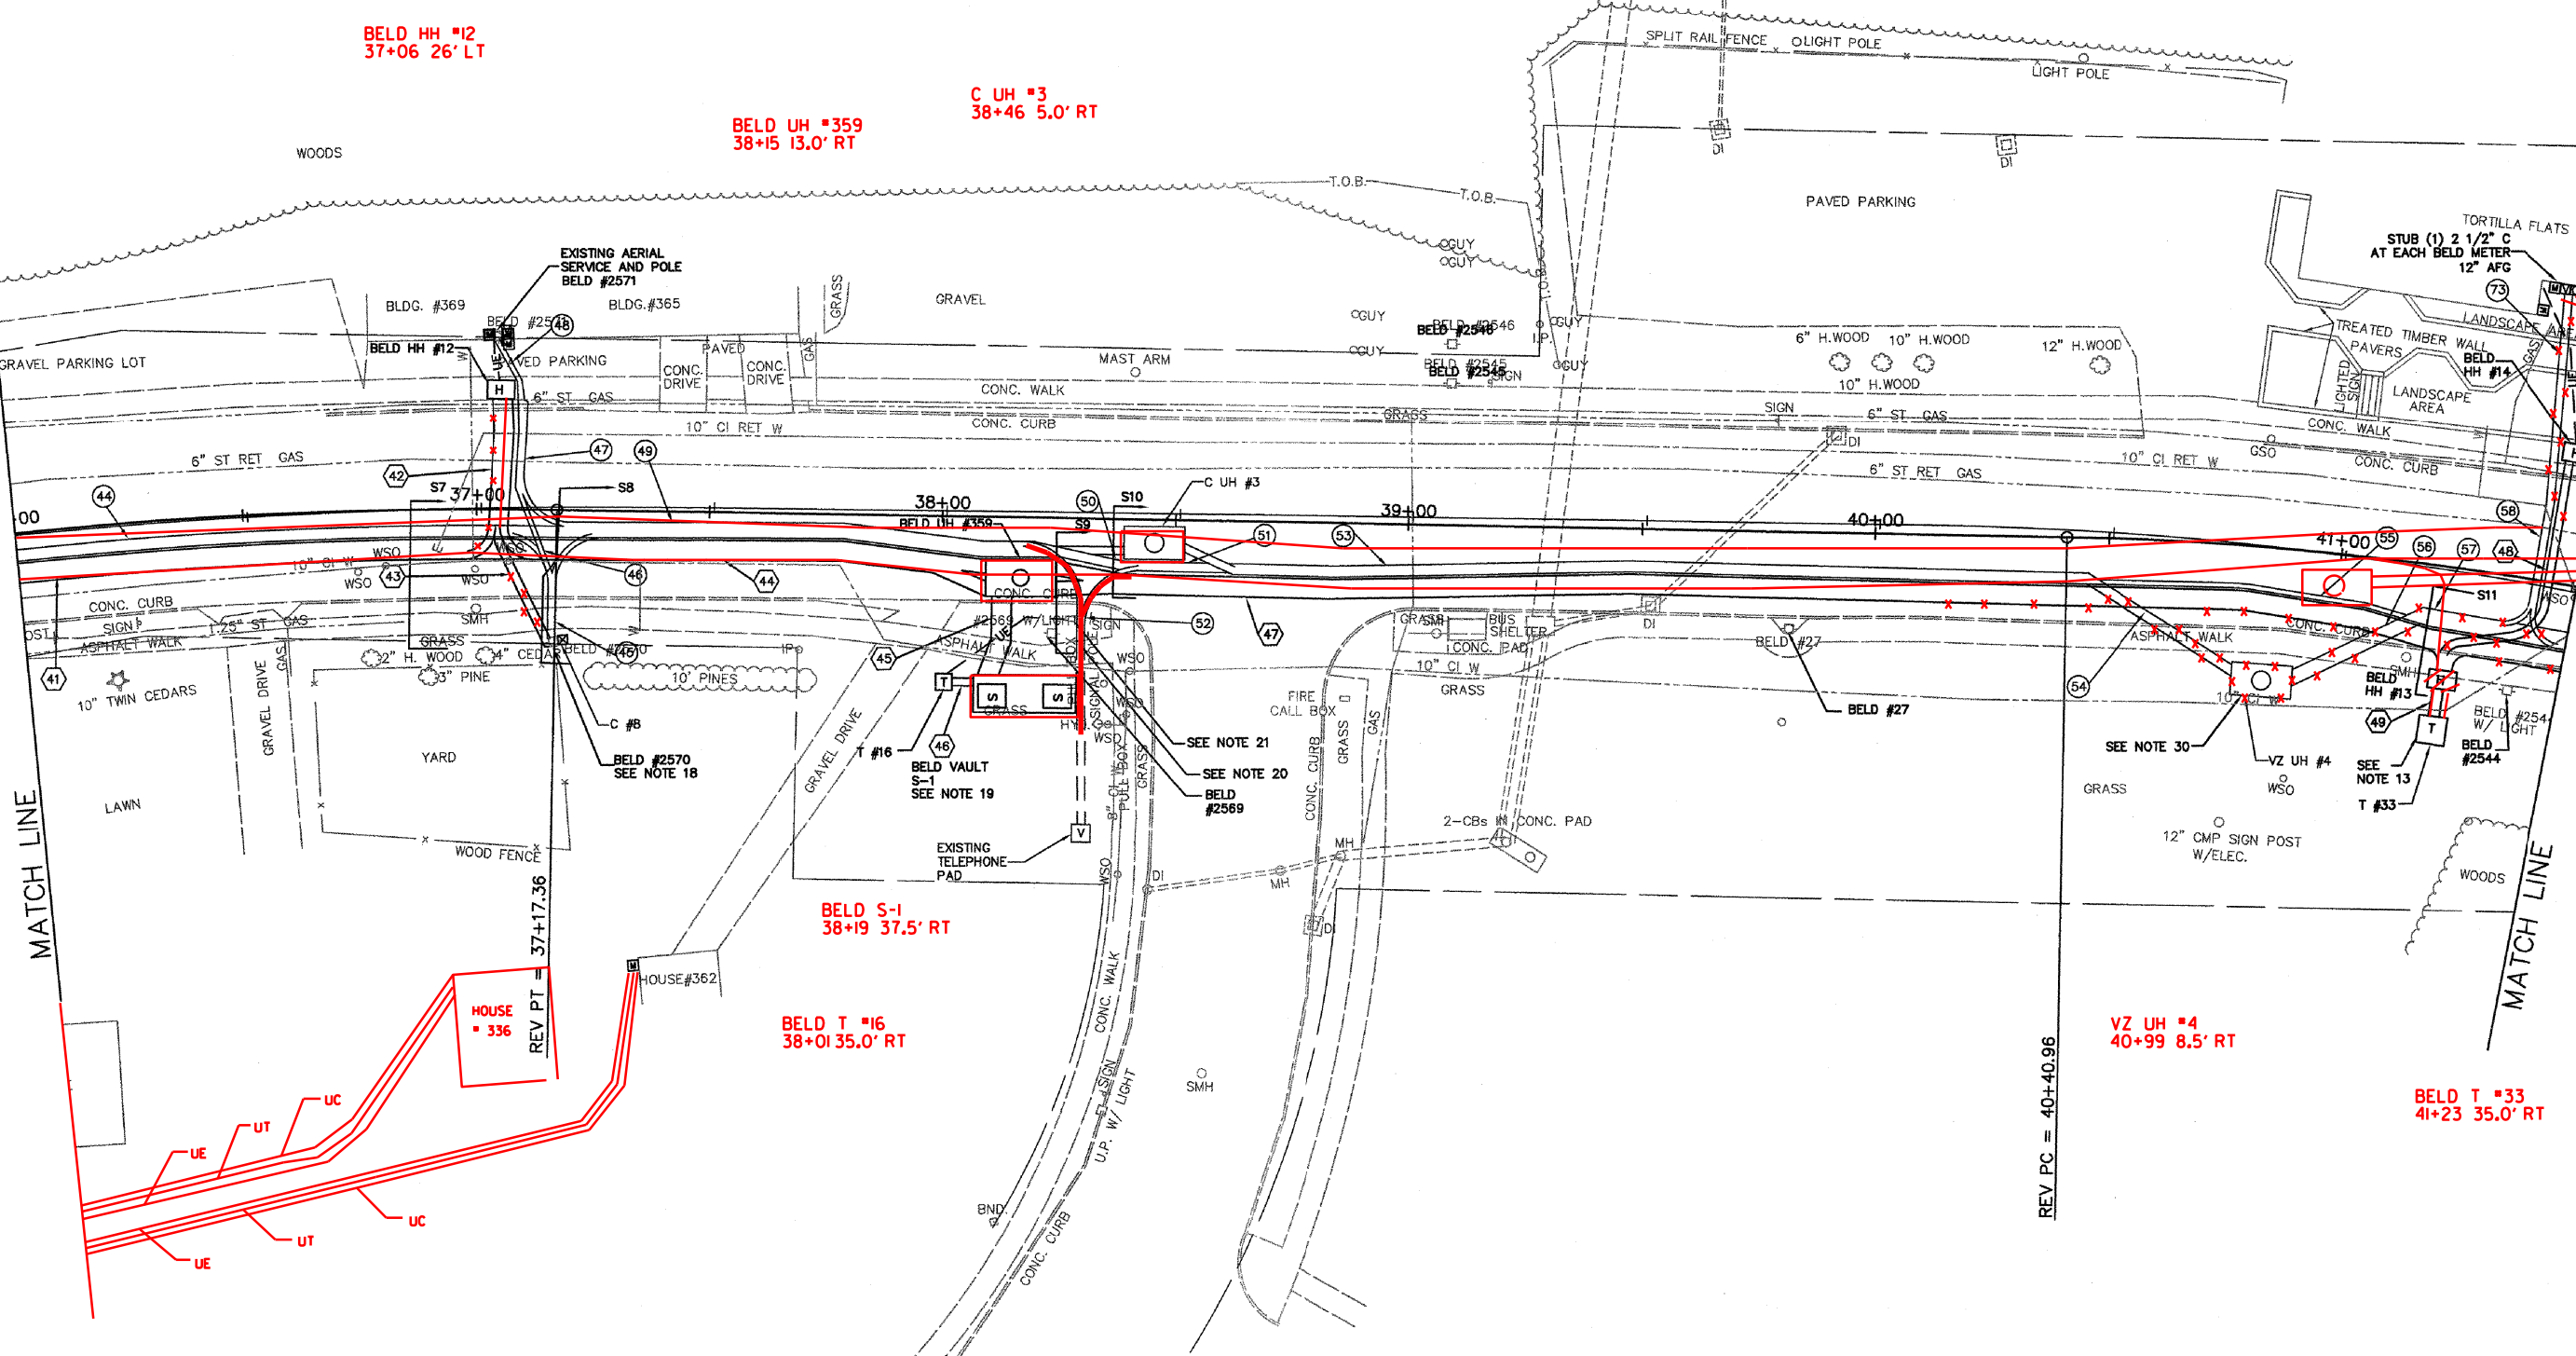

SURV. 36+00

SURV. 41+50

 


3-4" CONDUITS FOR BED INSTEAD OF 3-2.5" CONDUITS

BELD HH #13 ELIMINATED.
DUCTS RUN DIRECTLY TO T 33.
JOHN ASKEW FIELD ADJUSTMENT 7-28-05

VIEW: CS6

DATUM	
VERTICAL	NGVD 1929
HORIZONTAL	N/A



UNDERGROUND UTILITY PLAN

SURVEYED BY	GLD	DATE	7/89
DRAWN BY	TJS	DATE	10/83
SQUAD LEADER	JAW		
DESIGN FILE NO.	89-108		
IPARM FILE		DATE PLOTTED	
PROJECT NAME:	BURLINGTON		
PROJECT NUMBER:	MEGC 5000(15)		
SHEET 89 OF 252 SHEETS			