



- 3 605.10 6 INCH UNDERDRAIN PIPE  
 STA 110+12.50 LT - 108+44.16 LT  
 NEW 6" X 168' UNDERDRAIN PIPE  
 W/FLUSHING BASIN @ STA 110+12.50 LT
- 4 ~~STA 110+12.50 RT - 108+55.00 RT~~  
 NEW 6" X 158' UNDERDRAIN PIPE  
 W/FLUSHING BASIN @ ~~STA 110+12.50 RT~~

- 4 EXISTING DRAINAGE  
 STA 111+40.70 LT - 111+08.21 LT  
 EXISTING 15" CGMP = ~~RETAIN~~ REPLACED W/ 15" CPEP & CPEPES (2)
- 619.17 YIELDING MARKER POSTS  
 STA 110+12.50 LT  
 STA 110+12.50 RT

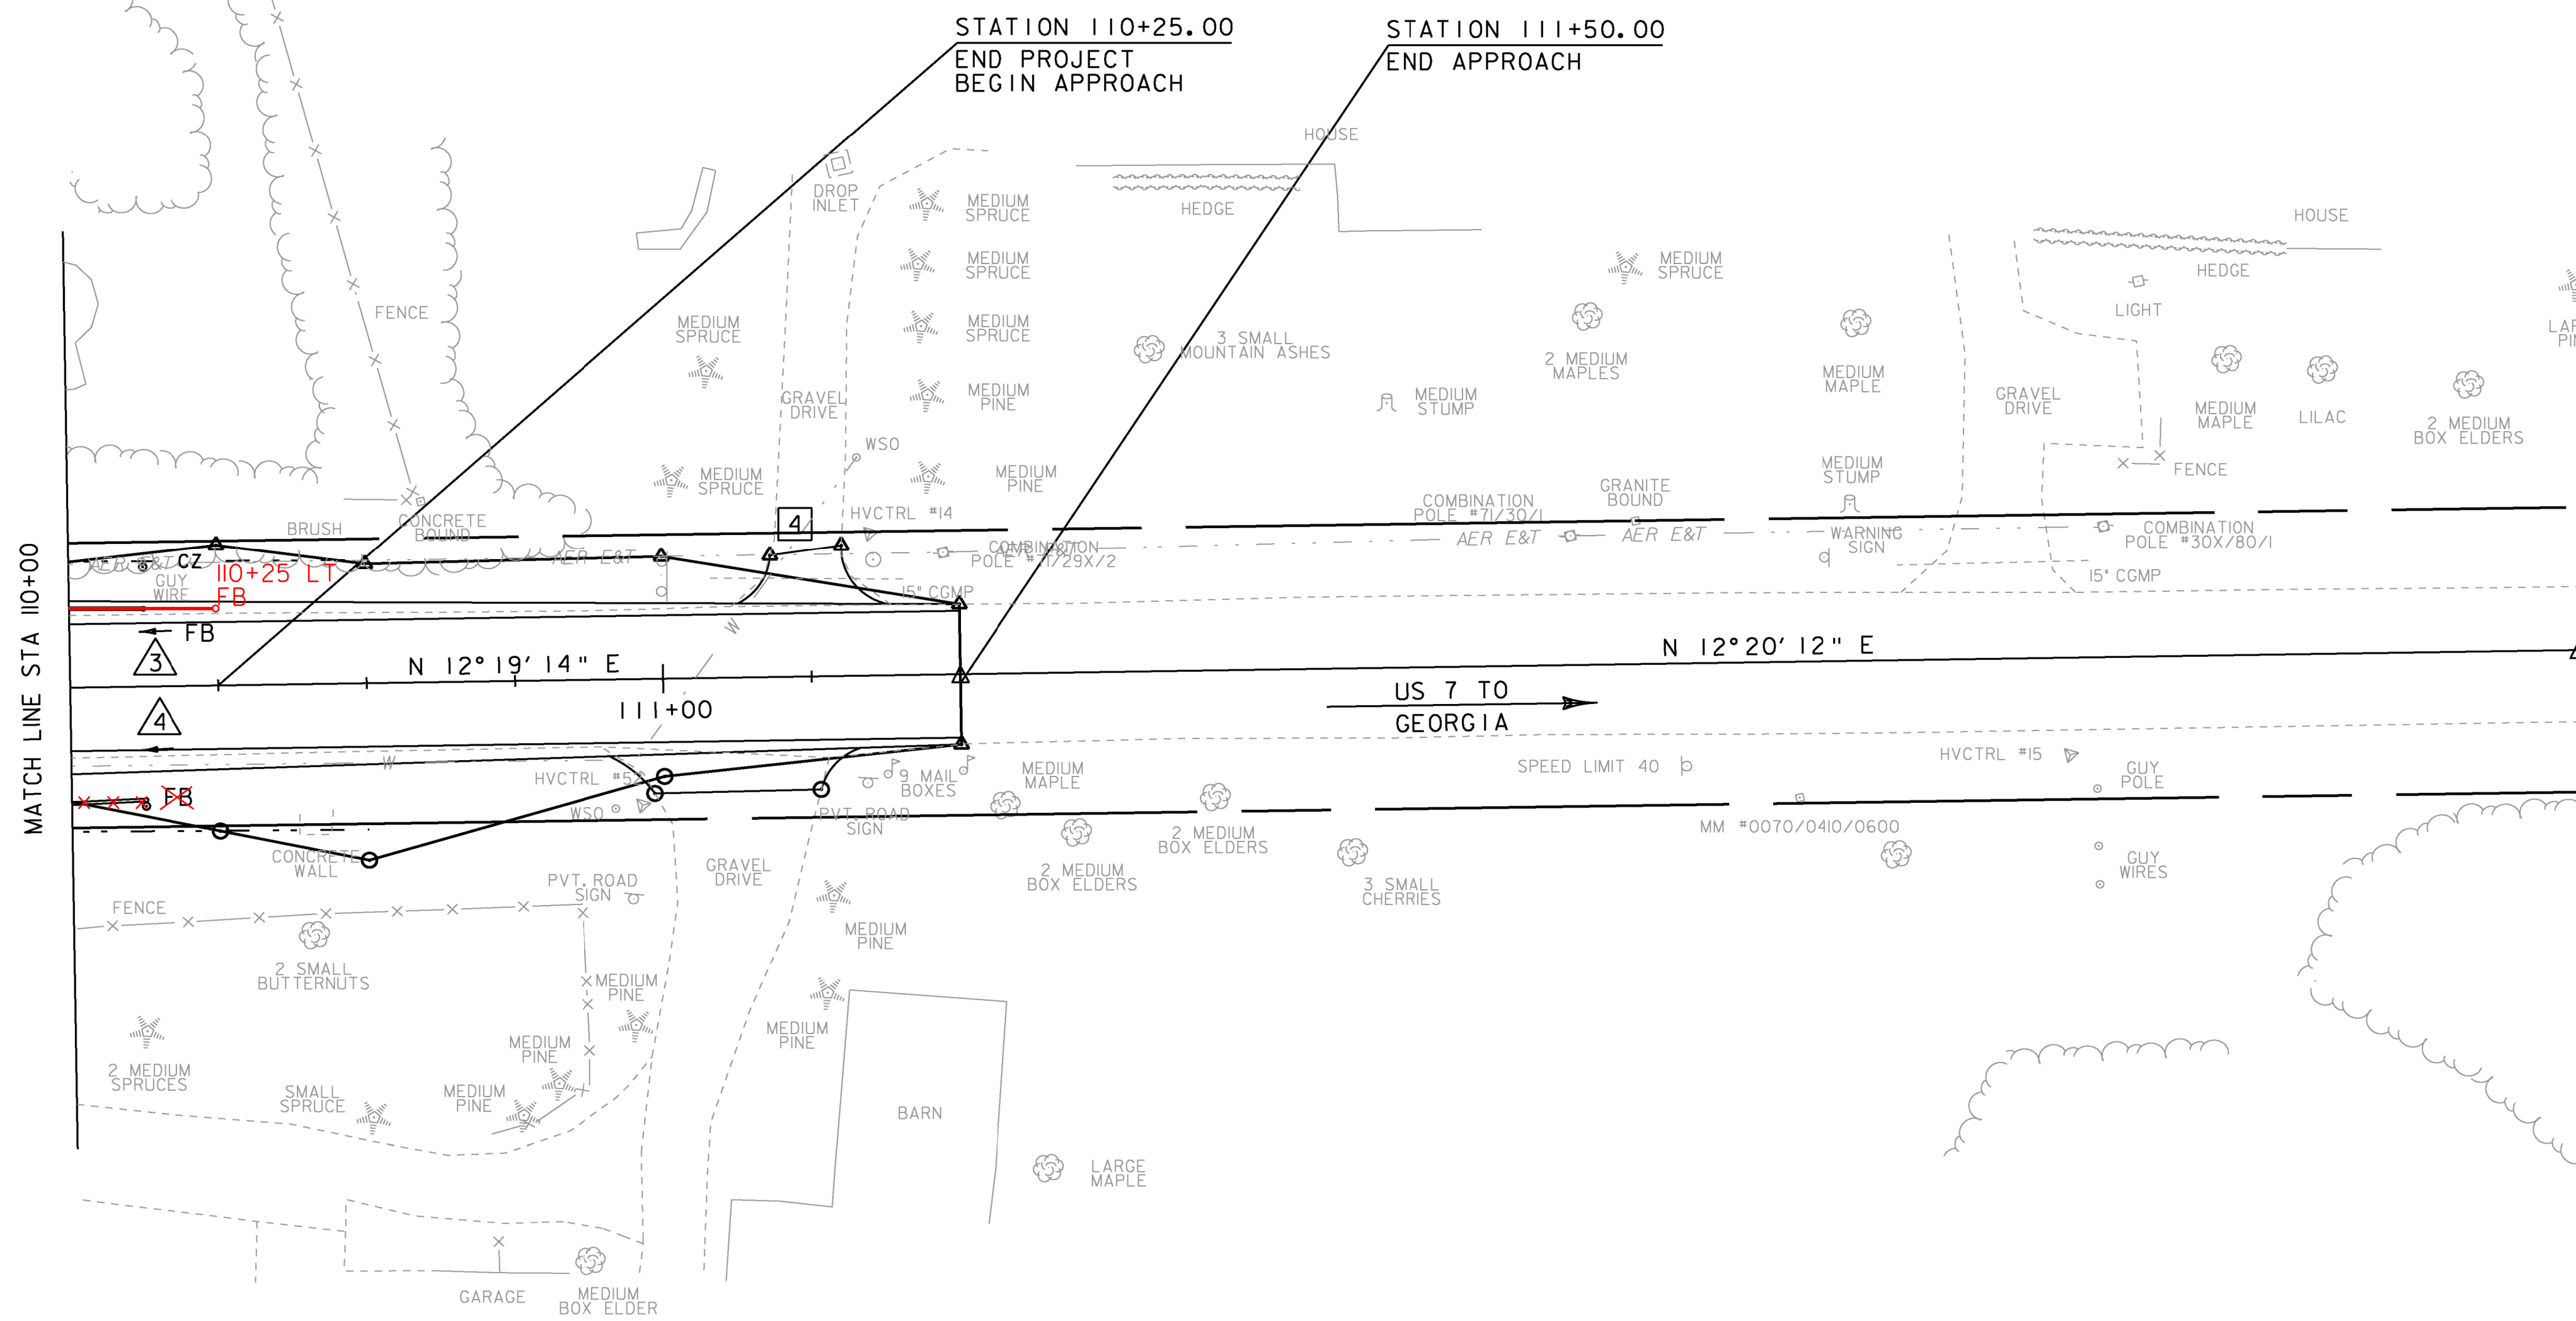

EXISTING & PROPOSED WATERLINES  
 ARE FOR REFERENCE ONLY. PLEASE  
 REFER TO WATERLINE SHEETS 102-104

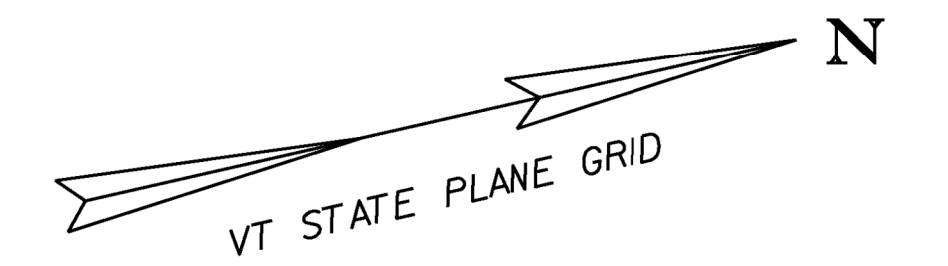

PROJECT NAME: MILTON	PLOT DATE: 23-FEB-2011
PROJECT NUMBER: STP 5800 (2)	DRAWN BY: D. LYMAN
FILE NAME: +92d289bdr.dgn	CHECKED BY: J. DEVLIN
PROJECT LEADER: J. SCHULTZ	SHEET 32 OF 104
DESIGNED BY: D. LYMAN	
DRAINAGE LAYOUT 3	