



104+00

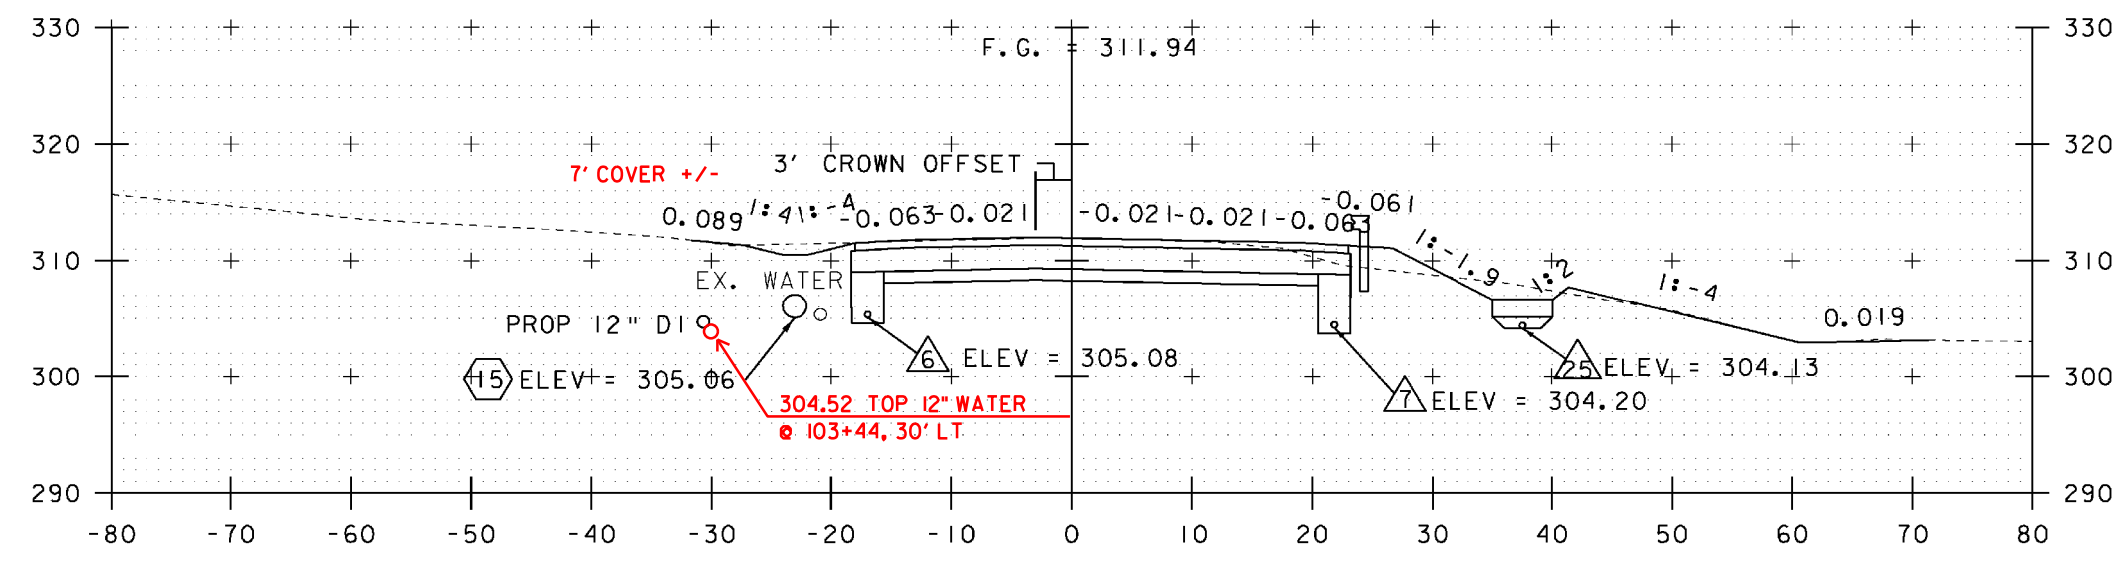

103+50

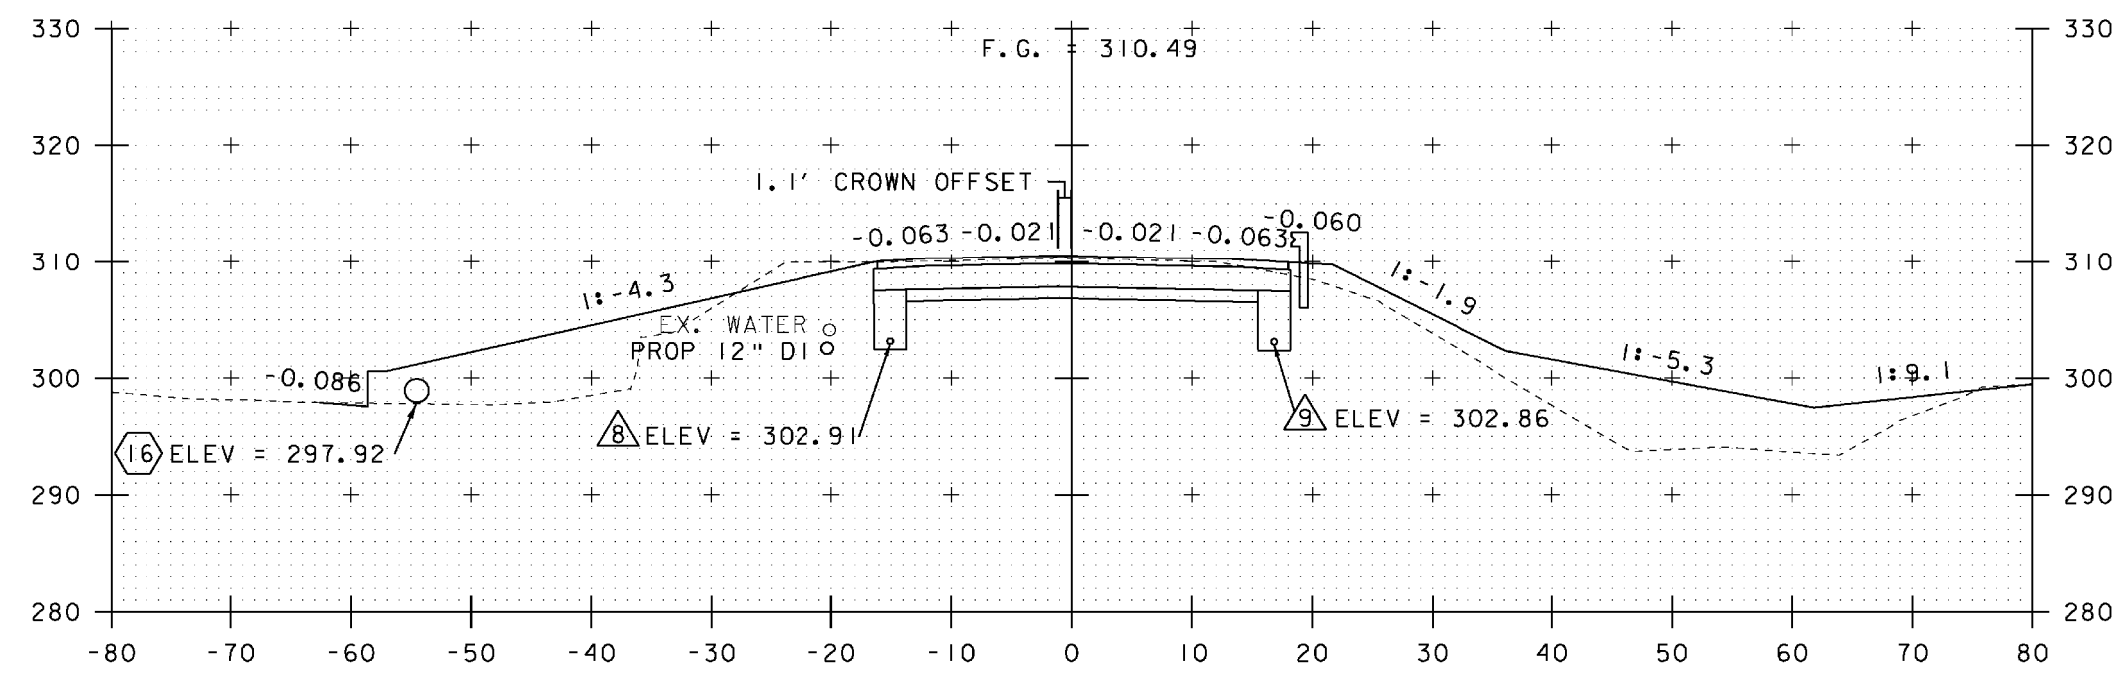

103+00

EXISTING & PROPOSED WATERLINES ARE FOR REFERENCE ONLY. PLEASE REFER TO WATERLINE SHEETS 102-104



PROJECT NAME: MILTON	PLOT DATE: 23-FEB-2011
PROJECT NUMBER: STP 5800 (2)	DRAWN BY: D. LYMAN
FILE NAME: 1920289xst.dgn	CHECKED BY: J. DEVLIN
PROJECT LEADER: J. SCHULTZ	SHEET 82 OF 104
DESIGNED BY: D. LYMAN	
US ROUTE 7 CROSS SECTION SHEET 5	

STA. 103+00 TO STA. 104+00

NOTE: DRAINAGE FEATURES ARE NOT PROJECTED ONTO CROSS SECTIONS. PLEASE REFER TO DRAINAGE LAYOUT AND DRAINAGE PROFILE SHEETS FOR DETAILED INFORMATION (TYP.)