

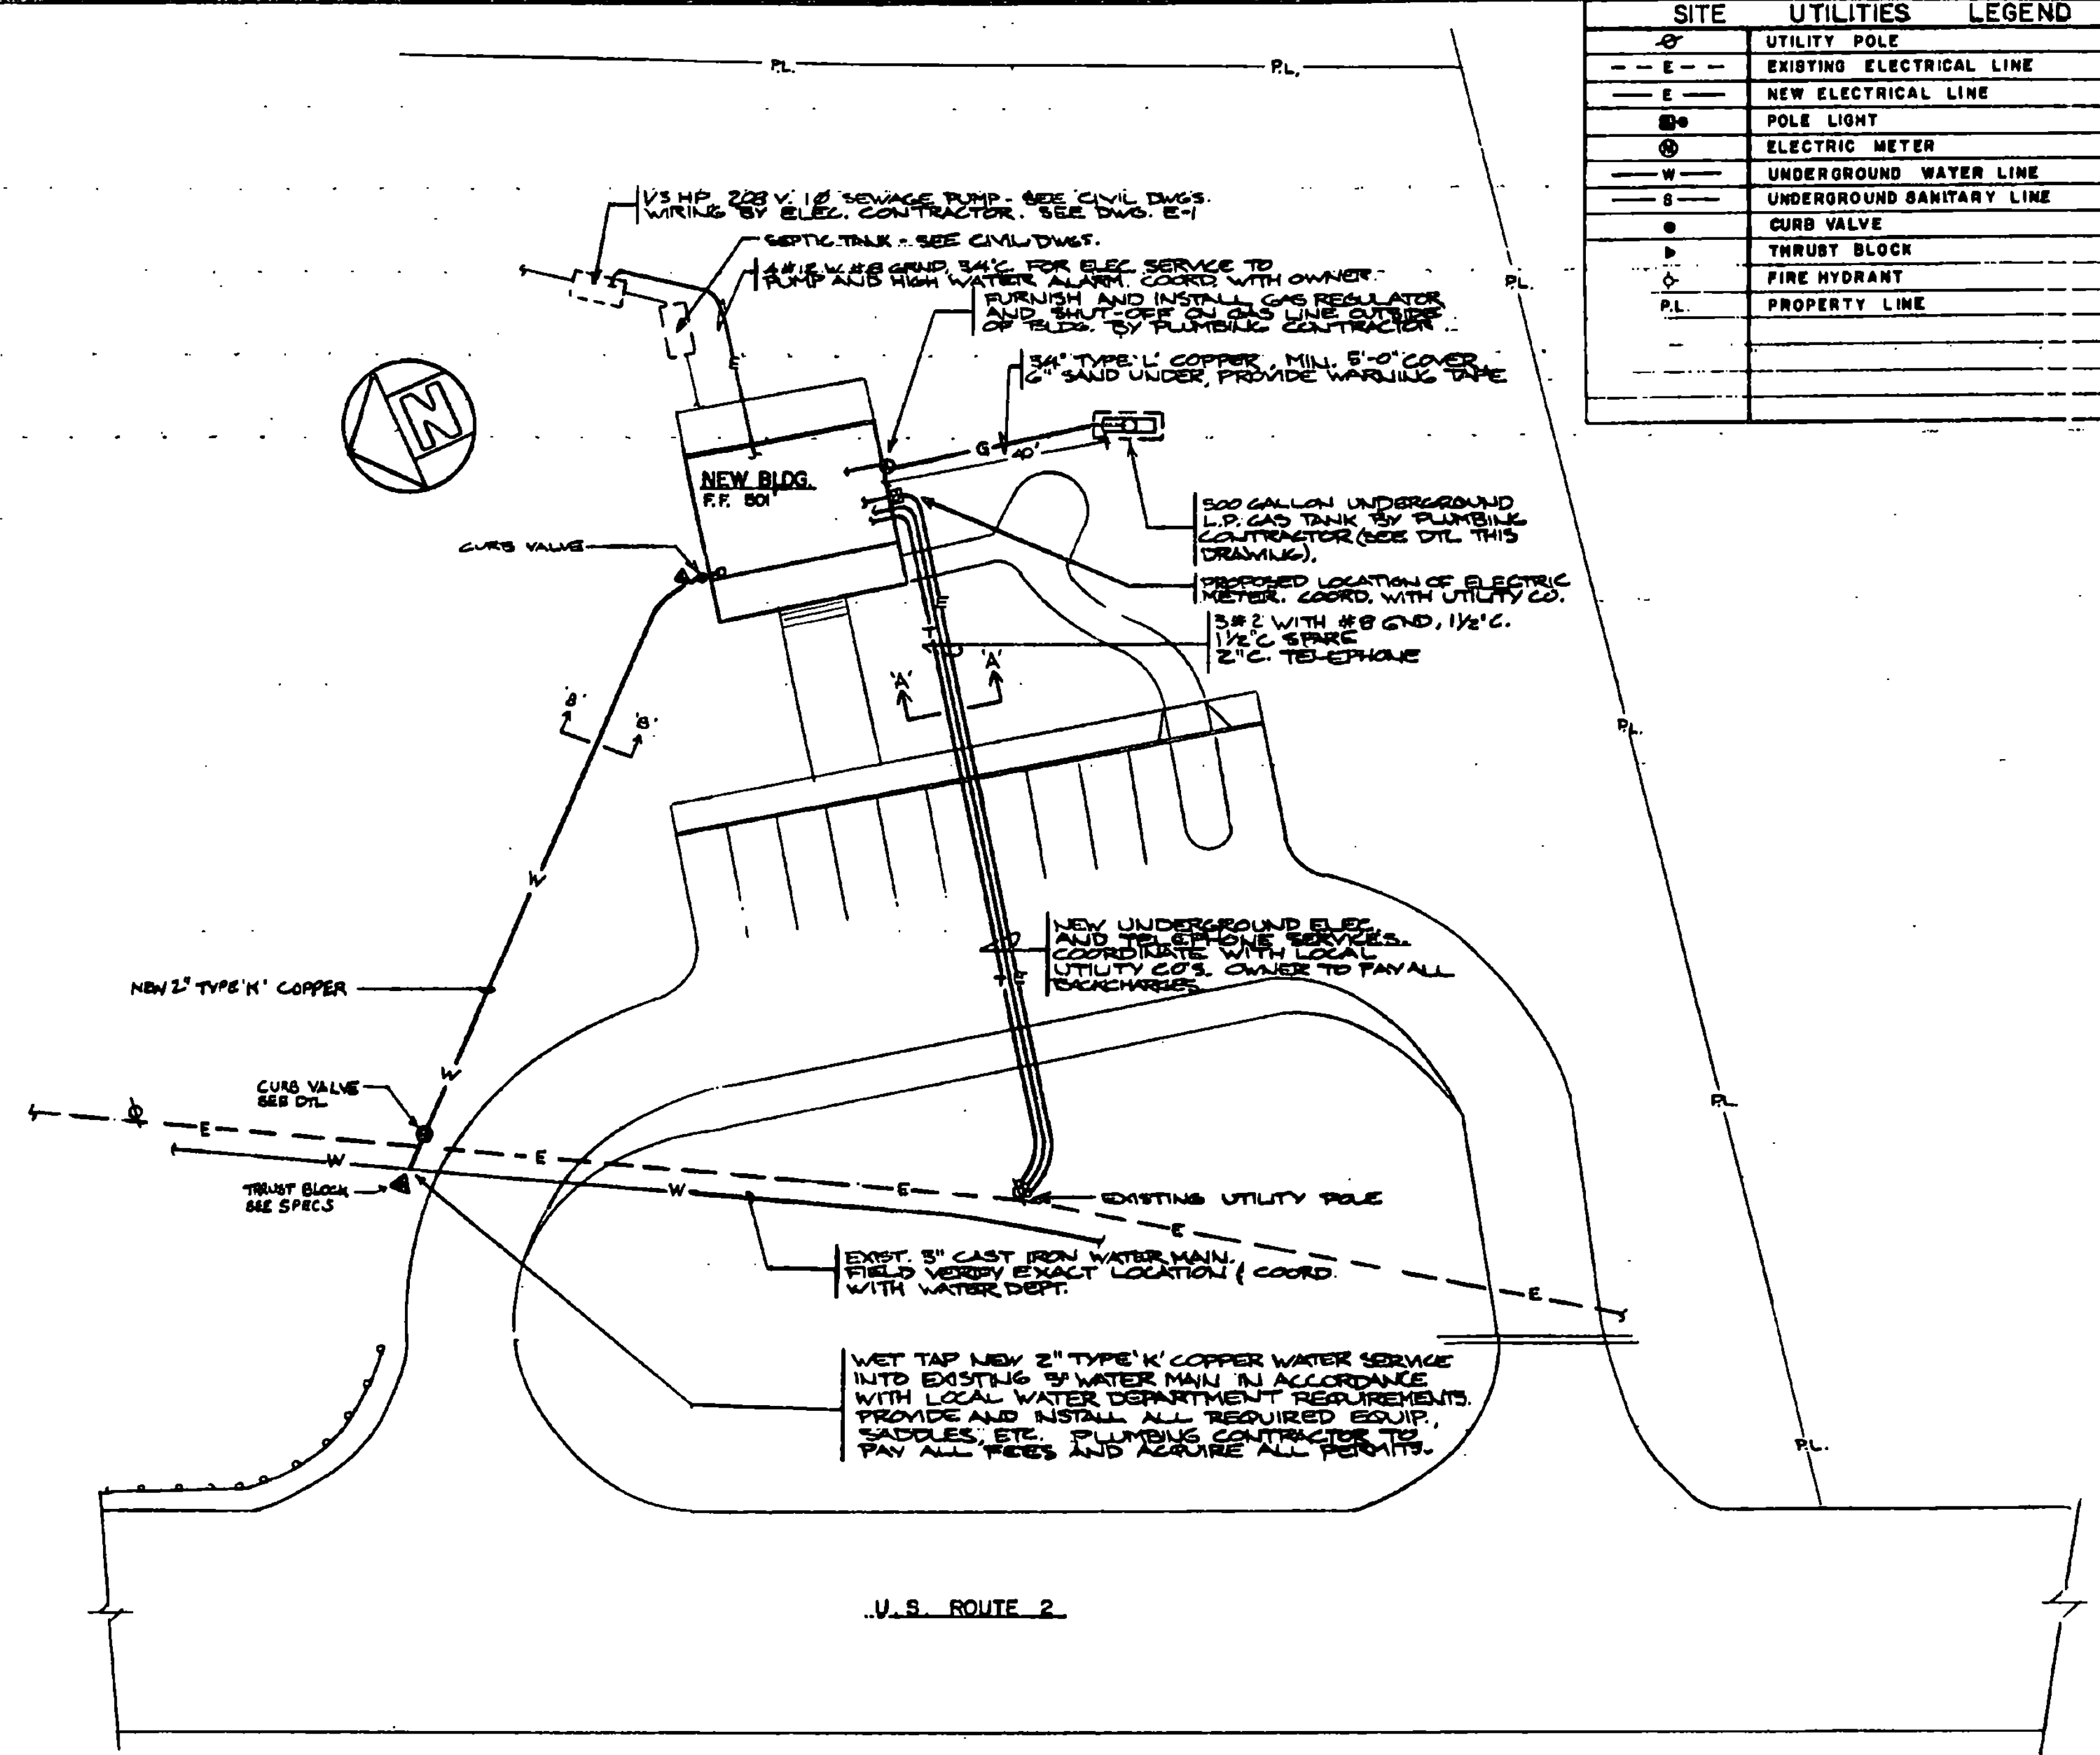
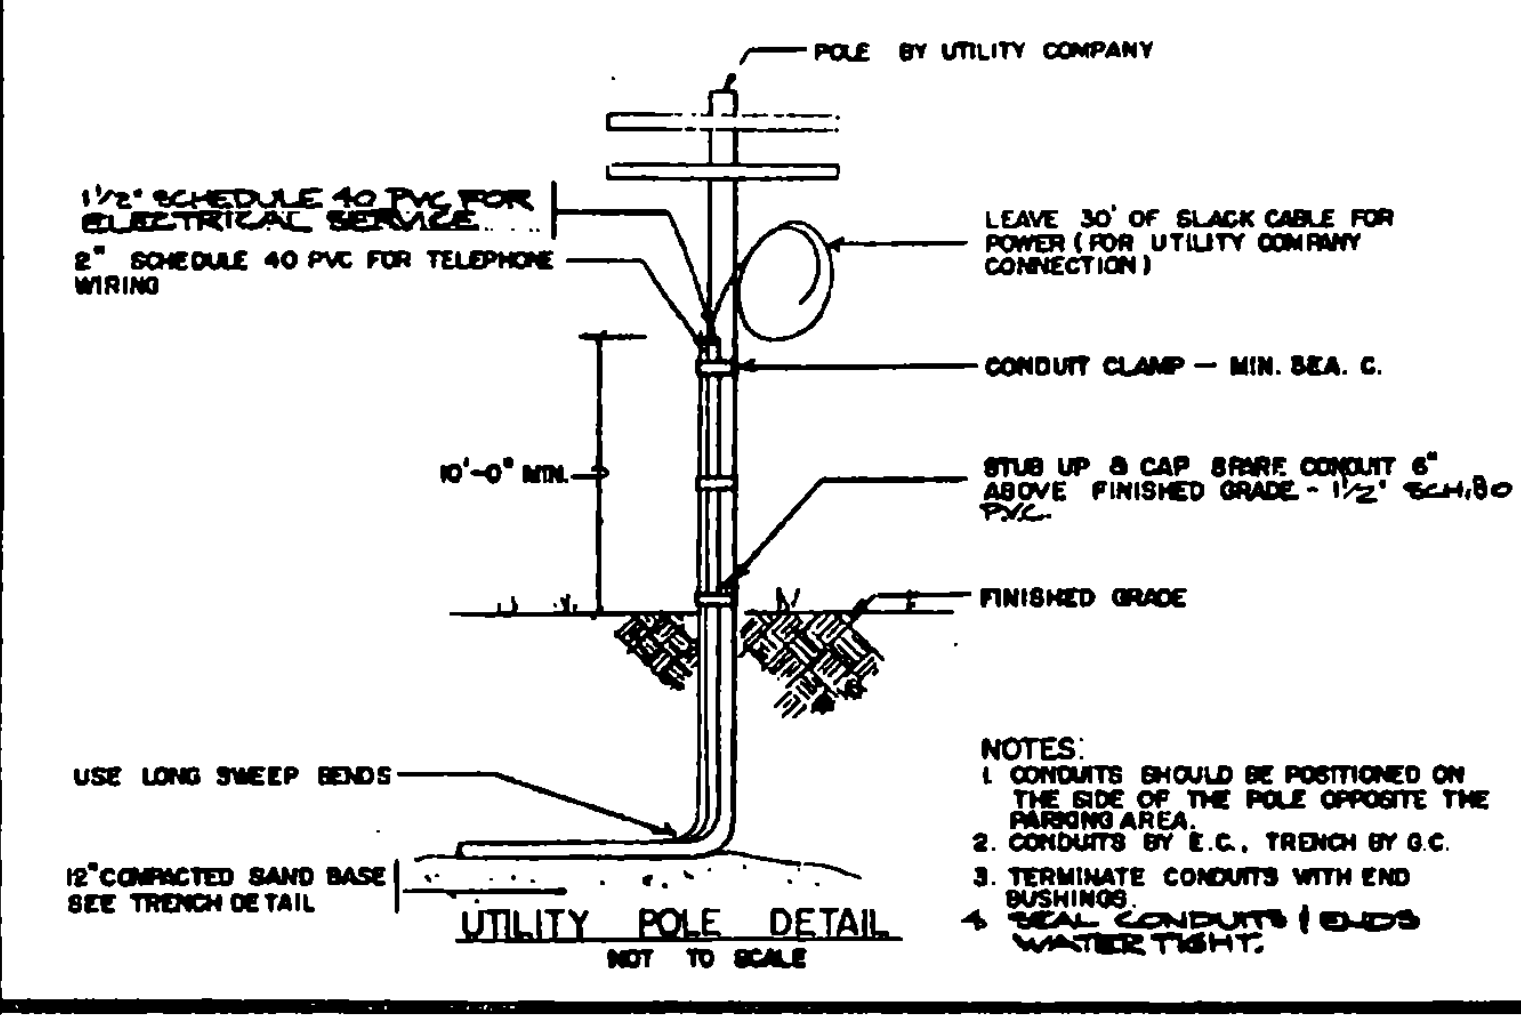
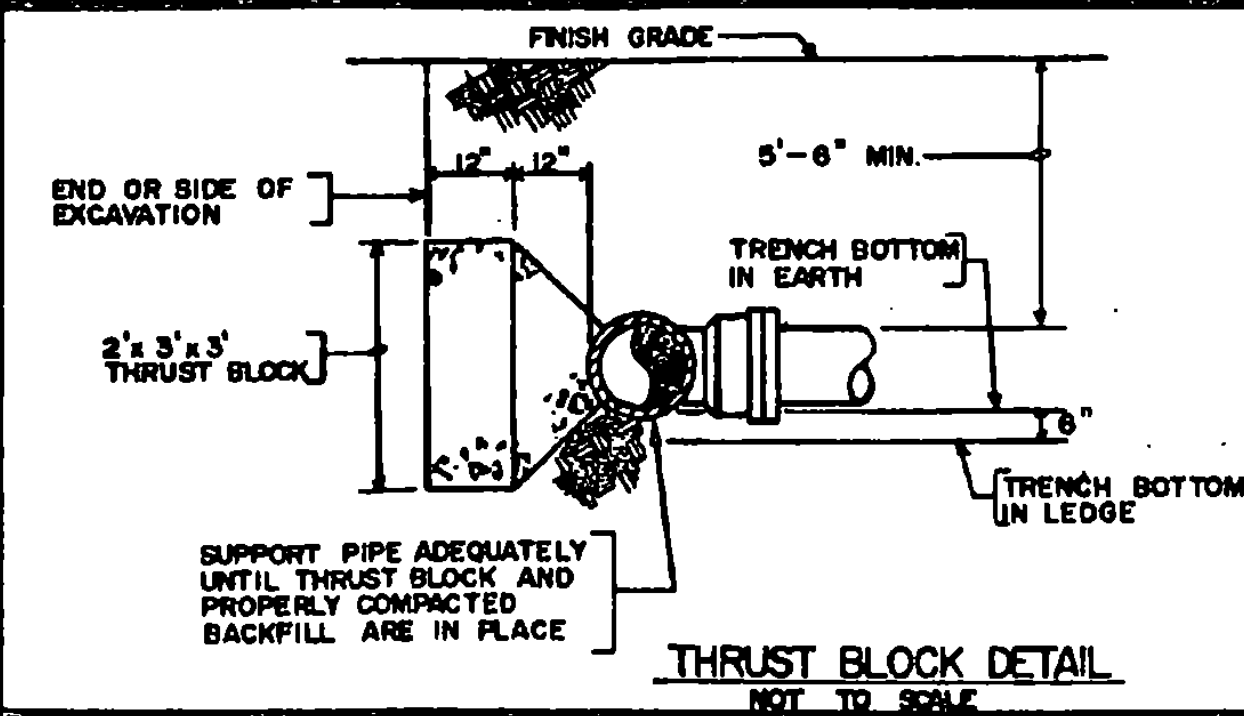
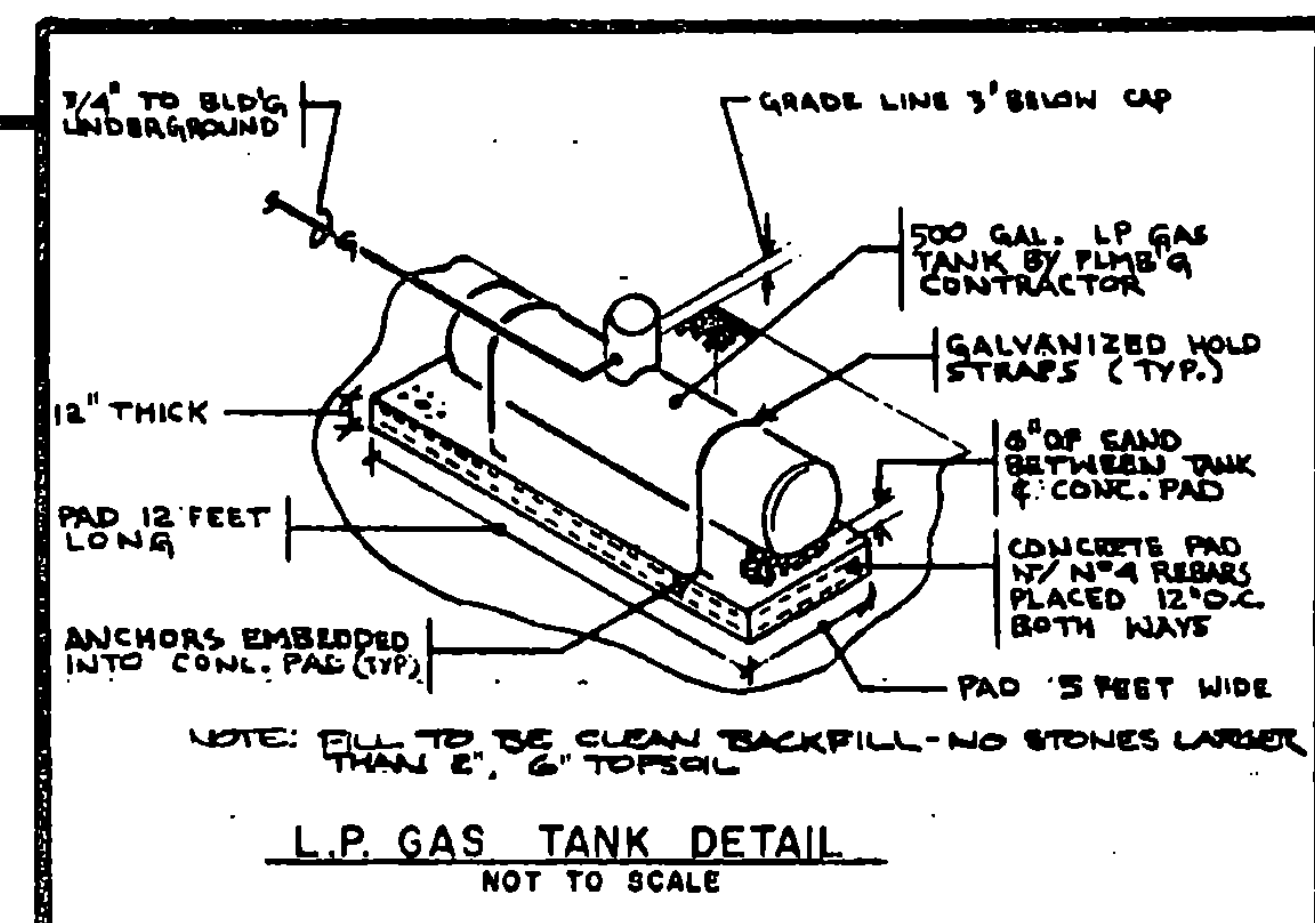


SITE UTILITIES LEGEND	
	UTILITY POLE
	EXISTING ELECTRICAL LINE
	NEW ELECTRICAL LINE
	POLE LIGHT
	ELECTRIC METER
	UNDERGROUND WATER LINE
	UNDERGROUND SANITARY LINE
	CURB VALVE
	THRUST BLOCK
	FIRE HYDRANT
	PROPERTY LINE

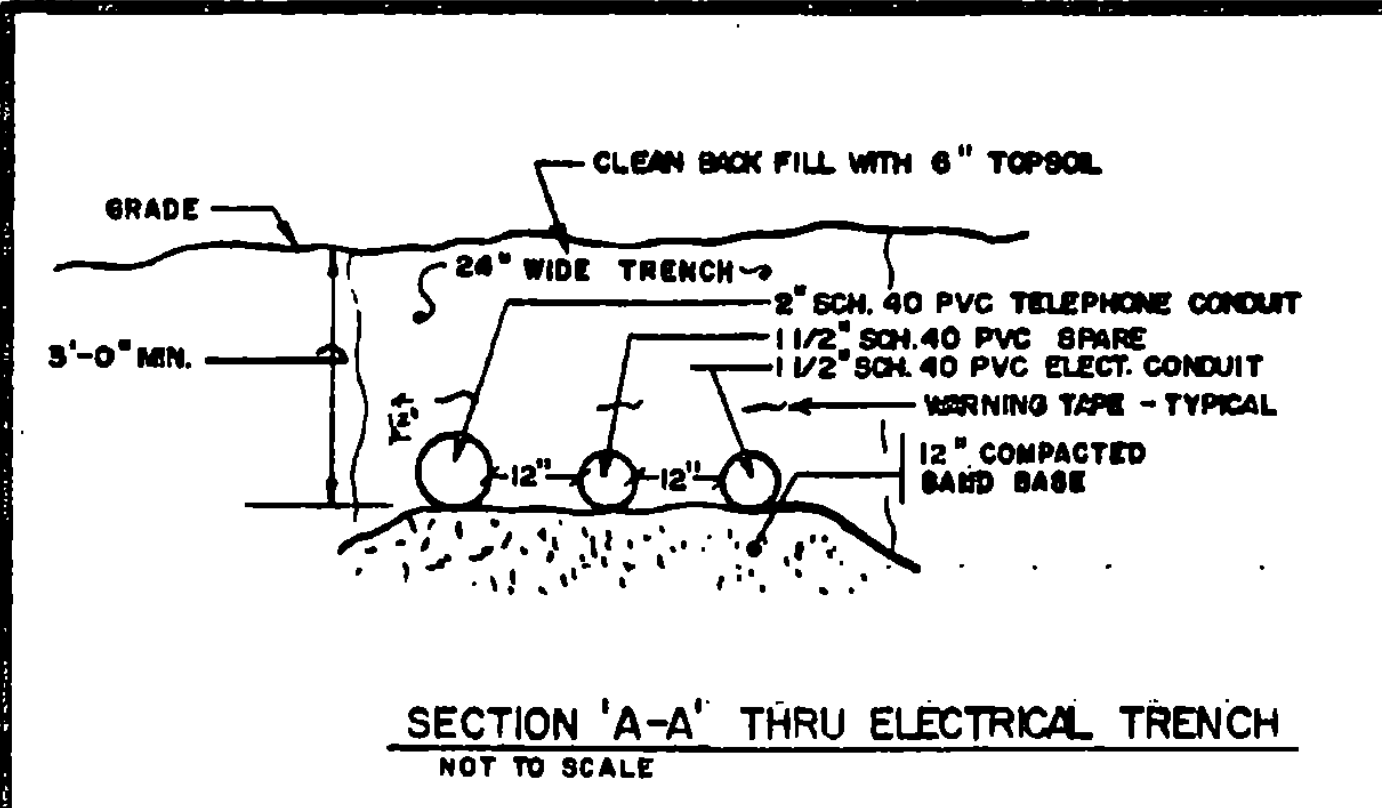

UTILITIES - SITE PLAN
SCALE: 1" = 20'-0"

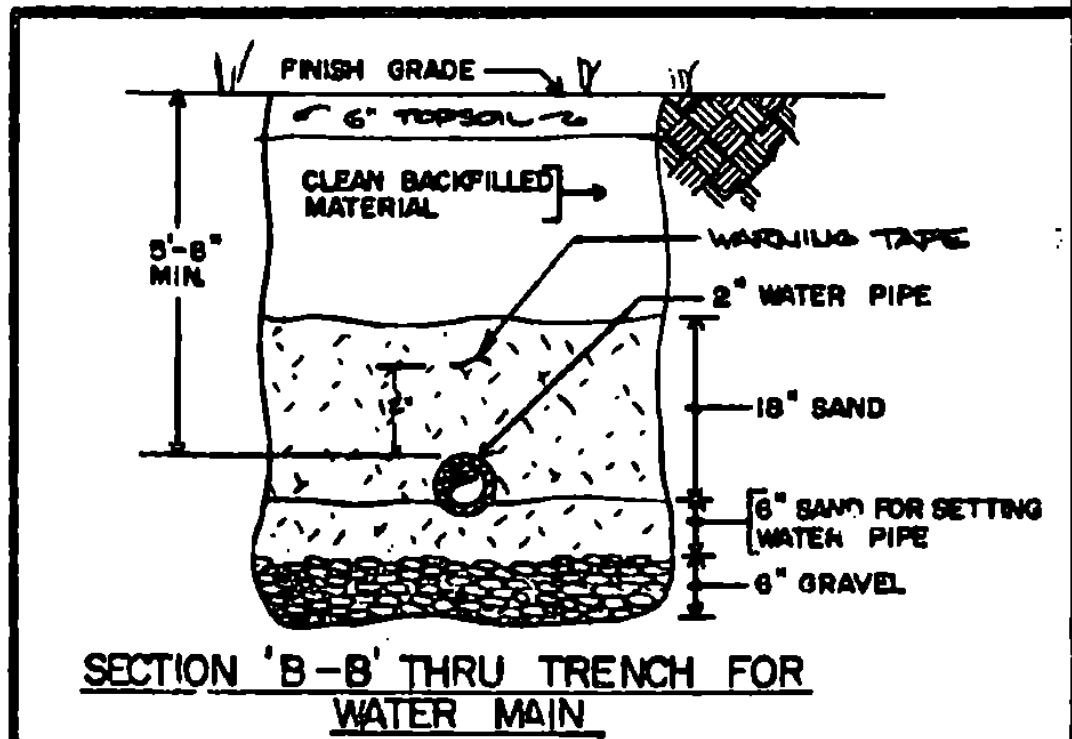

STATE OF VERMONT
 DEPARTMENT OF STATE BUILDINGS
 AGENCY OF ADMINISTRATION
 MONTPELIER, VERMONT

ALBURG WELCOME CENTER
ALBURG
 SITE UTILITIES - SITE PLAN, LEGENDS & DETAILS

DATE: 3-19-96	SCALE: AS NOTED	REVISIONS: 5-22-96	DWG. NO. U-1
DRAWN BY: ON	PROJECT NO. NH 028-1(17)S		10 of 21