


LEGEND

- AER E&T — AERIAL ELECTRIC & TELEPHONE
- ARCH — ARCHEOLOGICAL AREA
- HISTORIC — HISTORIC AREA
- P — PROPERTY LINE
- L — RIPARIAN BUFFER
- S — SANITARY SEWER PIPE

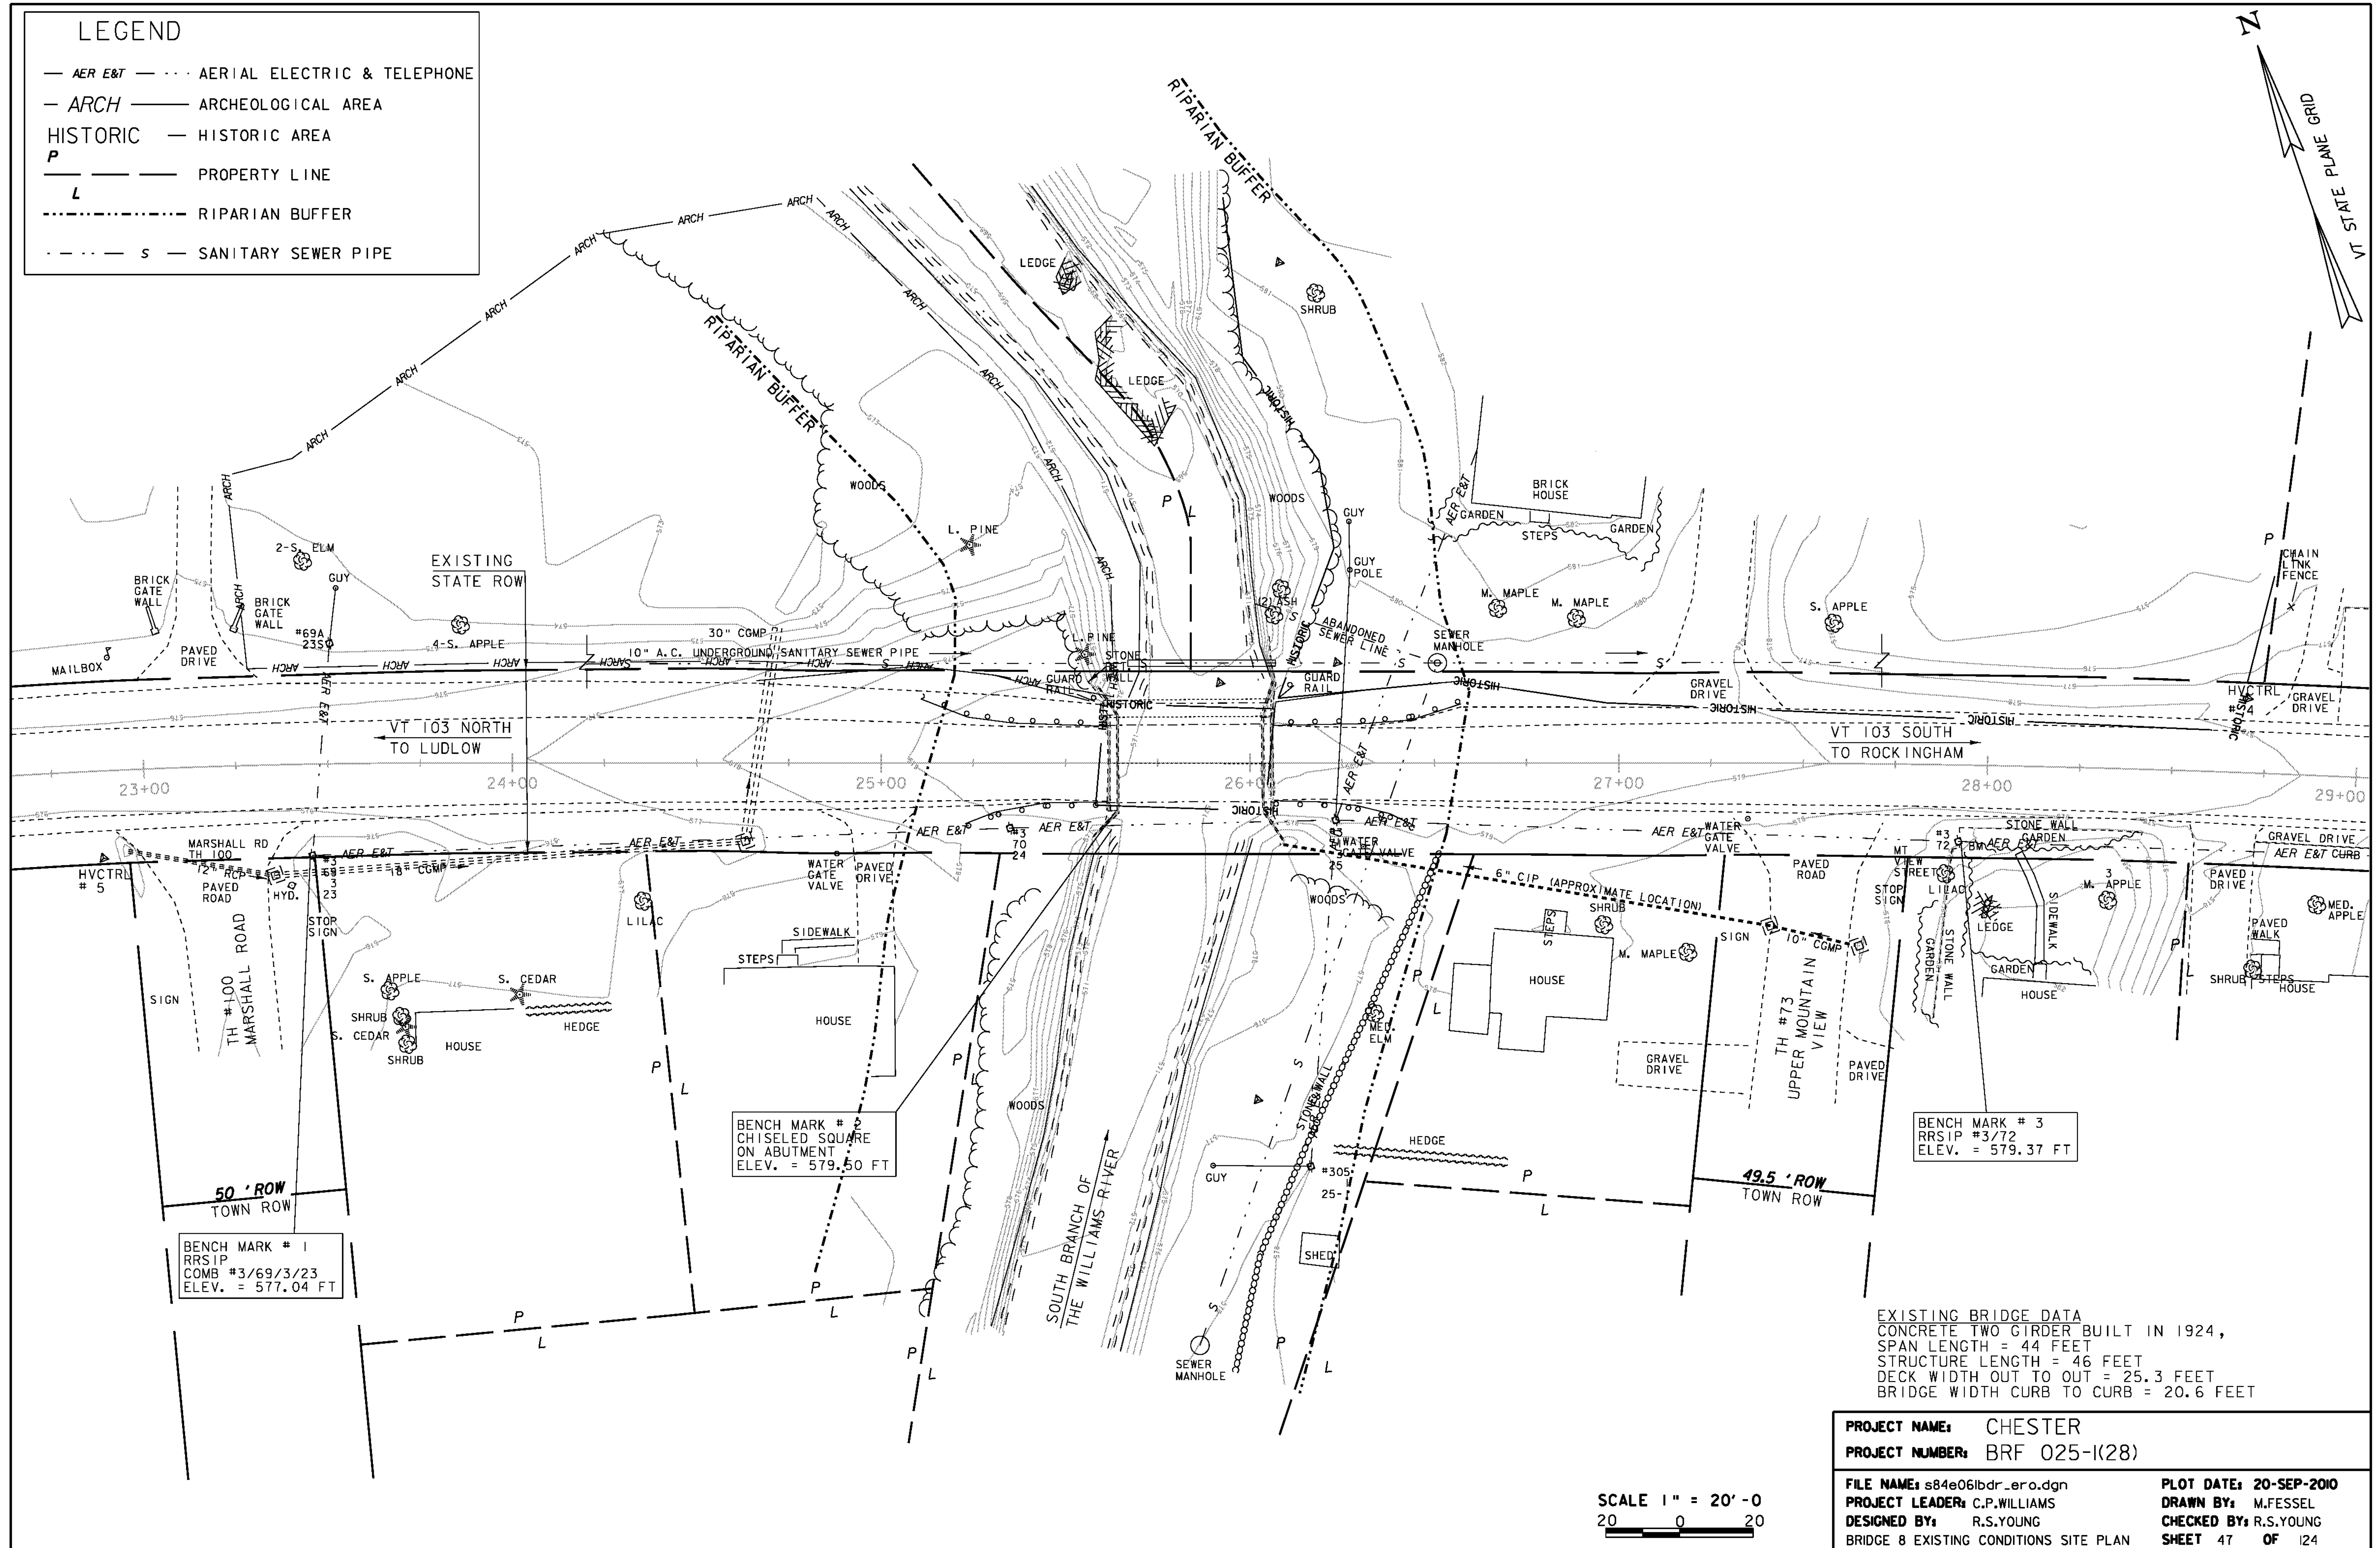

PROJECT NAME: CHESTER
PROJECT NUMBER: BRF 025-1(28)

FILE NAME: s84e06lbr_ero.dgn
PROJECT LEADER: C.P.WILLIAMS
DESIGNED BY: R.S.YOUNG
BRIDGE 8 EXISTING CONDITIONS SITE PLAN

PLOT DATE: 20-SEP-2010
DRAWN BY: M.FESSEL
CHECKED BY: R.S.YOUNG
SHEET 47 OF 124