



**PARAPET DISCHARGE PIPE CONNECTION DETAIL**

SCALE: 1:25

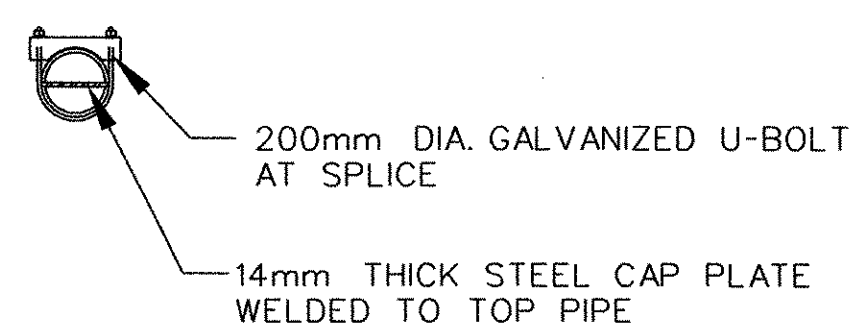


**SECTION A-A**

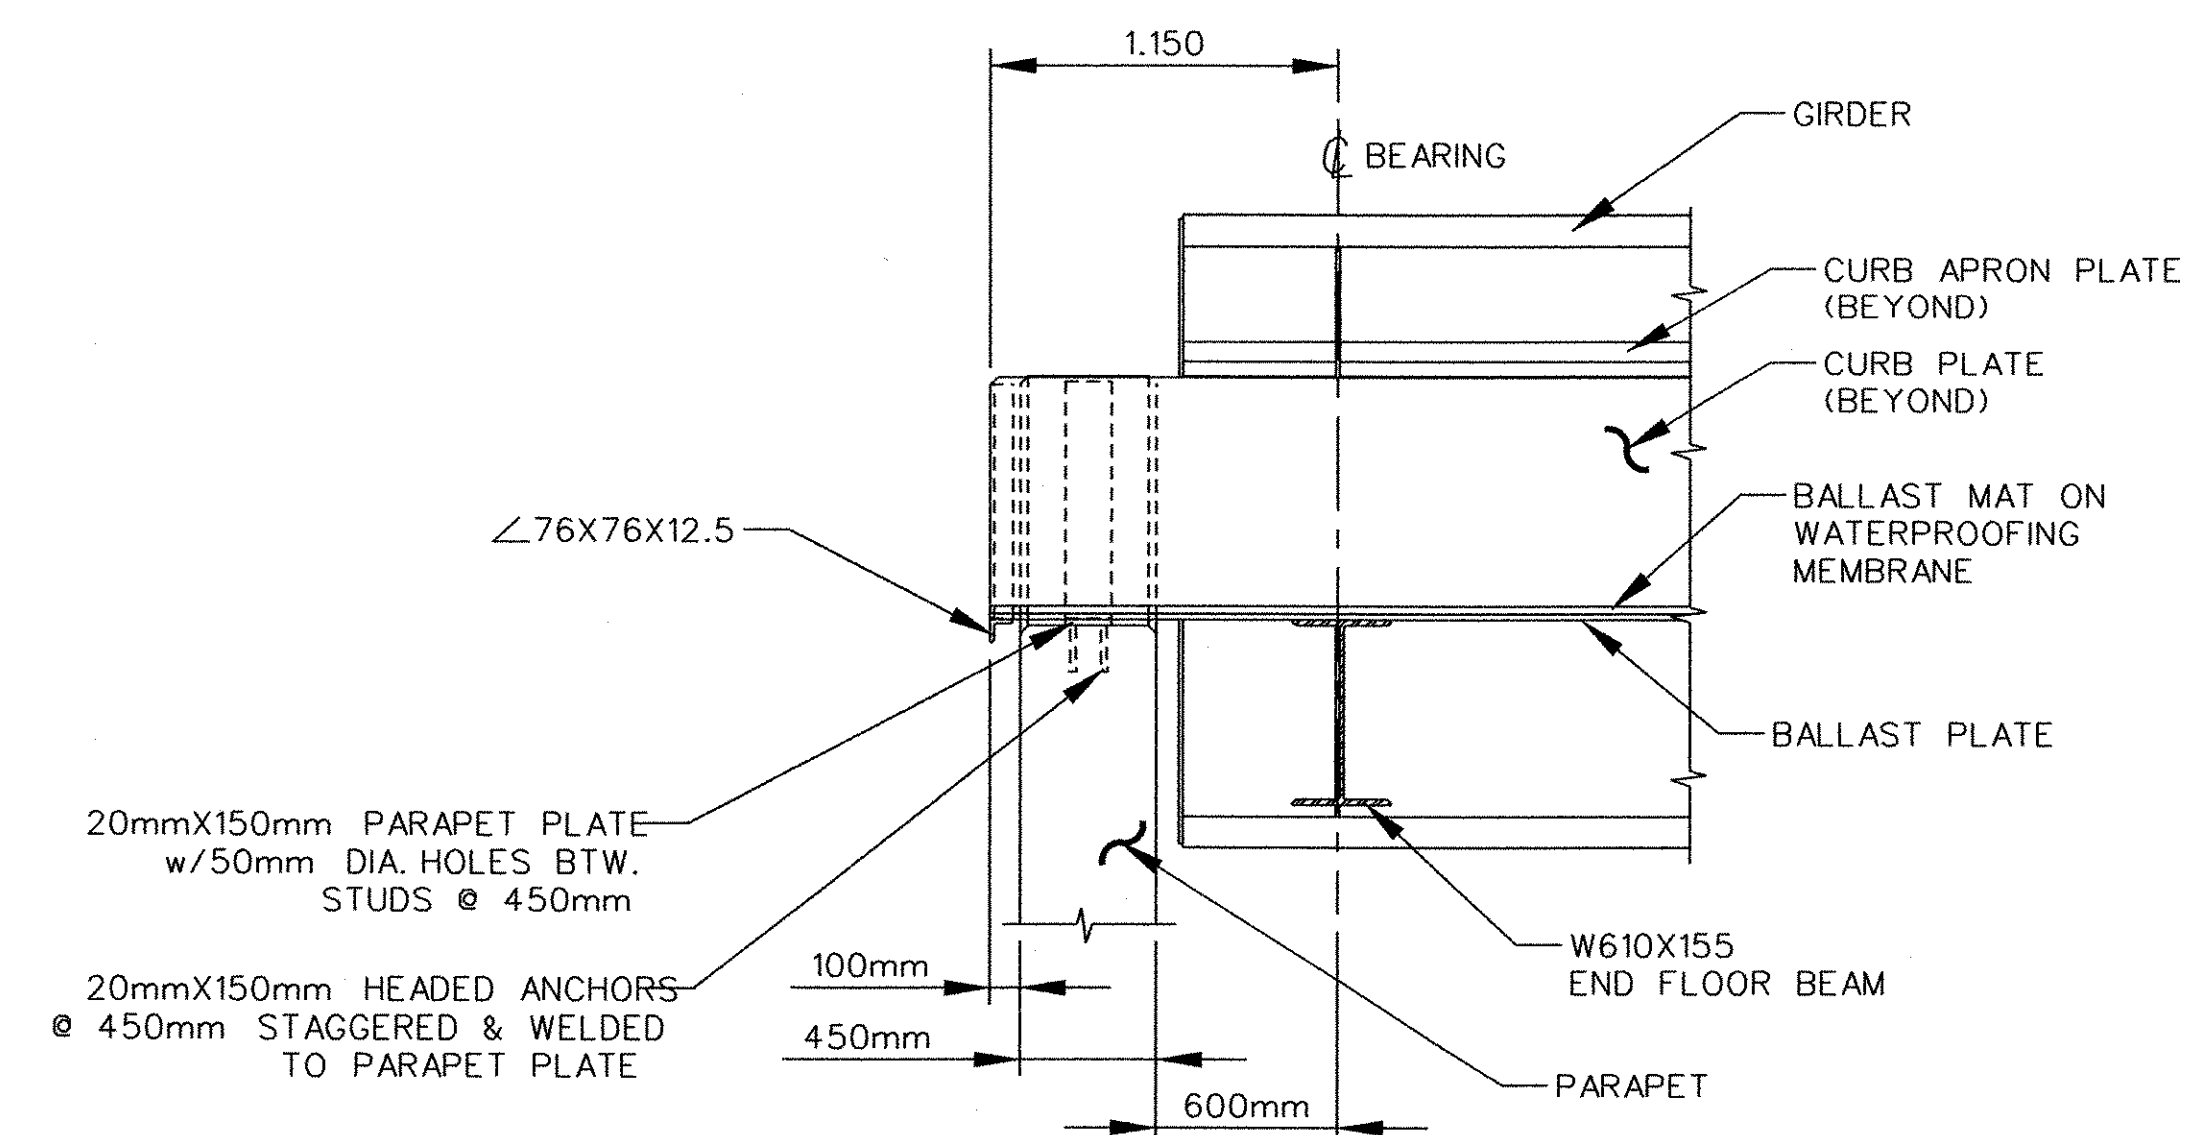

**PARAPET DETAIL**


SCALE: 1:25

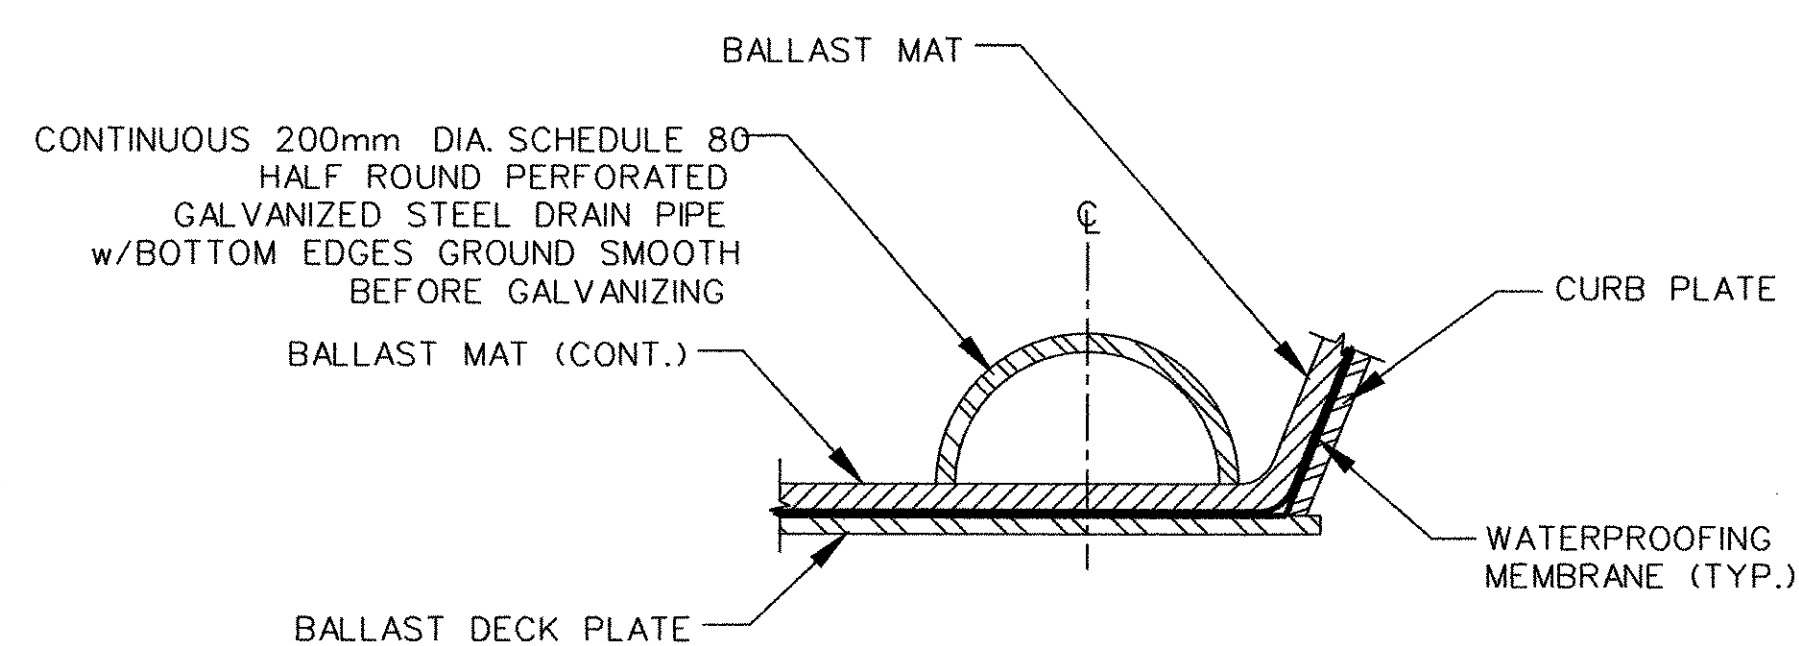

**DRAIN PIPE DETAIL**


SCALE: 1:5

SEE PARAPET DETAIL FOR EXTENSION OF PIPE.

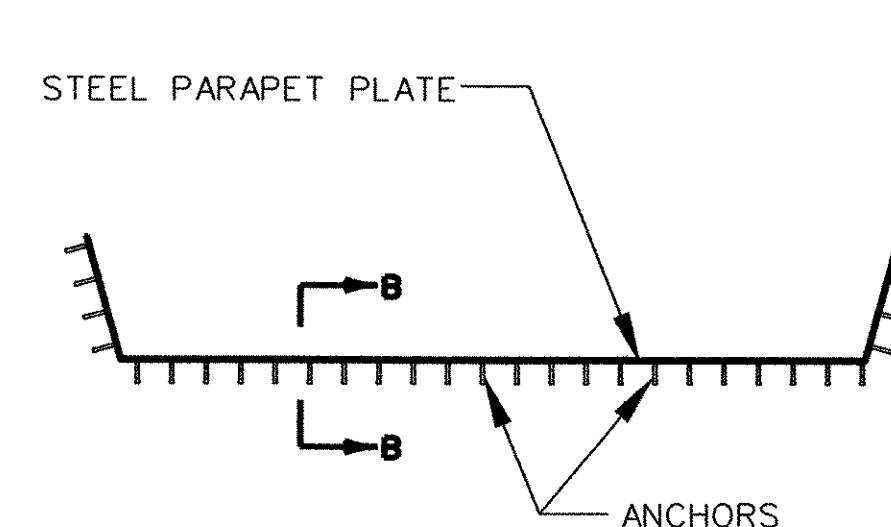


**PARAPET PLATE DETAIL**

SCALE: 1:50

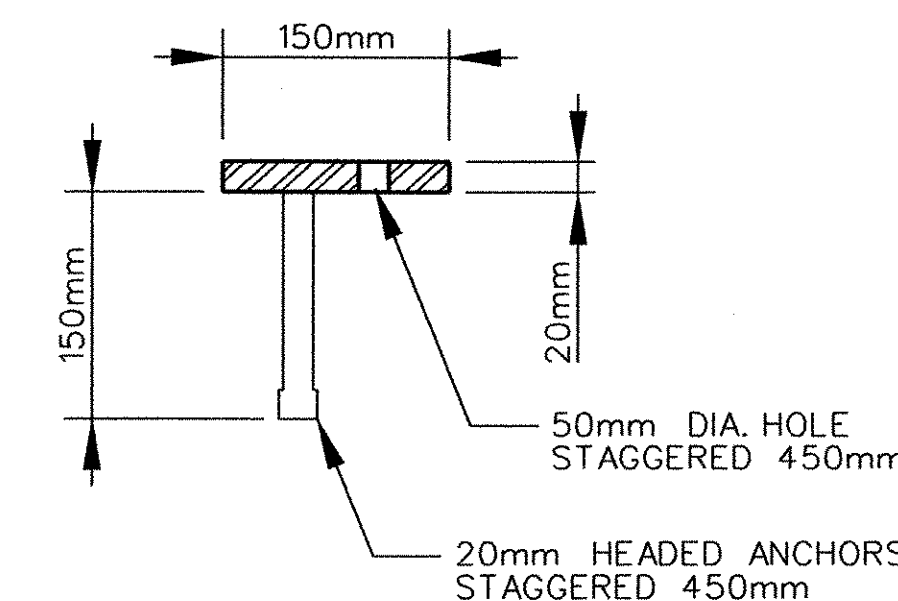


**SECTION B-B**

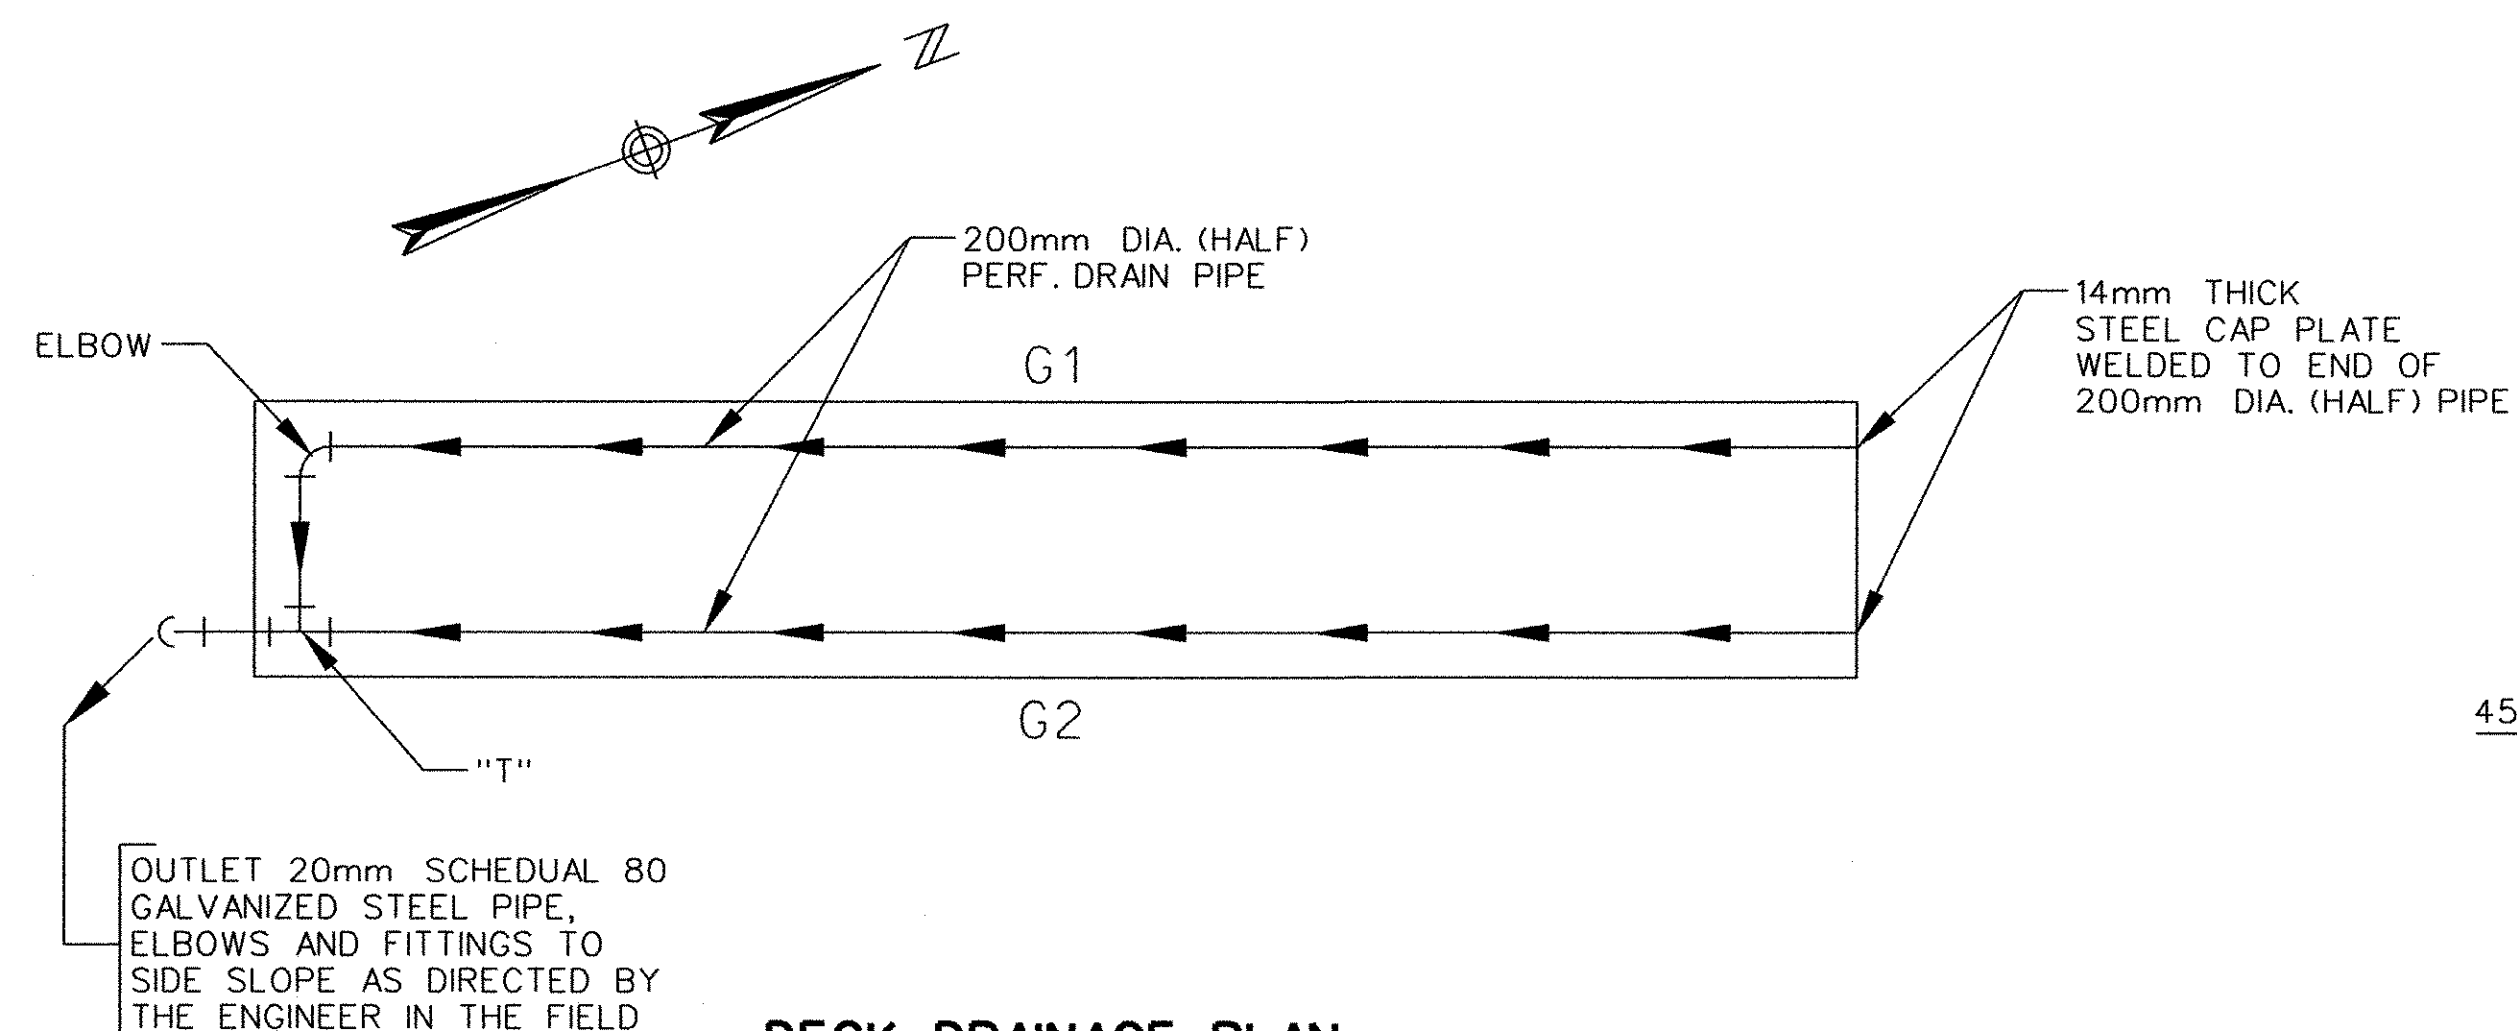

**DECK DRAINAGE PLAN**

SCALE: NTS

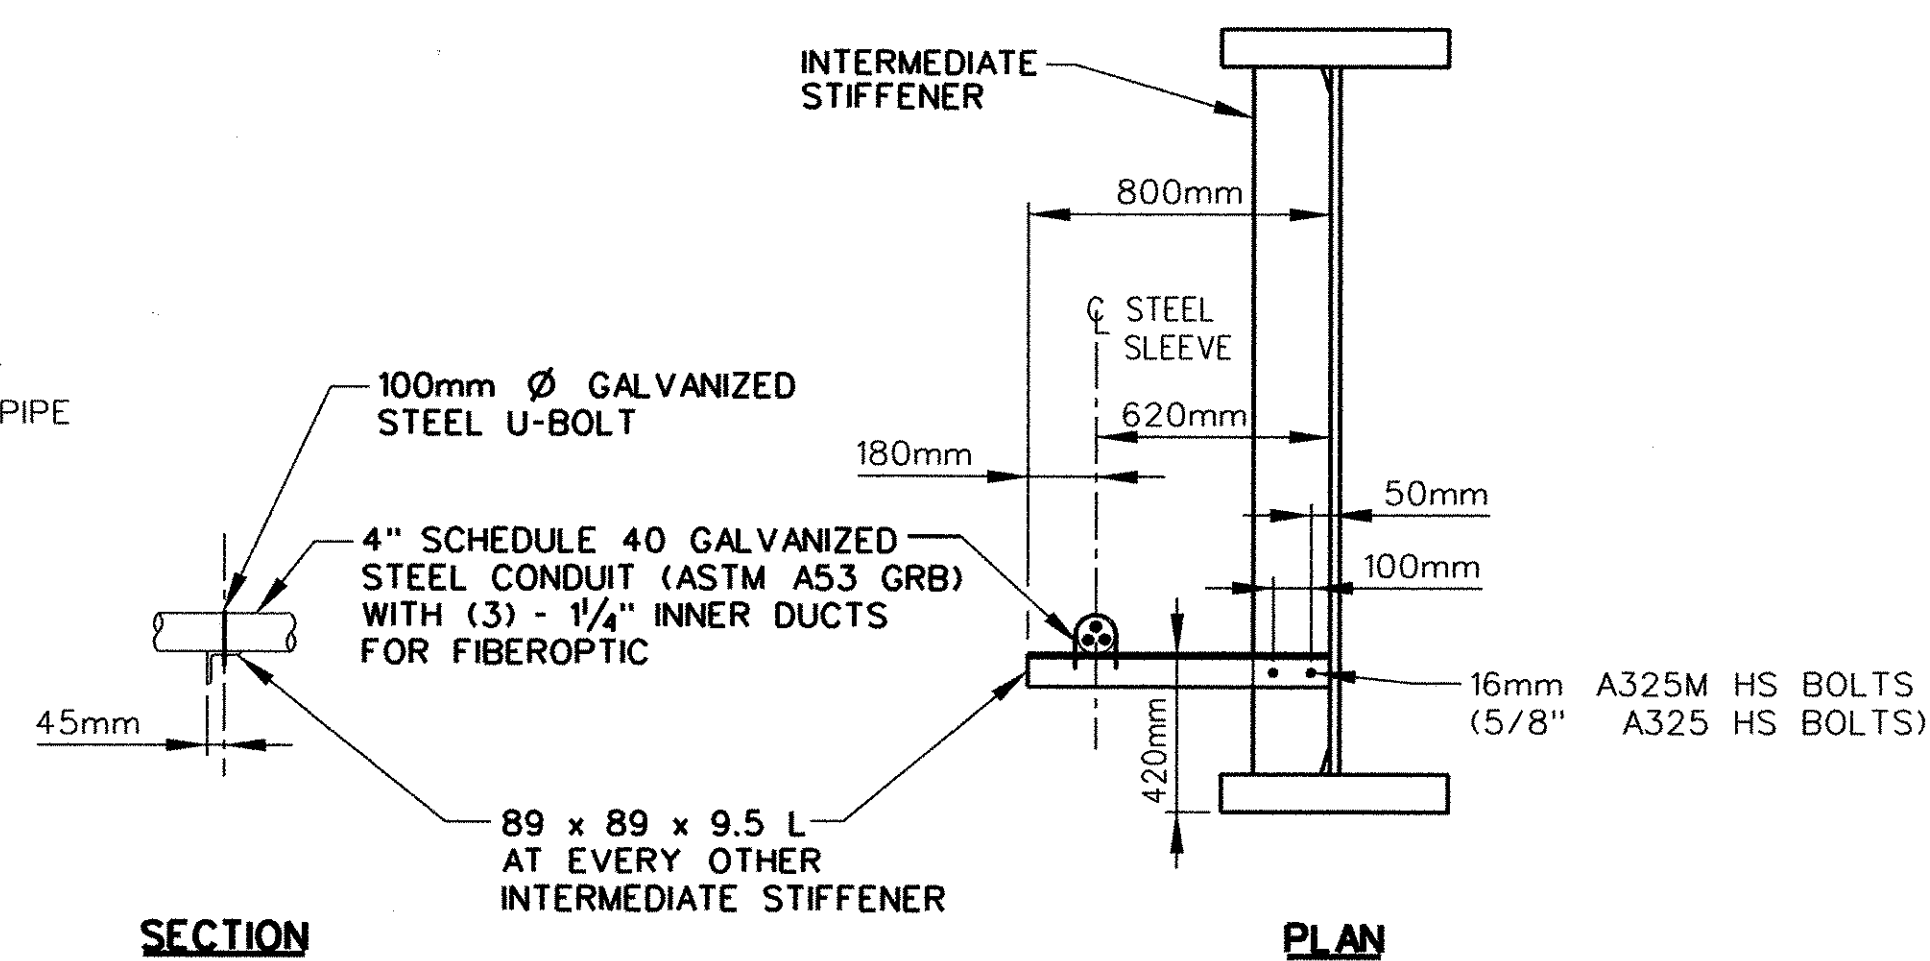

**SECTION**

**PLAN**

**FIBEROPTIC CONDUIT SUPPORT DETAIL**

SCALE: 1:20

**STATE OF VERMONT  
AGENCY OF TRANSPORTATION**

Town Of	BRATTLEBORO	Bridge No.	62.56
Highway No.	VT. ROUTE 9	Log Sta.	
		Surv. Sta.	

**ROUTE 9 BRIDGE**

**SUPERSTRUCTURE DETAILS**

Designed By		Drawn By	DHL/LB
Checked By	GJB	Bridge Design Supervisor	JHR
		Date	

PROJECT	BRATTLEBORO	PROJECT NO.	NH 010-2(2)
---------	-------------	-------------	-------------

I.G.C. Info.	
Bridge Sheet No. 5	Sheet 73 of 145

Plot Date: 10-03-2002  
File: rt9br153