


MATCH TO PLAN DRAWING NO. 5, STA. 267+00

MATCH TO PLAN DRAWING NO. 7, STA. 273+00


PLAN
1" = 20'

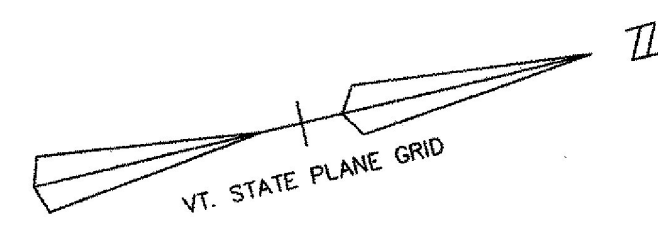

NOTE:
All new water lines shown on plans not within a hatched area are either constructed or to be done by others. Hatch water lines shall be part of A.O.T. project.

RECORD DRAWING REVISIONS

NO/DATE	DESCRIPTION
1, 11/10/09	FIELD MARK UPS ADDED TO THE PLANS

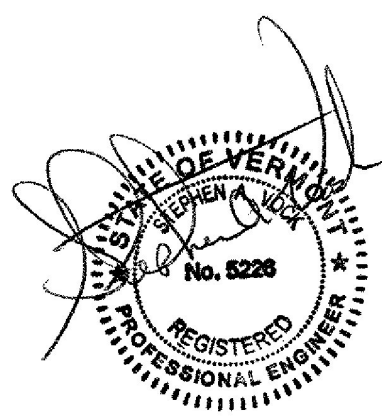

Shelburne NH EGC 019-4 (27)
Sheet 464 of 537

1-5-04 SAV/AGL REV'D WATER SYSTEM AS PER "AS BUILT" INFORMATION 10-21-03 SAV/AGL REV'D SEWER & WATER AS PER AOT REVIEW COMMENTS 8-31-00 SAV/AGL REVISED NEW WATER LINE 6-12-00 SAV/AGL REVISED NEW WATER LINE		TOWN OF SHELBURNE SEWER/WATER RELOCATION (AOT WORK) PLAN AND PROFILE STA. 267+00 TO 273+00	
Date Ch'k'd Drawn by A.C.L. Checked by SAV Approved by SAV	Revision Date JAN. 1997 Scale AS NOTED Project No. 95160		

C:\AutoCAD\Projects\1996\96111\ROUTE-7-SEWER.dwg, 01/07/2004 12:45:56 PM