



MATCH TO PLAN DRAWING NO. 6, STA. 273+00

MATCH TO PLAN DRAWING NO. 8, STA. 279+00

PLAN
1" = 20'

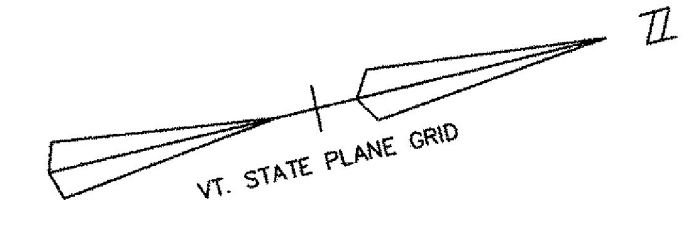

Shelburne NH EGC 019-4 (27)
Sheet 465 of 537

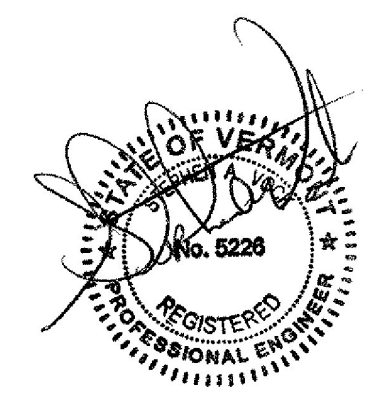

10-21-03	SAV/ACL	REV'D SEWER & WATER AS PER AOT REVIEW COMMENTS
8-31-02	SAV/ACL	REVISED NEW WATER LINE
6-12-00	SAV/ACL	REVISED NEW WATER LINE
Date	Ch'k'd	Revision
Drawn by	ACL	Date JAN. 1997
Checked by	SAV	Scale AS NOTED
Approved by	SAV	Project No. 95160

TOWN OF SHELBURNE
SEWER/WATER RELOCATION (AOT WORK)
PLAN AND PROFILE
STA. 273+00 TO 279+00

VERMONT
CIVIL ENGINEERING ASSOCIATES, INC.
SHELBURNE, VERMONT

C-7

P:\AutoCAD Projects\1996\0611\ROUTE-7-SEWER.dwg, 10/21/2003 03:07:40 PM