
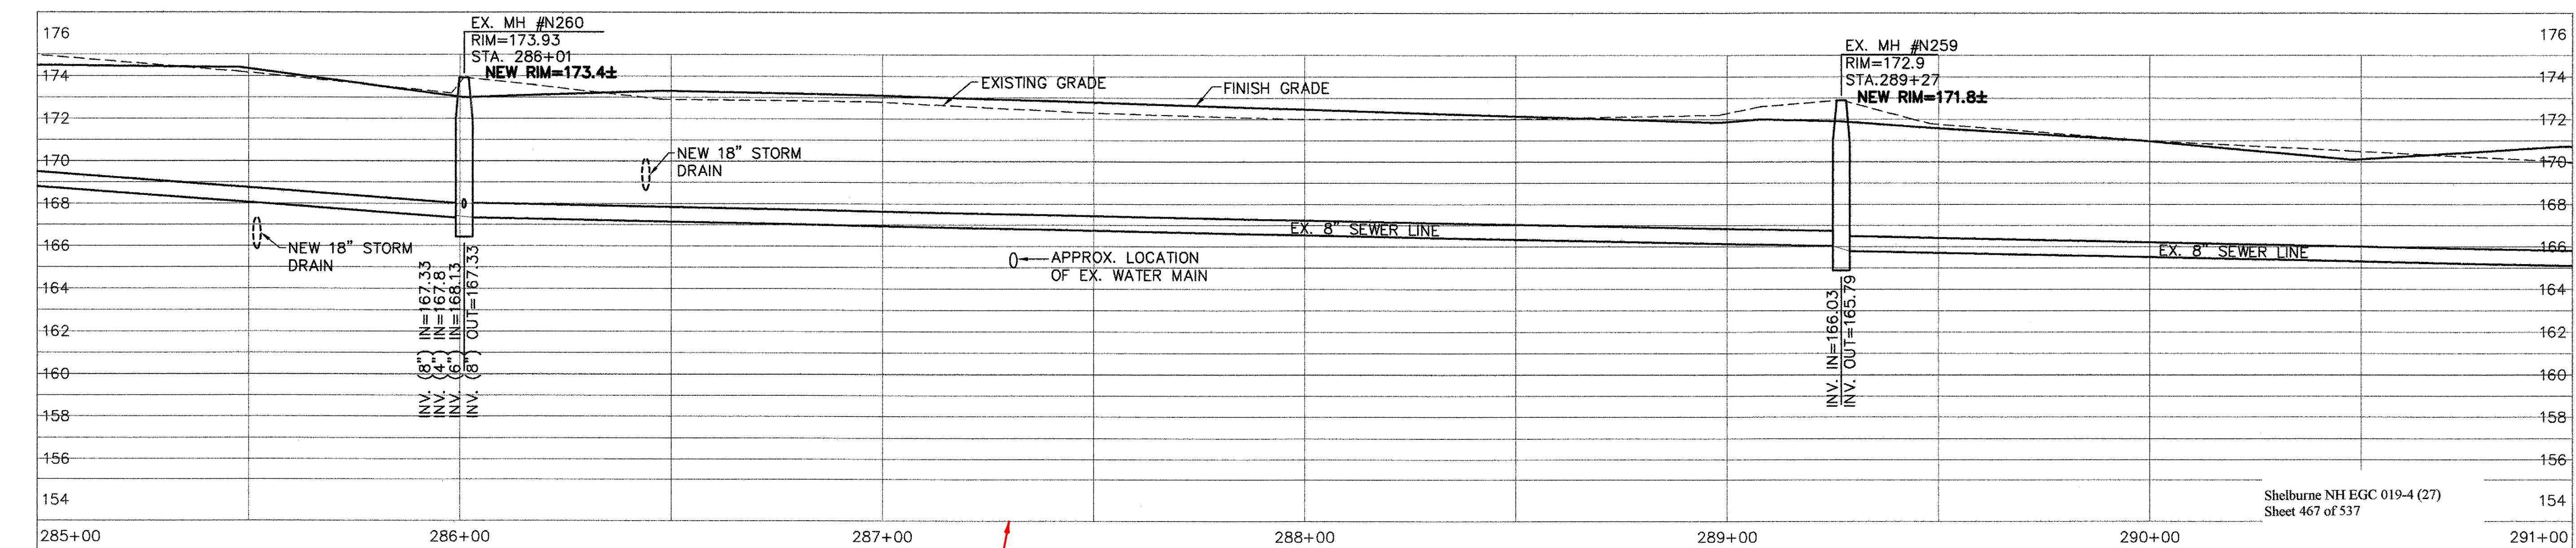


**PLAN**  
1" = 20'

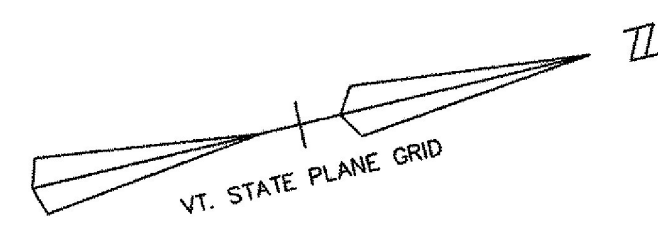

**DEPTH OF 16" SLEEVE CONSTRUCTED AT STATION 287+41 UNKNOWN. SEE PLAN FOR LOCATION OF SLEEVE.**

**PROFILE**  
1" = 4' VERTICAL  
1" = 20' HORIZONTAL

**RECORD DRAWING REVISIONS**

NO/DATE	DESCRIPTION
1.11/10/09	FIELD MARK UPS ADDED TO THE PLANS



Date	Ch'kd	Revision
1-5-04	SAV/ACL	REV'D WATER SYSTEM AS PER "AS BUILT" INFORMATION
10-21-03	SAV/ACL	REV'D SEWER & WATER AS PER AOT REVIEW COMMENTS
8-29-03	SAV/ACL	MOVED DRAINAGE LINE ON PROFILE
7-21-03	SAV/ACL	REVISED

**TOWN OF SHELBURNE**  
**SEWER/WATER RELOCATION (AOT WORK)**  
**PLAN AND PROFILE**  
**STA. 285+00 TO 291+00**

Shelburne NH EGC 019-4 (27)  
Sheet 467 of 537

Drawn by	ACL	Date	DEC., 2000
Checked by	SAV	Scale	AS NOTED
Approved by	SAV	Project No.	96111

CIVIL ENGINEERING ASSOCIATES, INC.  
SHELBURNE, VERMONT

**C-9**