
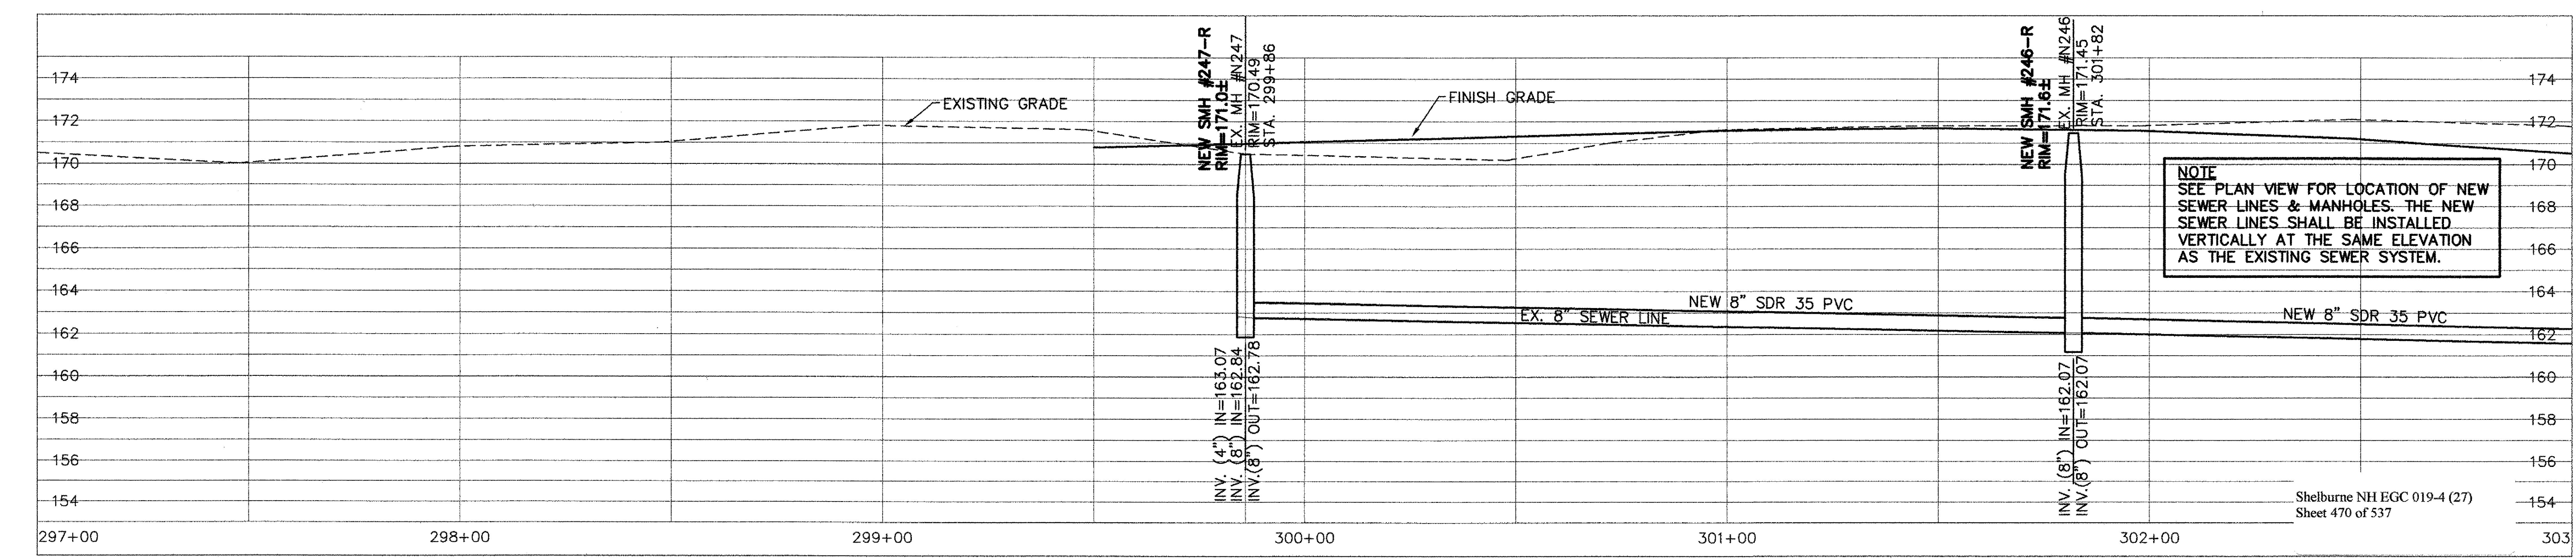


**PLAN**  
1" = 20'

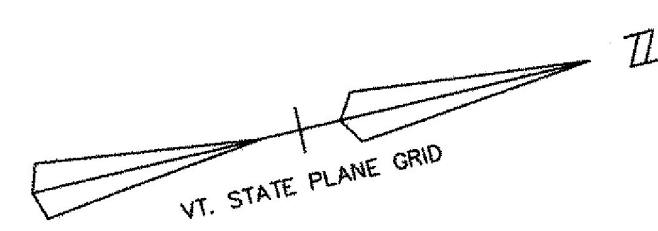

**PROFILE**  
1" = 4' VERTICAL  
1" = 20' HORIZONTAL

**NOTE**  
SEE PLAN VIEW FOR LOCATION OF NEW SEWER LINES & MANHOLES. THE NEW SEWER LINES SHALL BE INSTALLED VERTICALLY AT THE SAME ELEVATION AS THE EXISTING SEWER SYSTEM.

**RECORD DRAWING REVISIONS**

NO.	DATE	DESCRIPTION
1.	11/10/09	FIELD MARK UPS ADDED TO THE PLANS



Date	Ch'k'd	Revision
1-5-04	SAV/AQL	REV'D WATER SYSTEM AS PER "AS BUILT" INFORMATION
10-21-03	SAV/AQL	REV'D SEWER & WATER AS PER AOT REVIEW COMMENTS
9-3-03	SAV/AQL	REVISED RIM ELEV. TO ±
7-21-03	SAV/AQL	REVISED

**TOWN OF SHELburnE**  
**SEWER/WATER RELOCATION (AOT WORK)**  
**PLAN AND PROFILE**  
**STA. 297+00 TO 303+00**

Drawn by: SAV/AQL Date: DEC., 2000  
 Checked by: SAV Scale: AS NOTED  
 Approved by: SAV Project No.: 96111

SHELburnE CIVIL ENGINEERING ASSOCIATES, INC. SHELburnE, VERMONT

SHEET C-11E

P:\AutoCAD\Projects\1998\0811\ROUTE-7-SEWER.dwg, 01/07/2004, 12:46:04 PM