
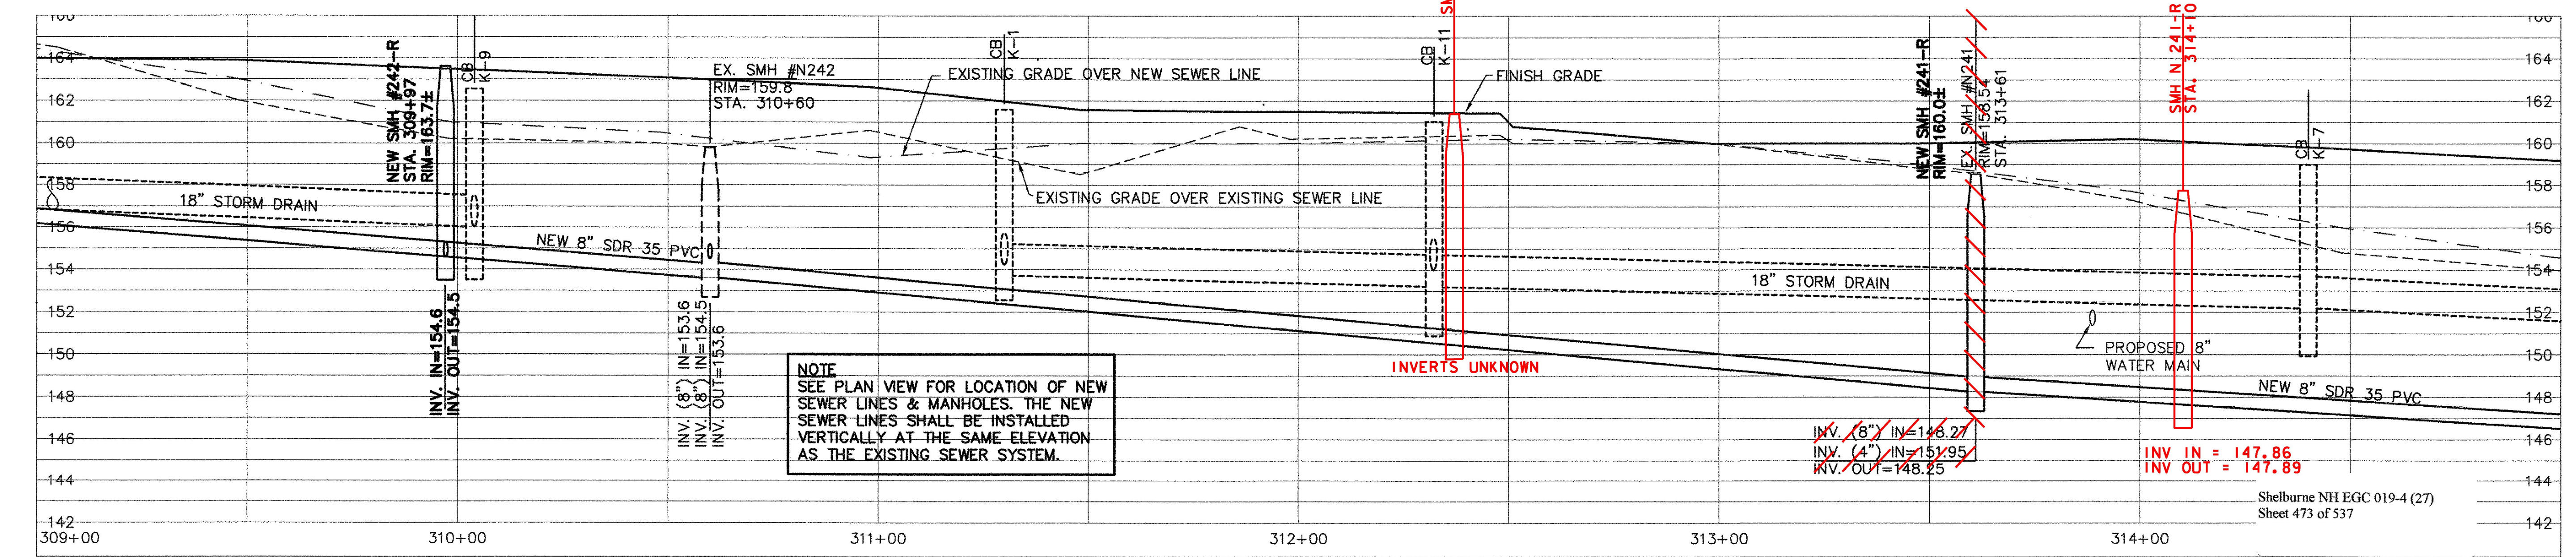



PLAN
1" = 20'

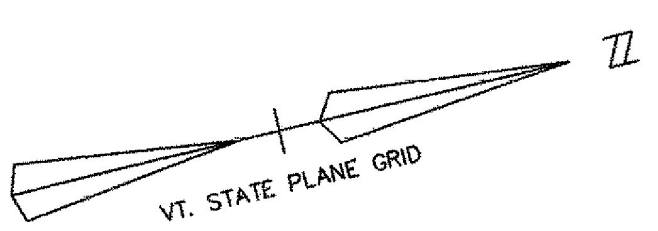

PROFILE
1" = 4' VERTICAL
1" = 20' HORIZONTAL

RECORD DRAWING REVISIONS

NO.	DATE	DESCRIPTION
1.	11/10/09	FIELD MARK UPS ADDED TO THE PLANS

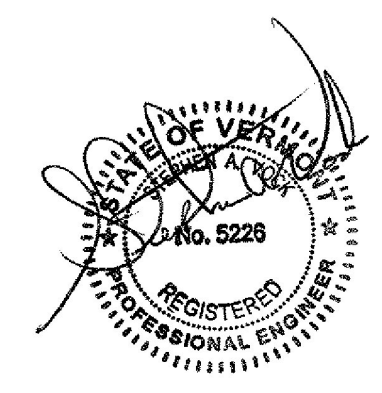

Date	Ch'kd	Revision
10-21-03	SAV/ACL	REV'D SEWER & WATER AS PER AOT REVIEW COMMENTS
9-3-03	SAV/ACL	REVISED PER REVIEW COMMENTS
7-21-03	SAV/ACL	REVISED

TOWN OF SHELBURNE
SEWER/WATER RELOCATION (AOT WORK)
PLAN AND PROFILE
STA. 309+00 TO 315+00

Shelburne NH EGC 019-4 (27)
Sheet 473 of 537

Drawn by ACL Date DEC., 2000
Checked by SAV Scale AS NOTED
Approved by SAV Project No. 96111

CIVIL ENGINEERING ASSOCIATES, INC.
SHELBURNE, VERMONT

SHEET **C-13**

P:\AutoCAD Projects\1998\6111\ROUTE-7-SEWER.dwg, 10/23/2005 02:48:12 PM