

BARRIER FENCE FOR TREE PROTECTION

PNR 71+57.8 LT - PNR 71+84.1 LT - 32.3
PNR 72+09.6 LT - PNR 72+40.7 LT - 37.6
PNR 73+28.6 LT - PNR 73+54.8 LT - 32.3
PNR 73+63.1 LT - PNR 74+26.4 LT - 69.4
PNR 74+33.9 LT - PNR 74+49.5 LT - 21.6

SPECIAL PROVISION


(STAMPED COLORED CONCRETE TRAFFIC CIRCLE, 8 INCH)

PNR 72+56.4 LT/RT - PNR 72+96.4 LT/RT (139.6 SY)

SPECIAL PROVISION

(STAMPED COLORED CONCRETE MEDIAN ISLAND, 5 INCH)

PNR 73+06.7 RT - PNR 75+59.4 RT (167.3 SY)
PNR 73+81.7 RT - PNR 75+09.8 RT (83.6 SY)

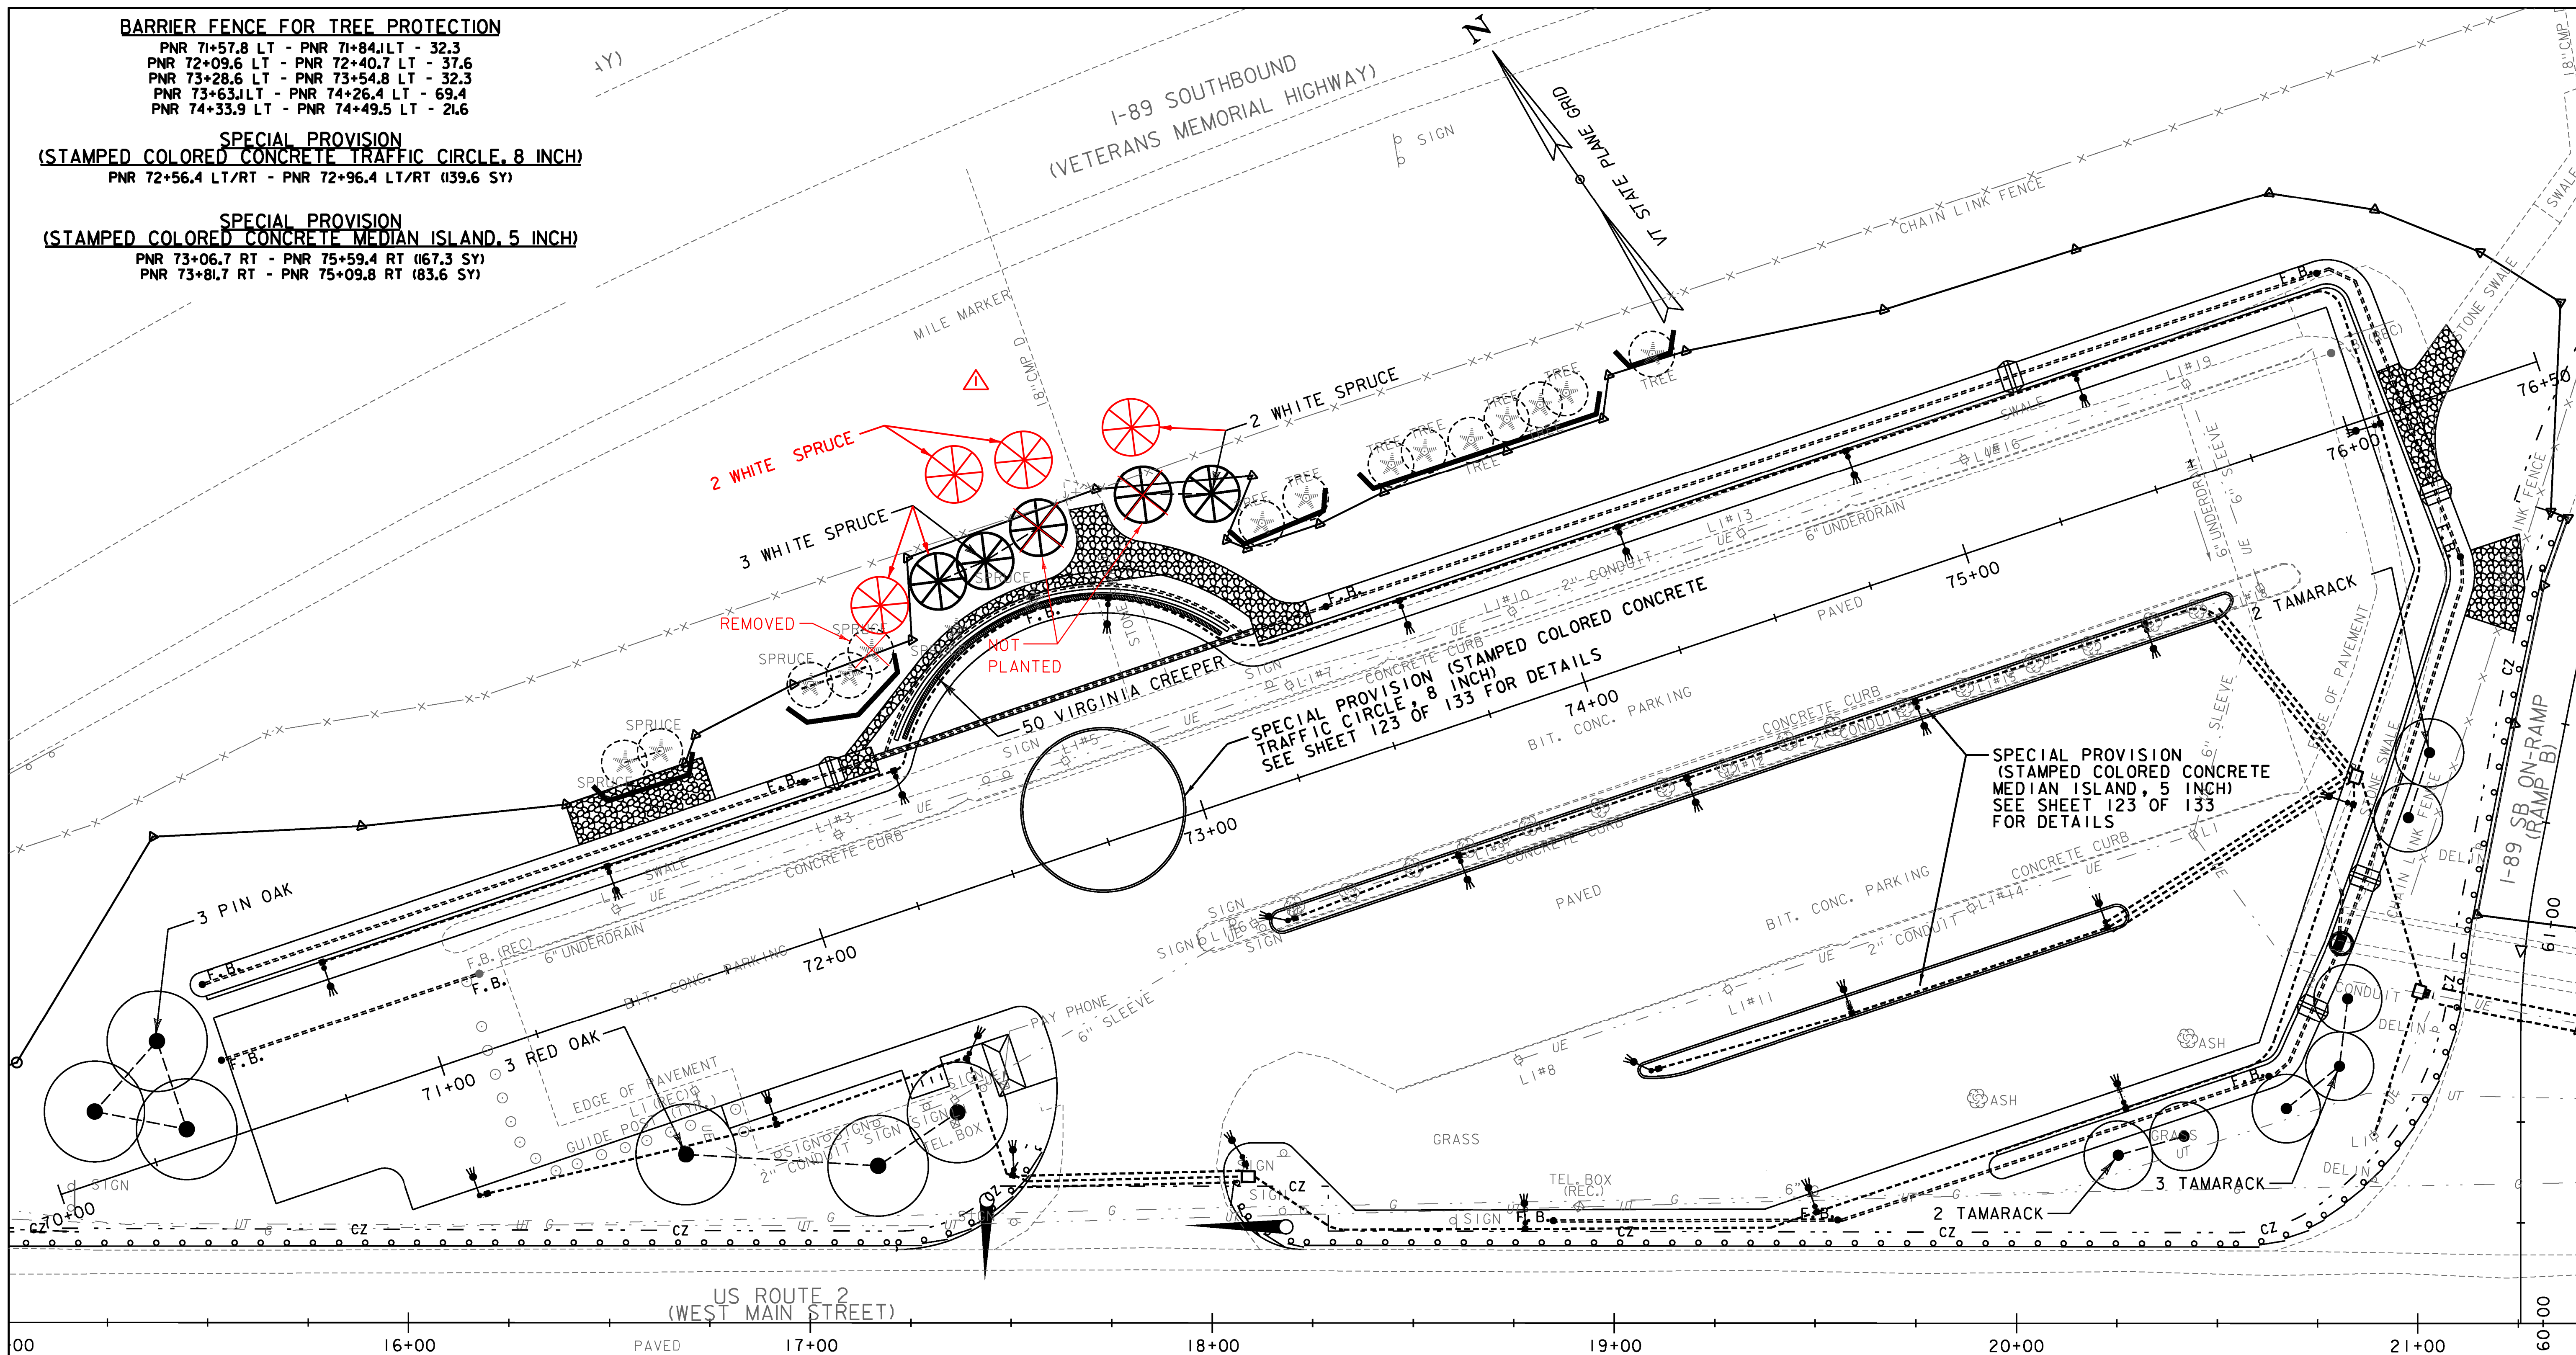

NOTES:

1. THE CONTRACTOR SHALL NOT EXCAVATE OR USE HEAVY CONSTRUCTION EQUIPMENT WITHIN THE DRIP LINE OF EXISTING TREES TO REMAIN. THE CONTRACTOR SHALL NOT ROUND THE SLOPES FROM STA 71+50 TO 74+50, OR AS DIRECTED BY THE ENGINEER.
2. SEE LANDSCAPE DETAILS FOR PLANT LIST.
3. SEE SHEET 113-115 FOR LIGHTING PLAN AND DETAILS.

0 20 40
SCALE IN FEET

KEY	DATE	BY	REVISION
△	11/16/2015	VTRANS	PLANTING UPDATE

PROJECT NAME: RICHMOND
PROJECT NUMBER: CMG PARK (31)

FILE NAME: z97c186landbdr.dgn
PROJECT LEADER: ERIK ATKINS
DESIGNED BY: J. RIEMENSCHNEIDER
LANDSCAPE PLAN

PLOT DATE: 4/30/2013
DRAWN BY: N. BOSAN
CHECKED BY: E. ATKINS
SHEET 109 OF 133