



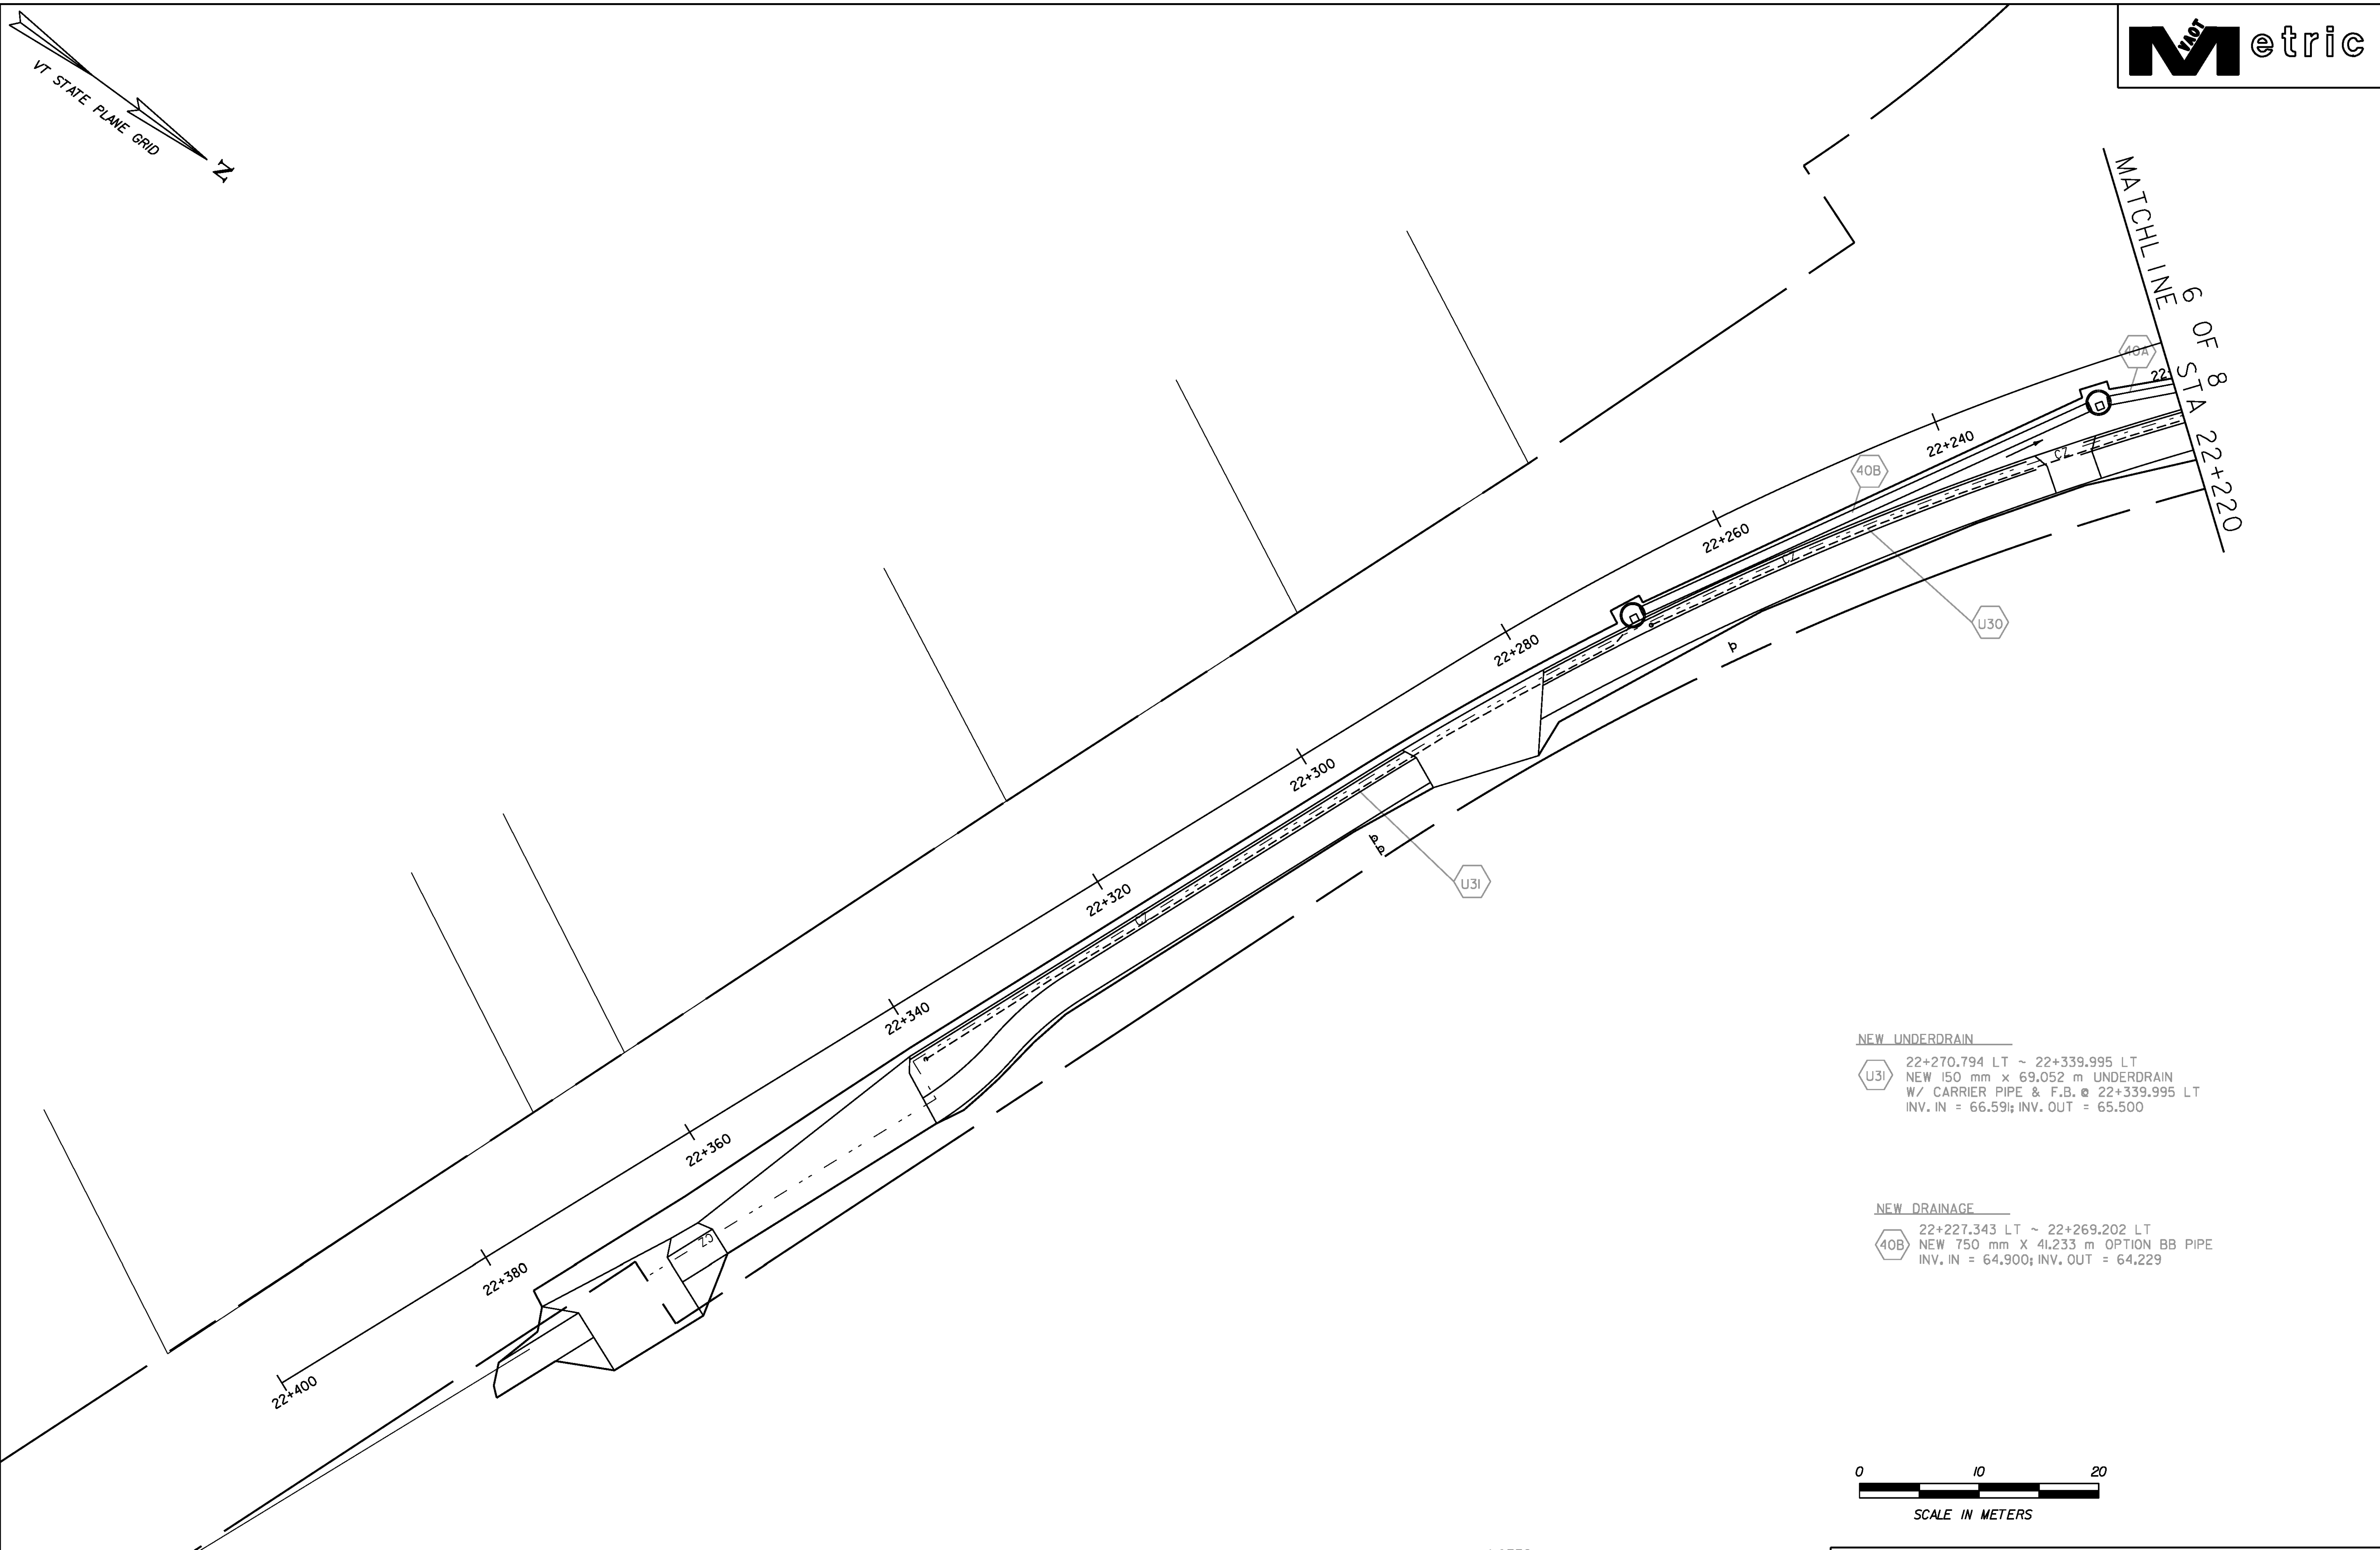

NEW UNDERDRAIN
U31 22+270.794 LT ~ 22+339.995 LT
NEW 150 mm x 69.052 m UNDERDRAIN
W/ CARRIER PIPE & F.B. @ 22+339.995 LT
INV. IN = 66.591; INV. OUT = 65.500

NEW DRAINAGE
40B 22+227.343 LT ~ 22+269.202 LT
NEW 750 mm X 41.233 m OPTION BB PIPE
INV. IN = 64.900; INV. OUT = 64.229

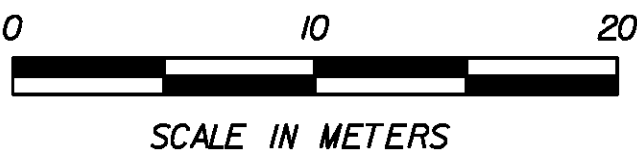

- NOTES
- 1) SEE CONSTRUCTION PLANS FOR ADDITIONAL PROPOSED FACILITIES.
 - 2) SEE UTILITY PLANS FOR LOCATIONS OF PROPOSED UTILITY RELOCATIONS.

DATUM	
VERTICAL	NAVD 88
HORIZONTAL	NAD 83/96

PROJECT NAME:	Colchester
PROJECT NUMBER:	STP 5600(9)S
FILE NAME:	r97d206DRN7.dgn
PROJECT LEADER:	D Bryant
DESIGNED BY:	D Bryant
DRAINAGE PLAN SHEET	7 OF 8
PLOT DATE:	21-FEB-2013
DRAWN BY:	T Kelley
CHECKED BY:	D Burhans
SHEET	39 OF 74