
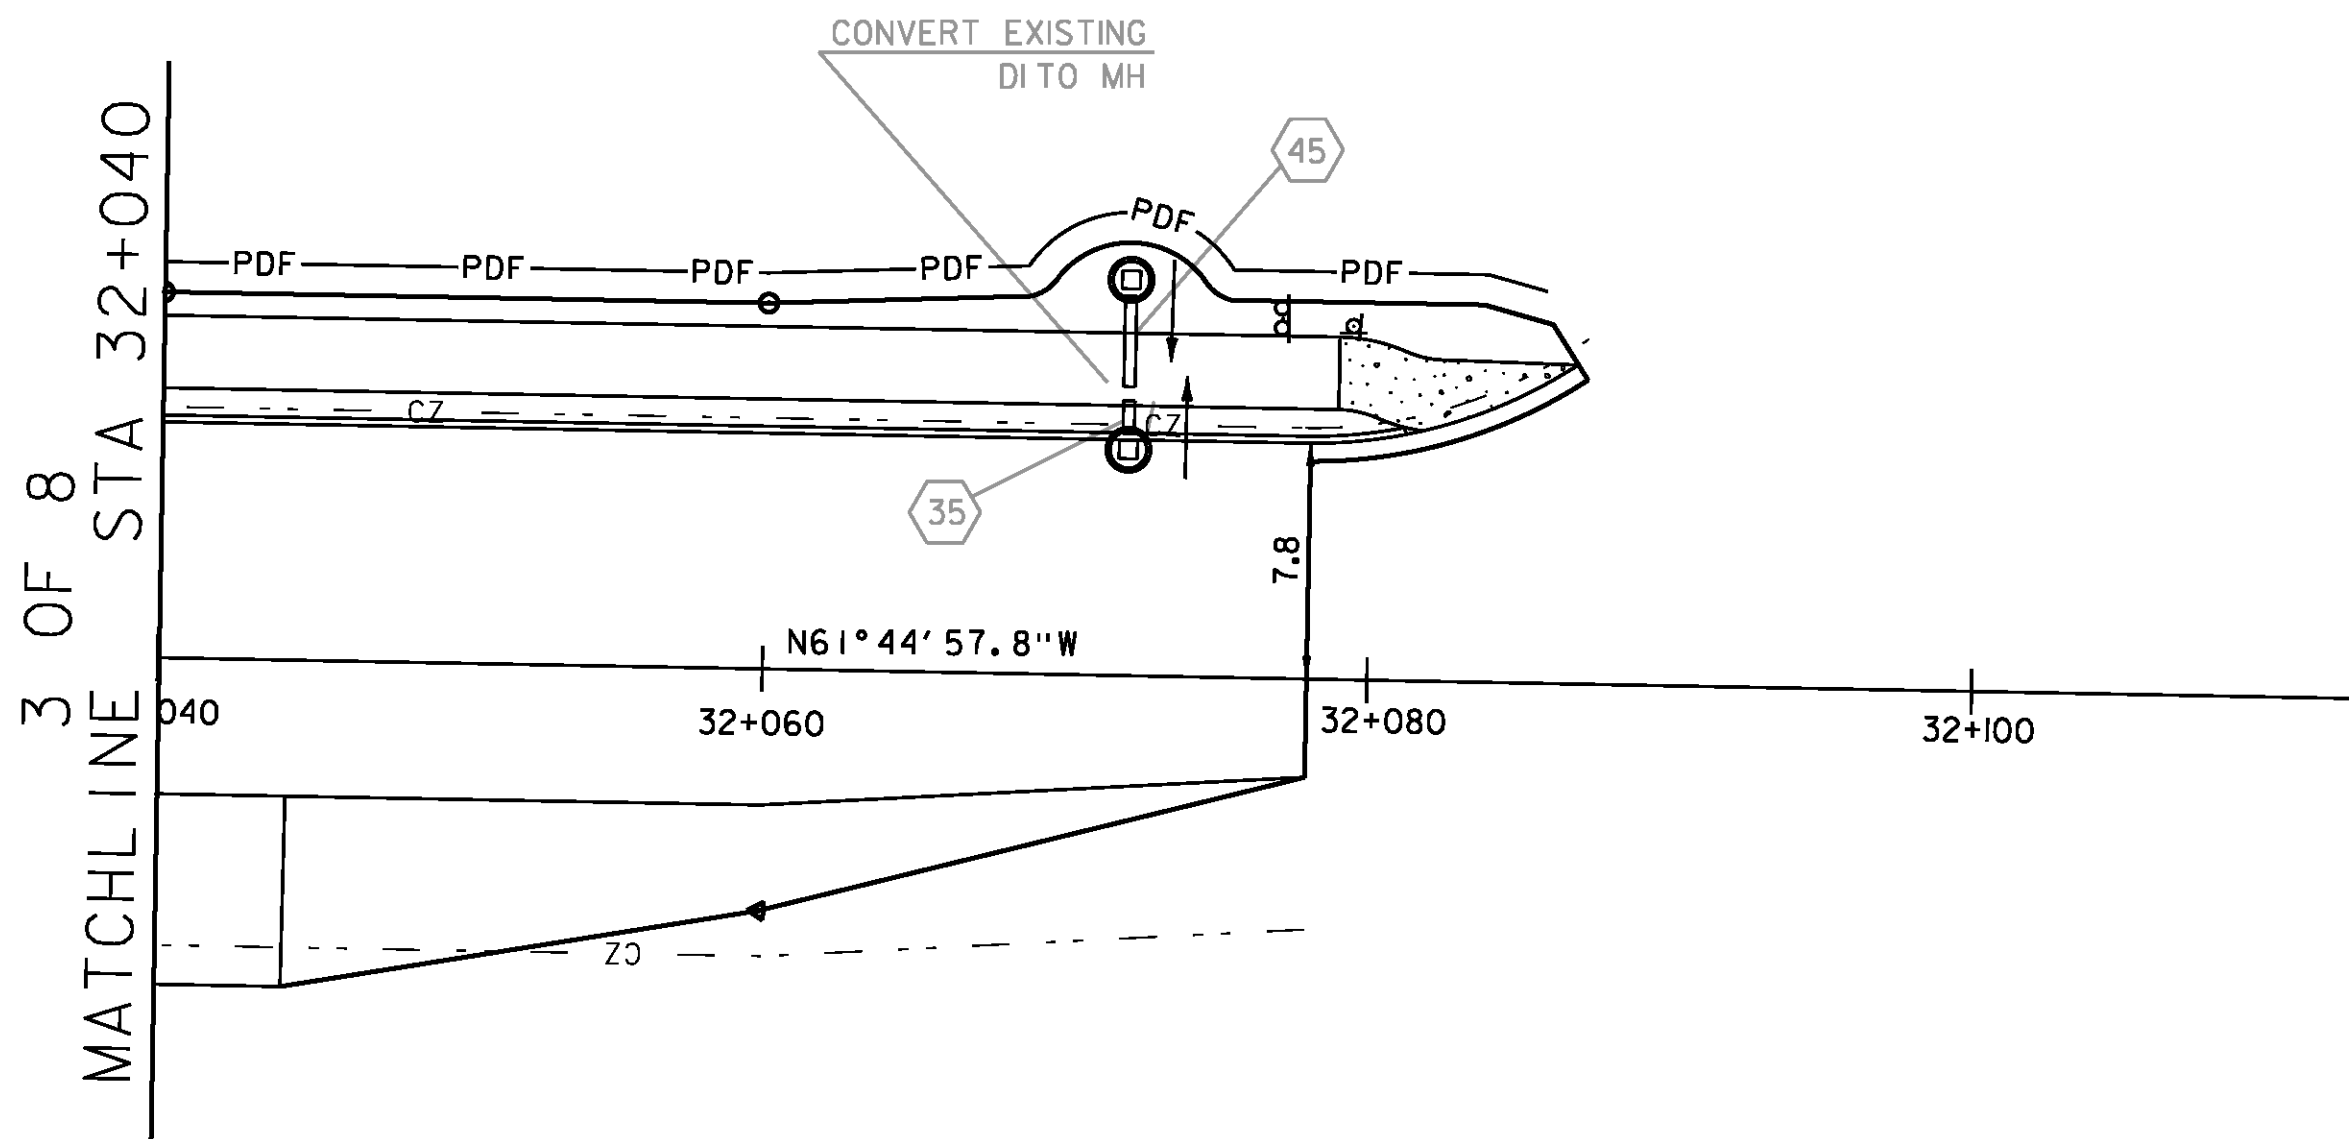


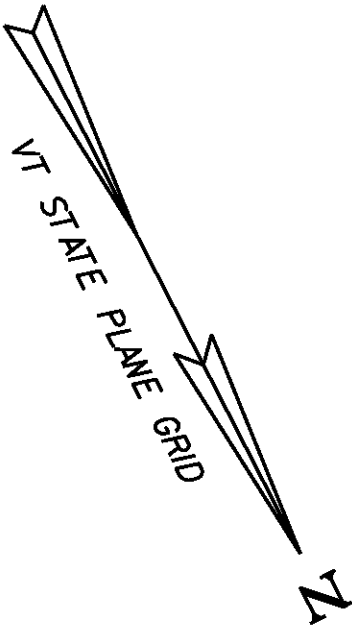


REHABING DICB OR MH CLASS II
32+071.973 LT (CONVERT DITO MH)

NEW DRAINAGE

35 32+071.973 LT ~ 32+071.973 LT
NEW 450 mm x 1.089 m OPTION AA PIPE
MATCH EXISTING INVERTS

45 32+071.973 LT ~ 32+071.973 LT
NEW 450 mm x 3.112 m OPTION AA PIPE
MATCH EXISTING INVERTS

- NOTES
- 1) SEE CONSTRUCTION PLANS FOR ADDITIONAL PROPOSED FACILITIES.
 - 2) SEE UTILITY PLANS FOR LOCATIONS OF PROPOSED UTILITY RELOCATIONS.

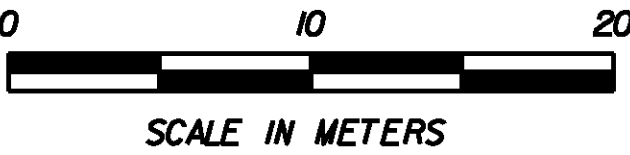

DATUM

VERTICAL NAVD 88

HORIZONTAL NAD 83/96

PROJECT NAME: Colchester

PROJECT NUMBER: STP 5600(9)S

FILE NAME: r97d206DRN8.dgn

PROJECT LEADER: D Bryant

DESIGNED BY: D Bryant

DRAINAGE PLAN SHEET 8 OF 8

PLOT DATE: 21-FEB-2013

DRAWN BY: T Kelley

CHECKED BY: D Burhans

SHEET 40 OF 74