




NOTES

- 1) SEE DRAINAGE PLANS FOR LOCATION OF PROPOSED DRAINAGE FACILITIES.
- 2) SEE CONSTRUCTION PLANS FOR ADDITIONAL PROPOSED FACILITIES.

NEW WATER MAIN

W2 2+660.000 LT ~ 2+830.000 LT
NEW 300 mm PIPE

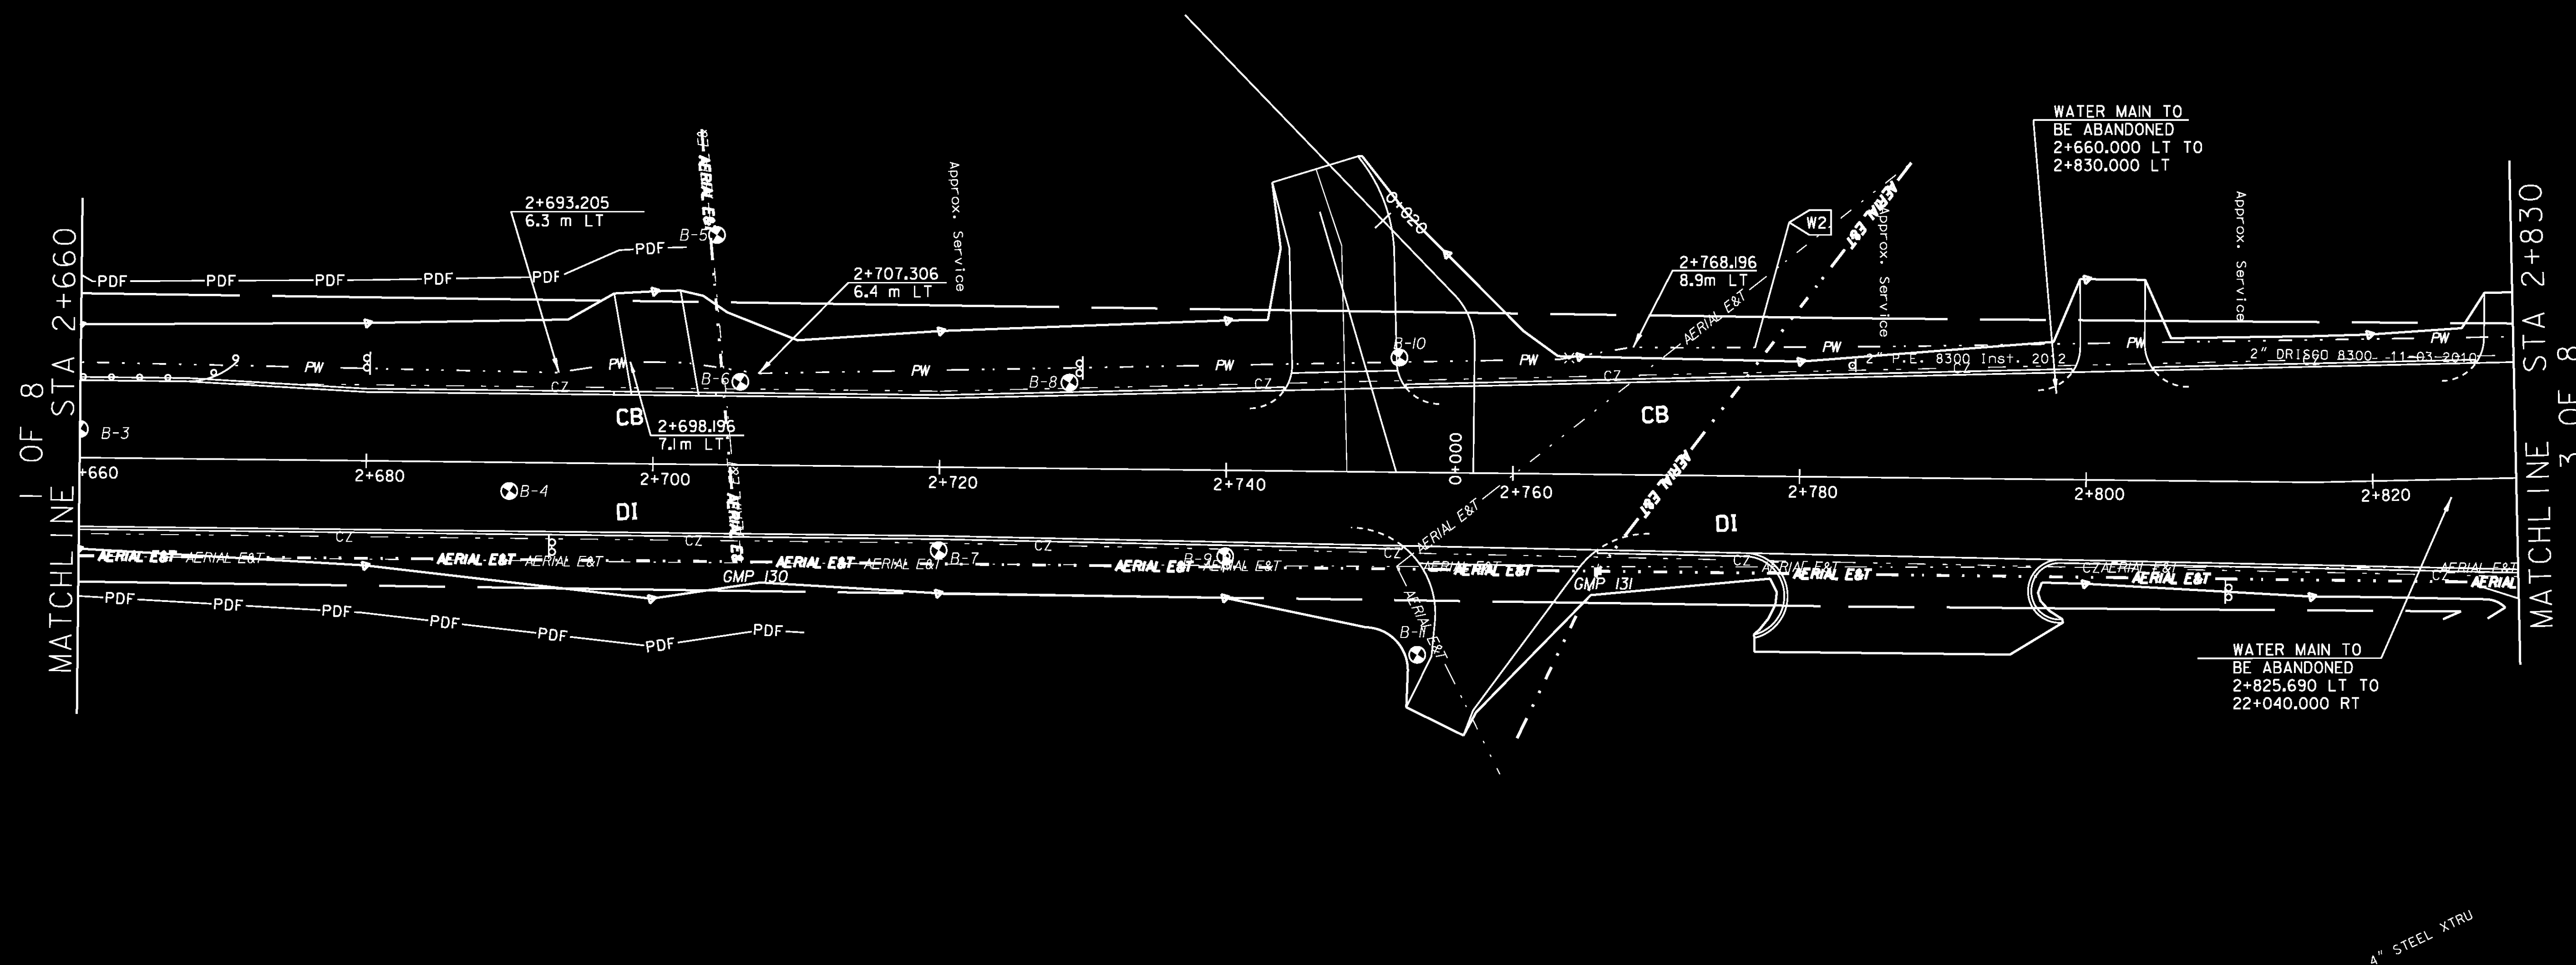

PROJECT NAME: COLCHESTER
PROJECT NUMBER: STP 5600(9)S

FILE NAME: r97d206UTL2.dgn
PROJECT LEADER: J. SCHULTZ
DESIGNED BY: D. BRYANT
UTILITY PLAN SHEET 2 OF 8

PLOT DATE: 21-FEB-2013
DRAWN BY: T. KELLEY
CHECKED BY: D. BURHANS
SHEET 42 OF 74