


NEW WATER MAIN

- W3 2+830.000 LT ~ 2+985.894 RT
NEW 300 mm PIPE
- W4 2+984.400 RT ~ 2+982.750 RT
NEW 300 mm PIPE
- W5 32+01.436 LT ~ 32+015.330 LT
NEW 300 mm PIPE
- W6 2+841.199 LT ~ 22+040.000 RT
NEW 300 mm PIPE
- W7 22+032.996 RT ~ 22+033.026 RT
NEW HYDRANT ASSEMBLY

NEW GAS MAIN (BY OTHERS)

- G3 2+997.968 RT ~ 22+040.000 LT
NEW 100 mm XTRU
- G4 2+994.686 RT ~ 2+995.285 LT
NEW 100 mm XTRU
- G5 2+995.285 LT ~ 32+036.819 RT
NEW 100 mm XTRU

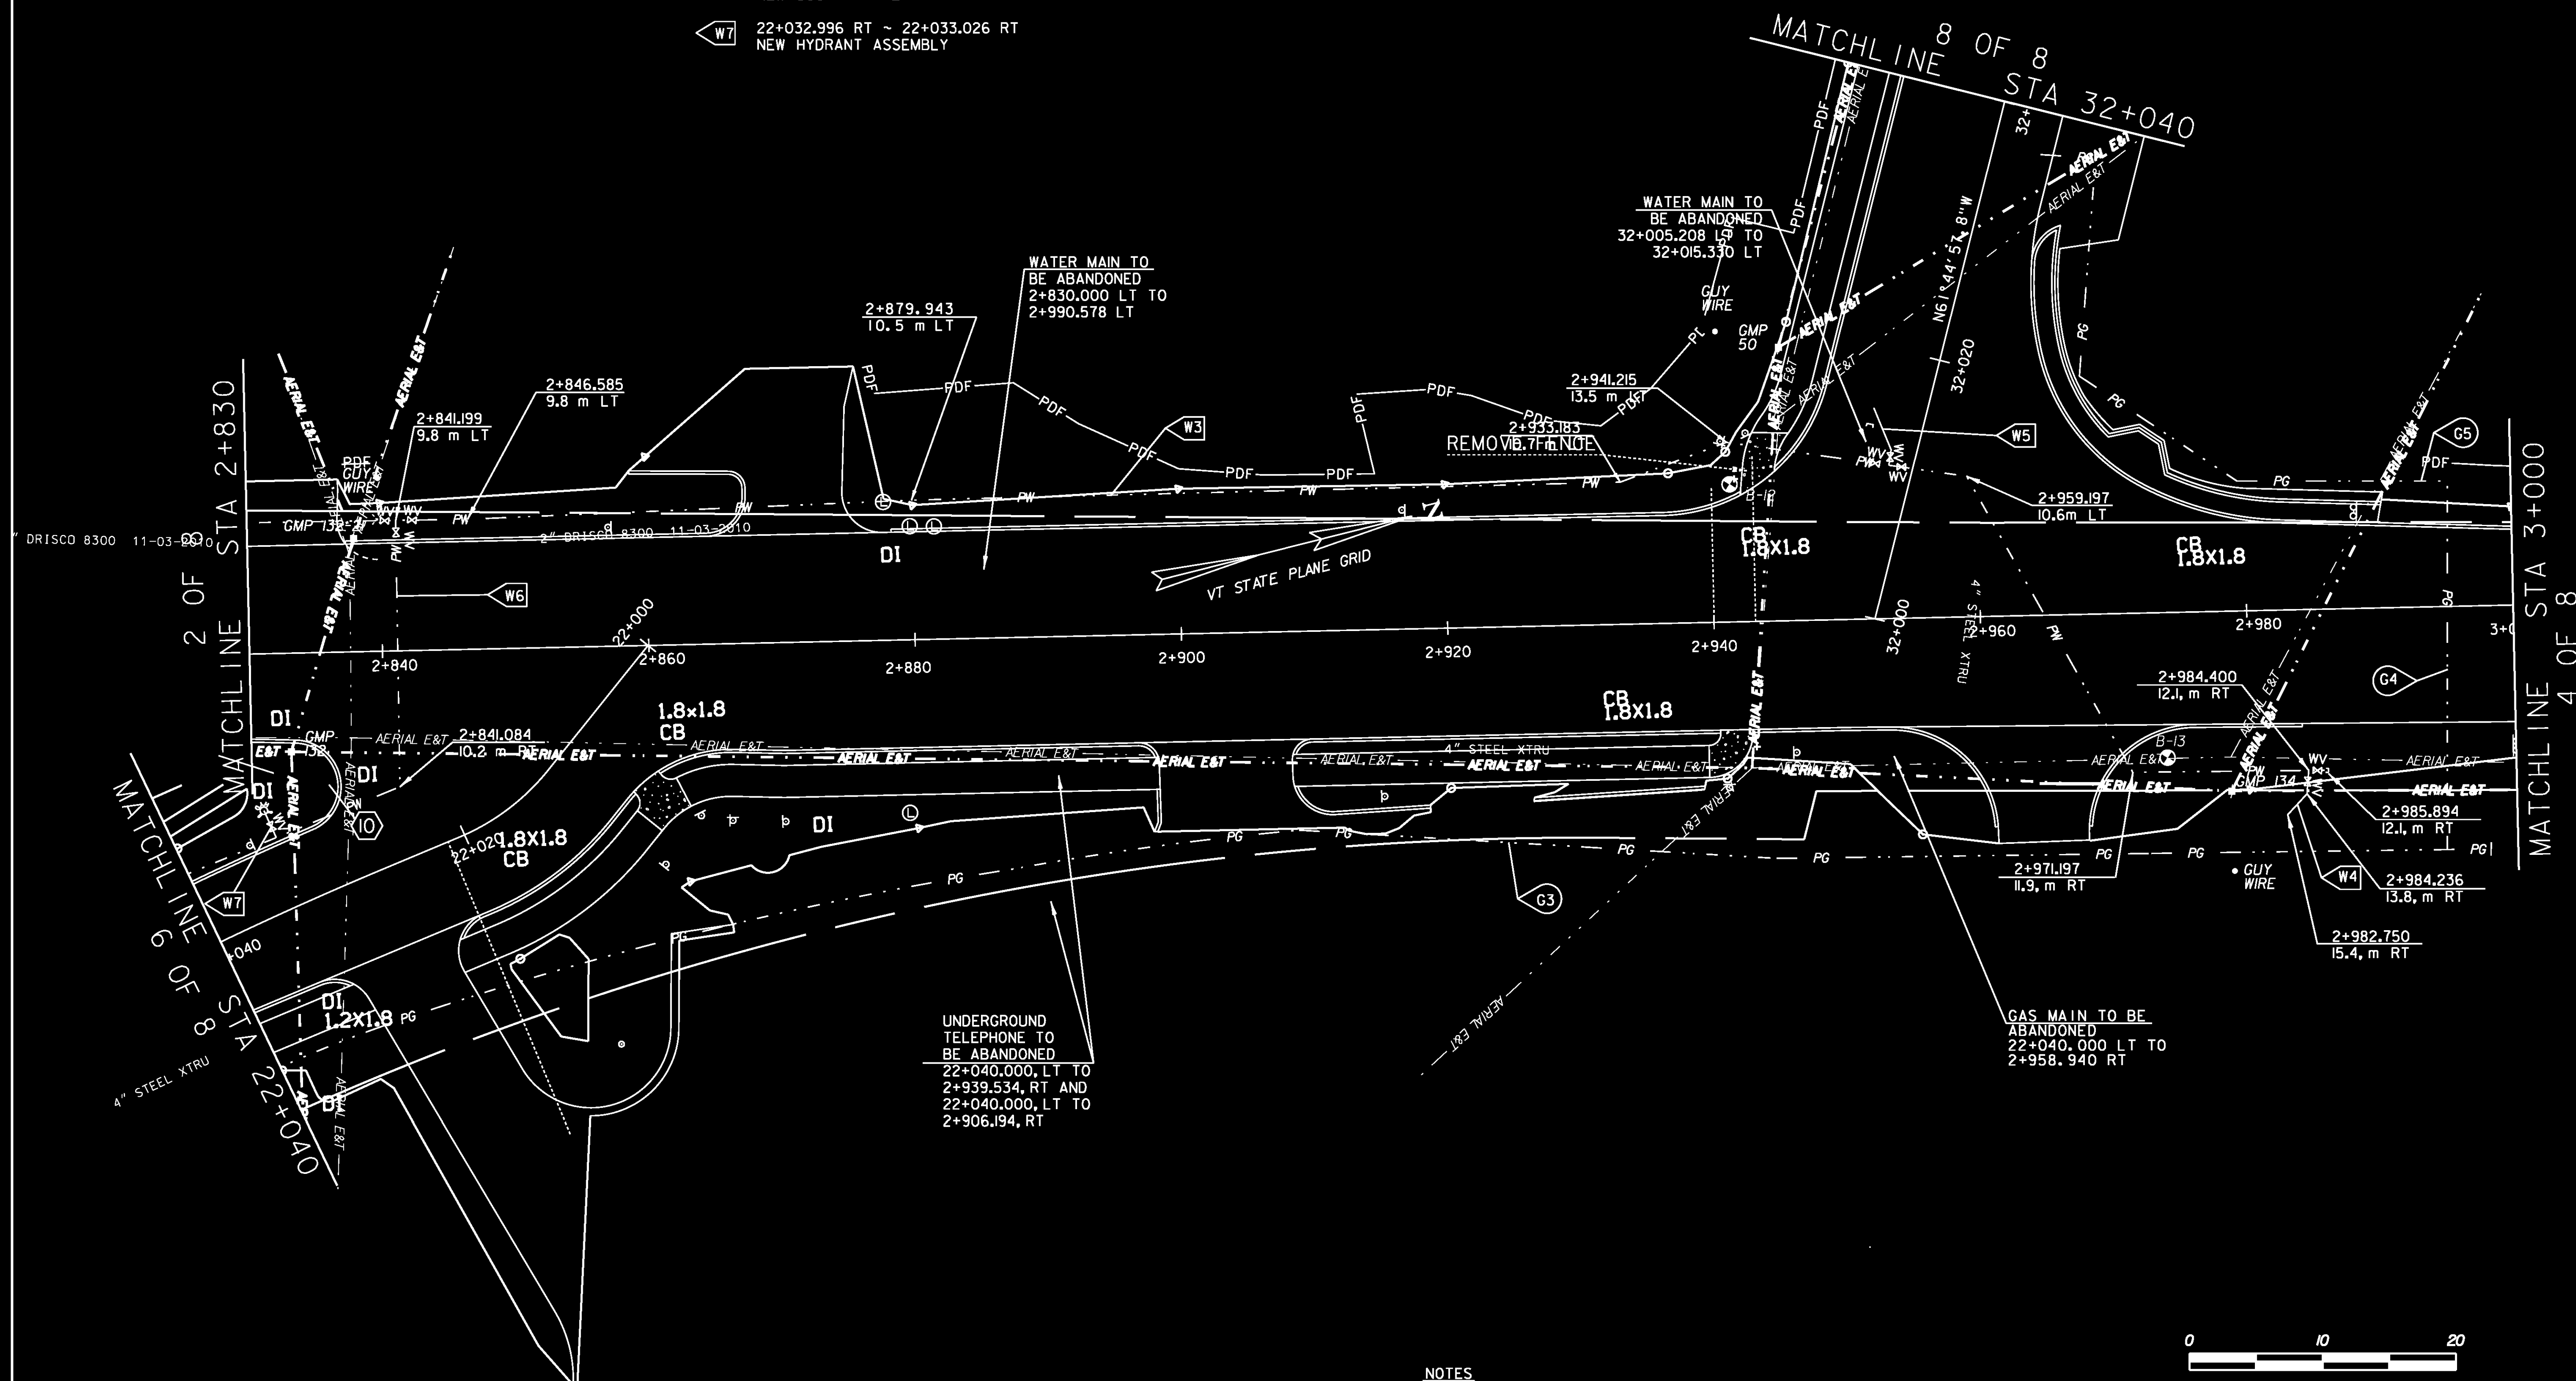

NOTES

- 1) SEE SIGNAL PLANS FOR LOCATIONS OF TRAFFIC SIGNALS AND MAST ARMS.
- 2) SEE DRAINAGE PLANS FOR LOCATION OF PROPOSED DRAINAGE FACILITIES.
- 3) SEE CONSTRUCTION PLANS FOR ADDITIONAL PROPOSED FACILITIES.

PROJECT NAME: COLCHESTER
PROJECT NUMBER: STP 5600(9)S

FILE NAME: r97d206UTL3.dgn
PROJECT LEADER: J. SCHULTZ
DESIGNED BY: D. BRYANT
UTILITY SHEET 3 OF 8

PLOT DATE: 21-FEB-2013
DRAWN BY: T. KELLEY
CHECKED BY: D. BURHANS
SHEET 43 OF 74