


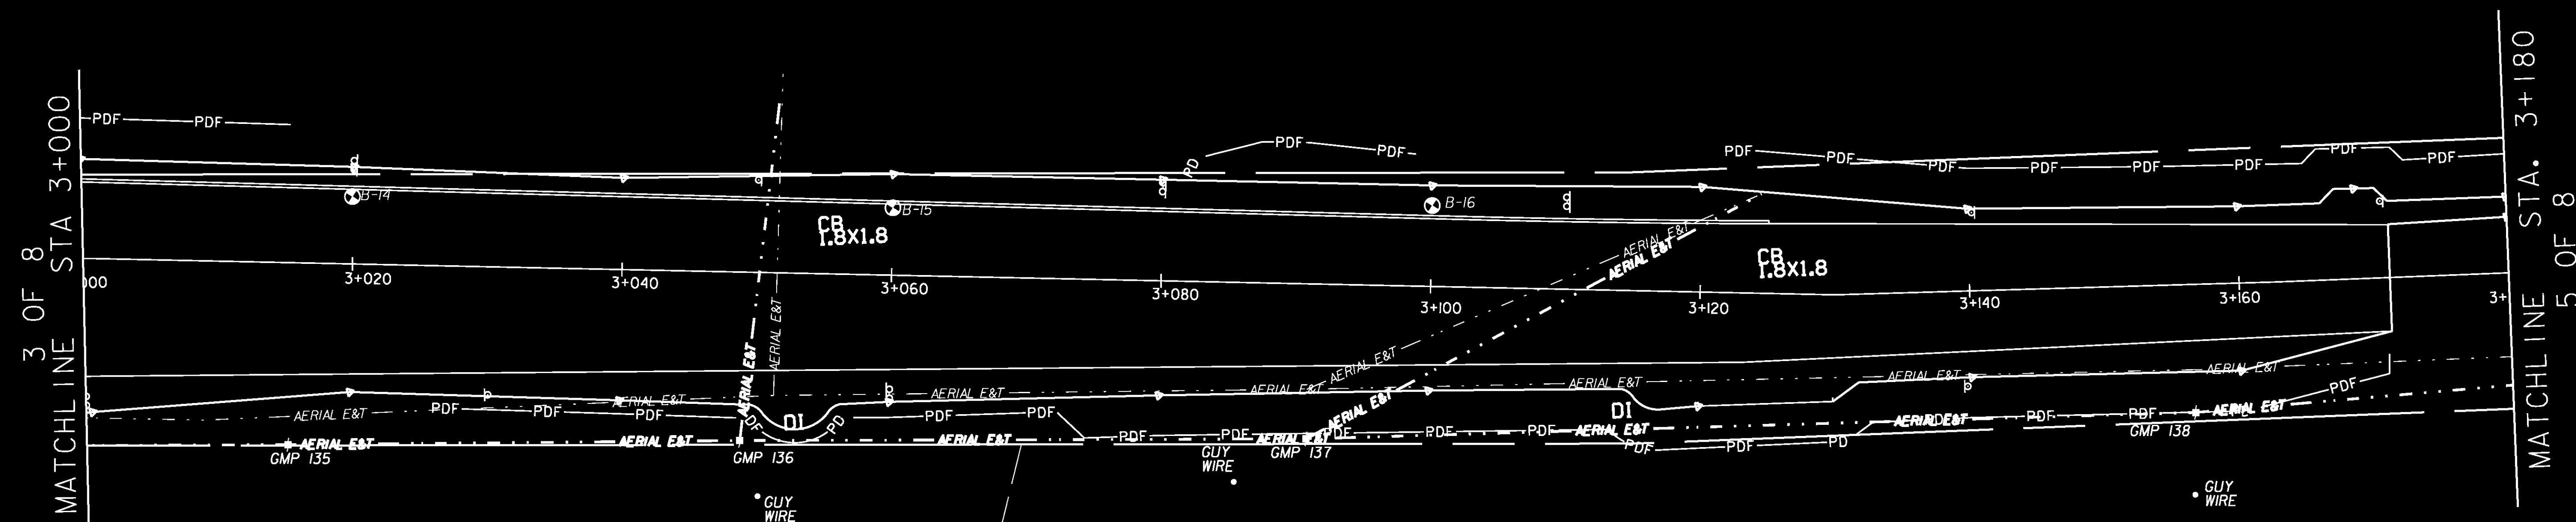

NOTES

- 1) SEE DRAINAGE PLANS FOR LOCATION OF PROPOSED DRAINAGE FACILITIES.
- 2) SEE CONSTRUCTION PLANS FOR ADDITIONAL PROPOSED FACILITIES.



PROJECT NAME: COLCHESTER	
PROJECT NUMBER: STP 5600(9)S	
FILE NAME: r97d206UTL4.dgn	PLOT DATE: 21-FEB-2013
PROJECT LEADER: J. SCHULTZ	DRAWN BY: T. KELLEY
DESIGNED BY: D. BRYANT	CHECKED BY: D. BURHANS
UTILITY SHEET 4 OF 8	SHEET 44 OF 74