


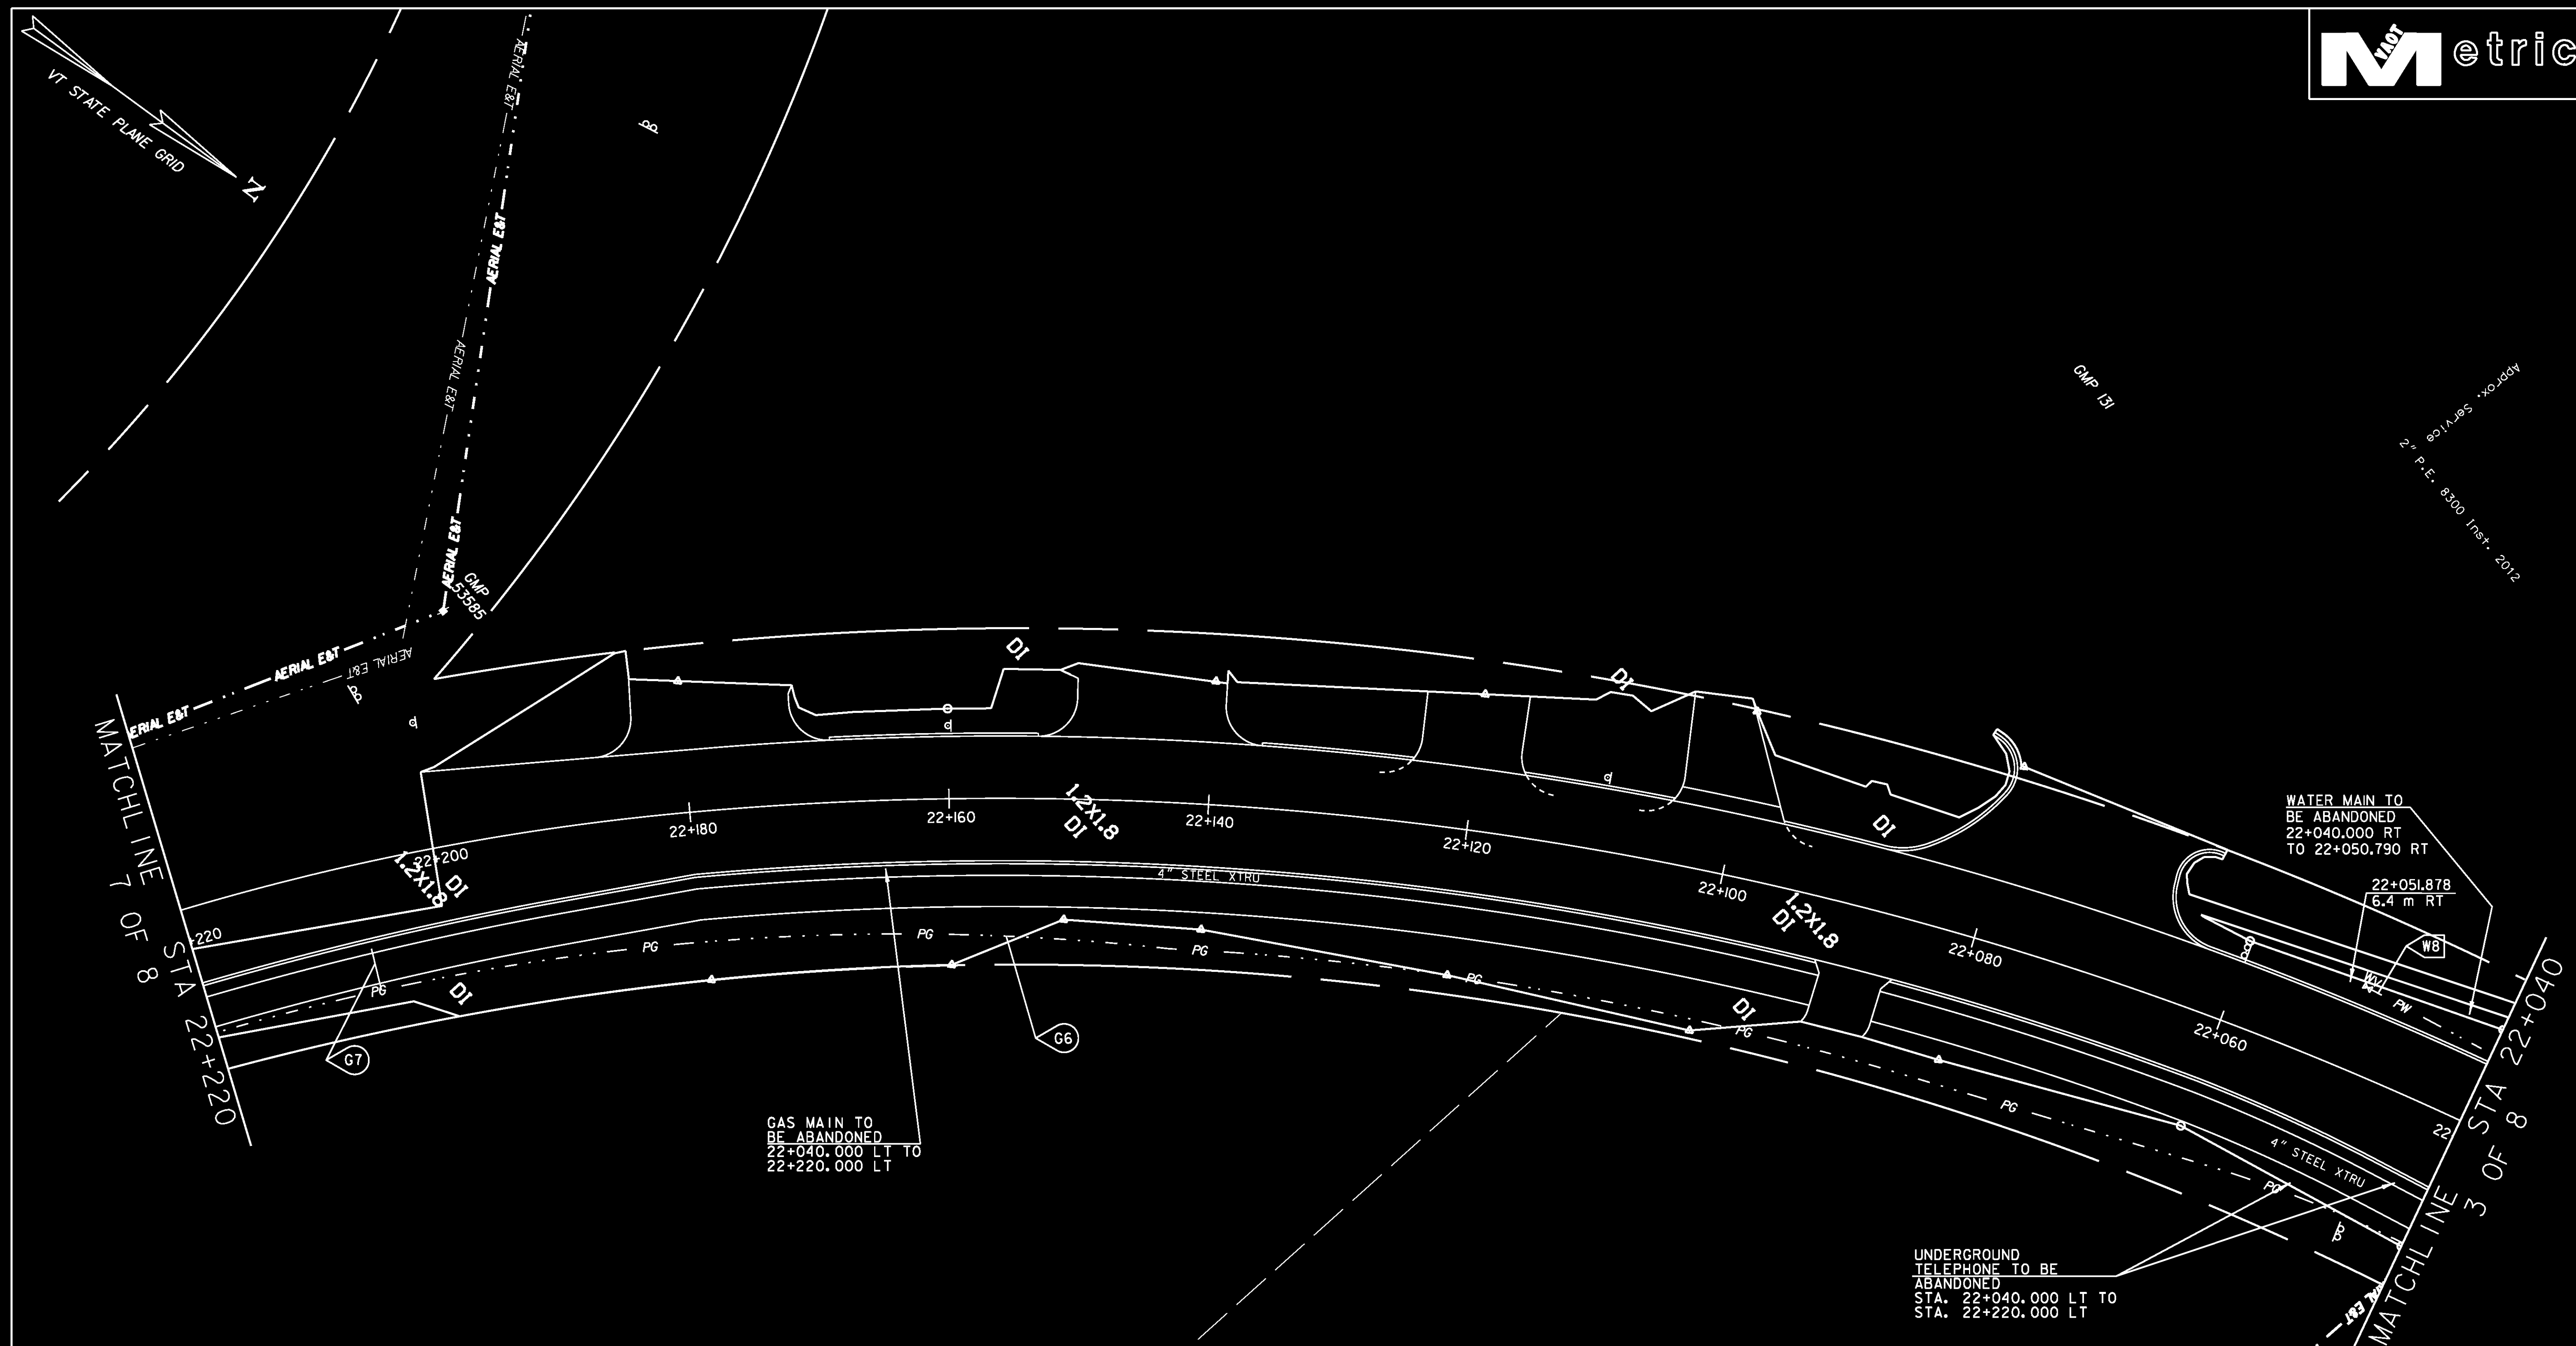

GAS MAIN TO
BE ABANDONED
22+040.000 LT TO
22+220.000 LT

WATER MAIN TO
BE ABANDONED
22+040.000 RT
TO 22+050.790 RT

NEW GAS MAIN (BY OTHERS)

- G6 22+040.000 LT Δ 22+220.000 LT
NEW 100 mm XTRU PIPE
- G7 22+206.254 LT Δ 22+206.309 LT
NEW 100 mm XTRU PIPE

NEW WATER MAIN

- W8 22+040.000 RT Δ 22+050.790 RT
NEW 300 mm PIPE



NOTES

- SEE DRAINAGE PLANS FOR LOCATION OF PROPOSED DRAINAGE FACILITIES.
- SEE CONSTRUCTION PLANS FOR ADDITIONAL PROPOSED FACILITIES.

PROJECT NAME: Colchester
PROJECT NUMBER: STP 5600(9)S

FILE NAME: r97d206UTL6.dgn
PROJECT LEADER: D Bryant
DESIGNED BY: D Bryant
UTILITY PLAN SHEET 6 OF 8

PLOT DATE: 21-FEB-2013
DRAWN BY: T Kelley
CHECKED BY: D Burhans
SHEET 46 OF 74