
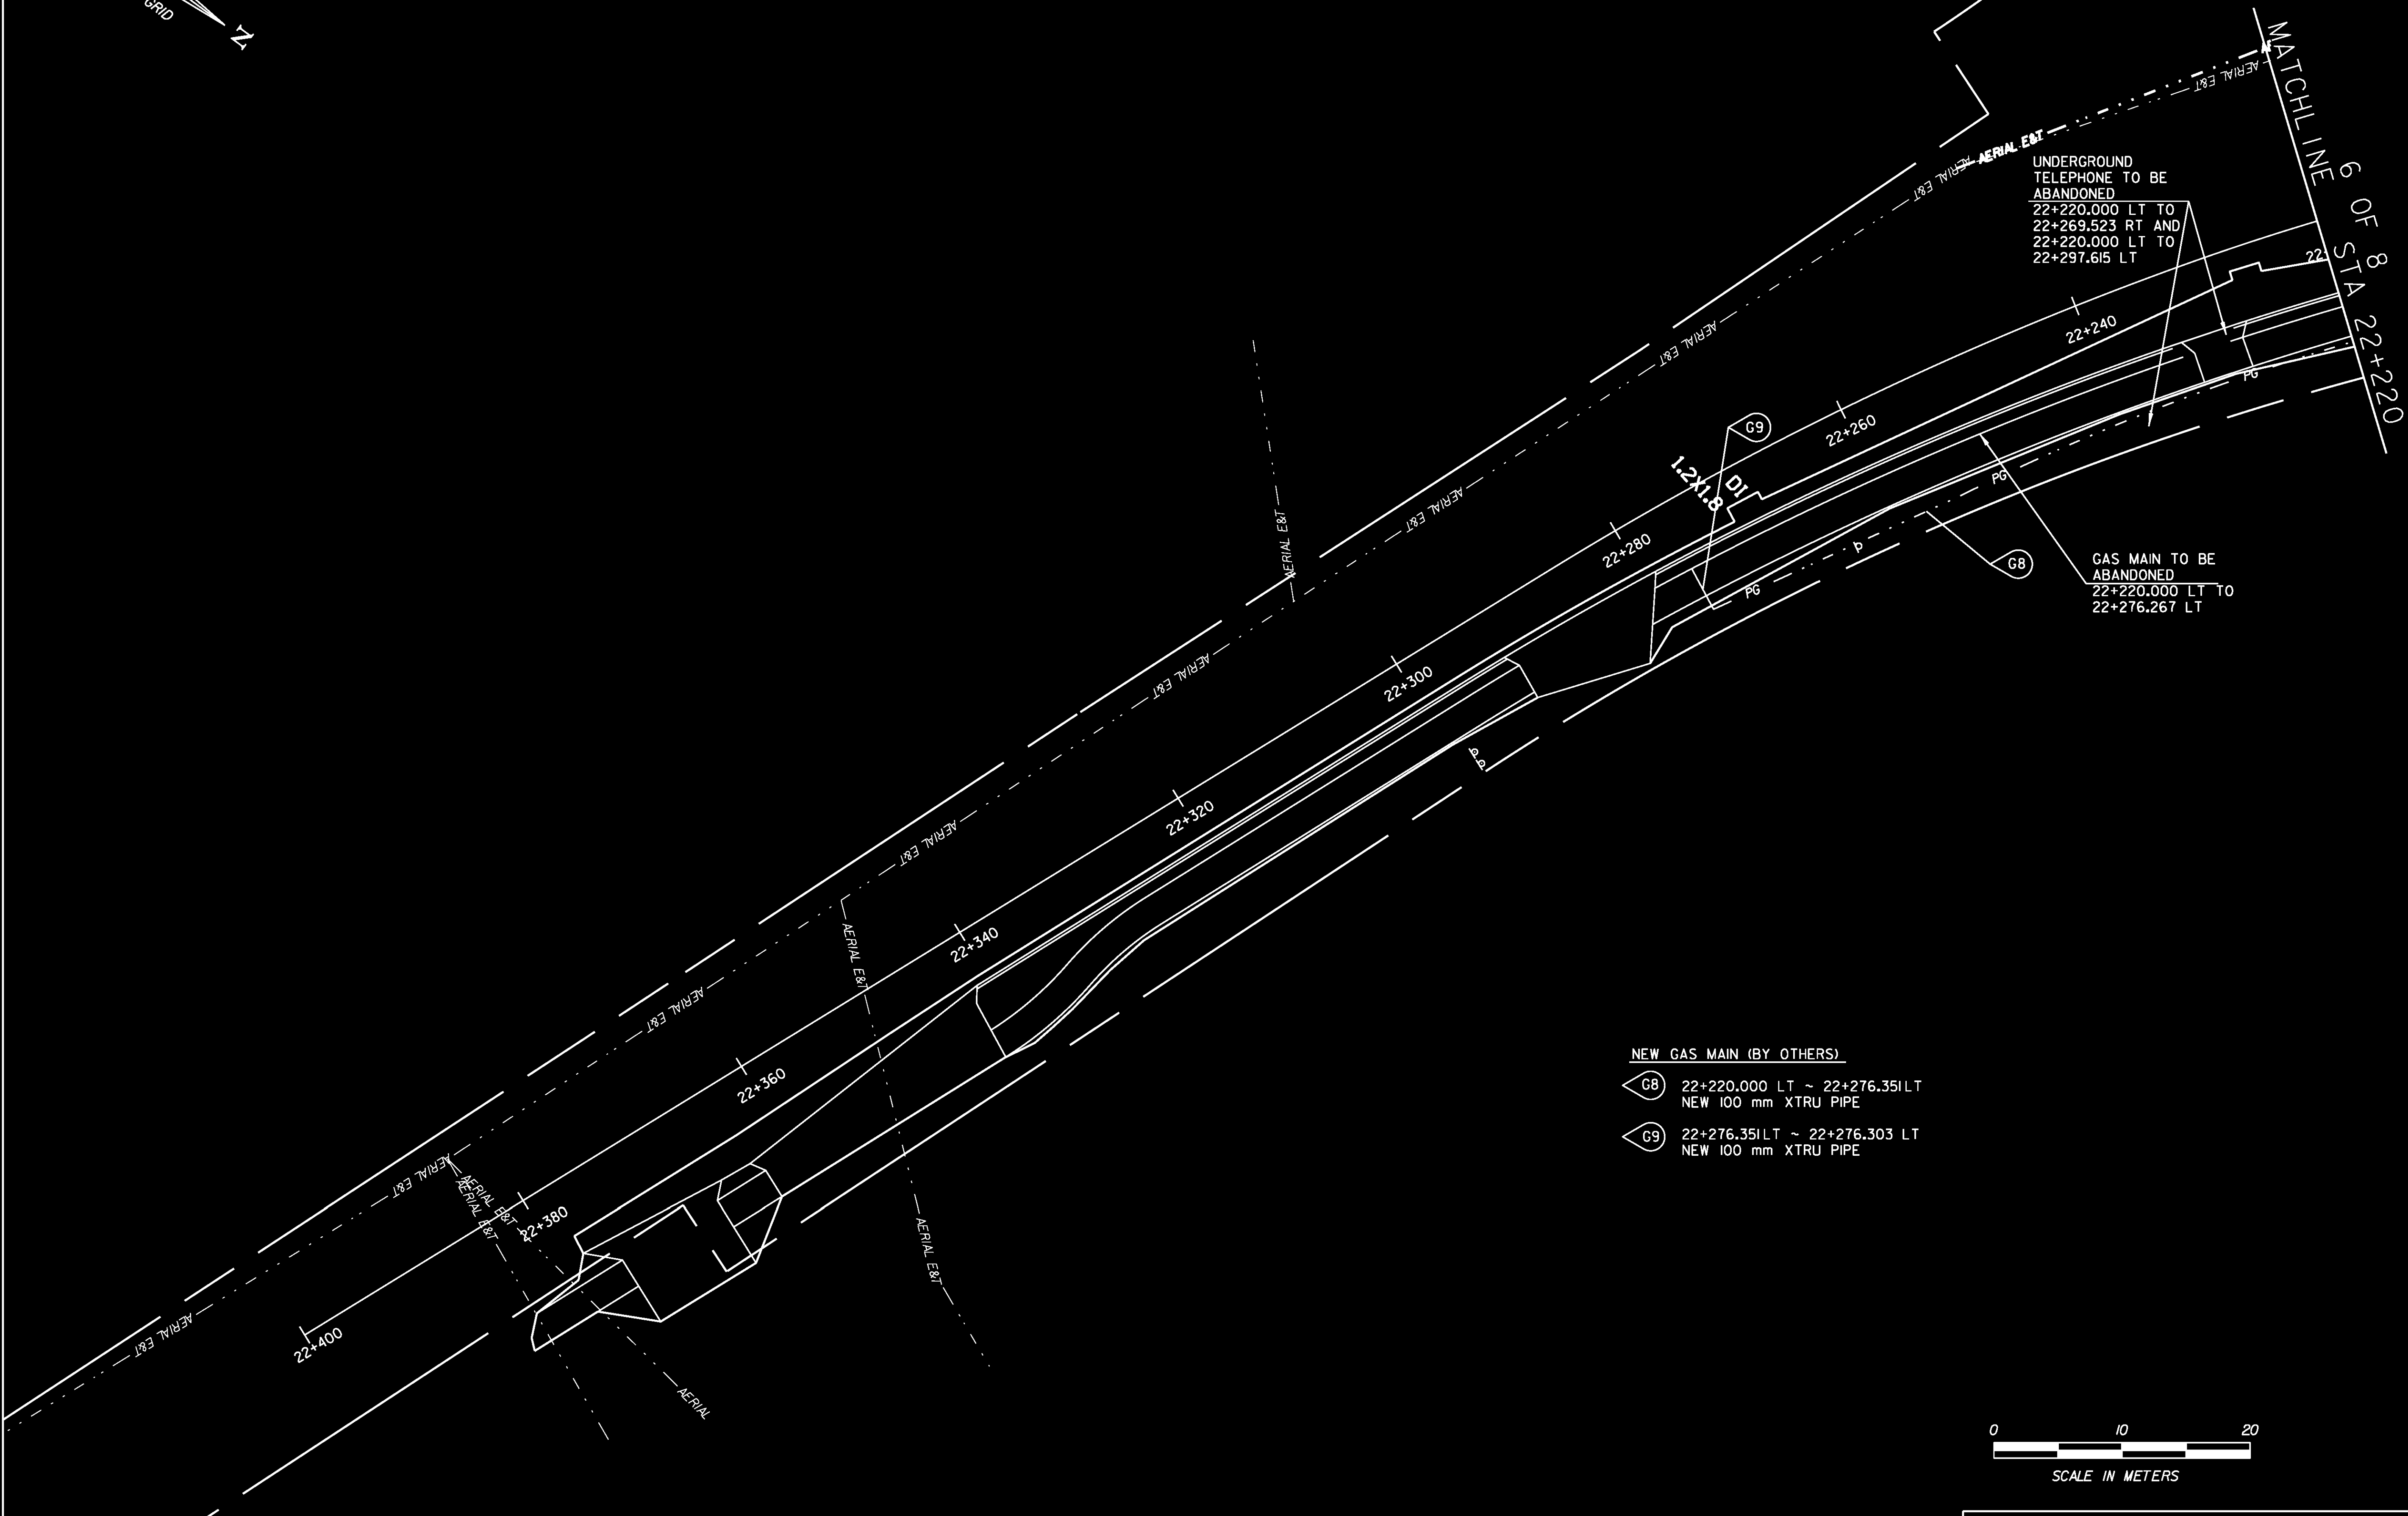


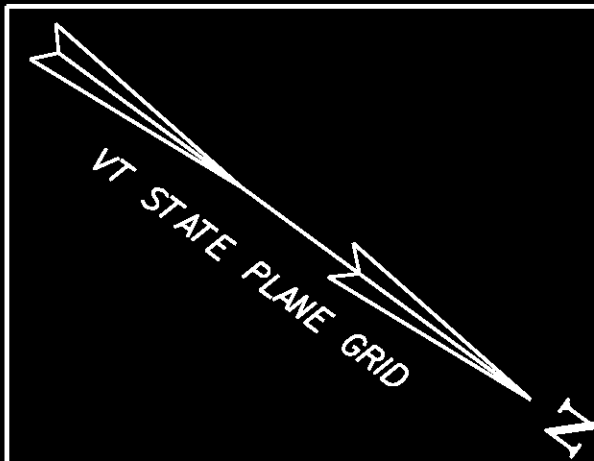

NEW GAS MAIN (BY OTHERS)

- G8 22+220.000 LT ~ 22+276.351 LT
NEW 100 mm XTRU PIPE
- G9 22+276.351 LT ~ 22+276.303 LT
NEW 100 mm XTRU PIPE

NOTES

- SEE DRAINAGE PLANS FOR LOCATION OF PROPOSED DRAINAGE FACILITIES.
- SEE CONSTRUCTION PLANS FOR ADDITIONAL PROPOSED FACILITIES.

PROJECT NAME: Colchester	
PROJECT NUMBER: STP 5600(9)S	
FILE NAME: r97d206UTL7.dgn	PLOT DATE: 21-FEB-2013
PROJECT LEADER: D Bryant	DRAWN BY: T Kelley
DESIGNED BY: D Bryant	CHECKED BY: D Burhans
UTILITY PLAN SHEET 7 OF 8	SHEET 47 OF 74

DATUM	NAVD 88
VERTICAL	
HORIZONTAL	NAD 83/96