


MAXON, RANDY G. & DONNA M.

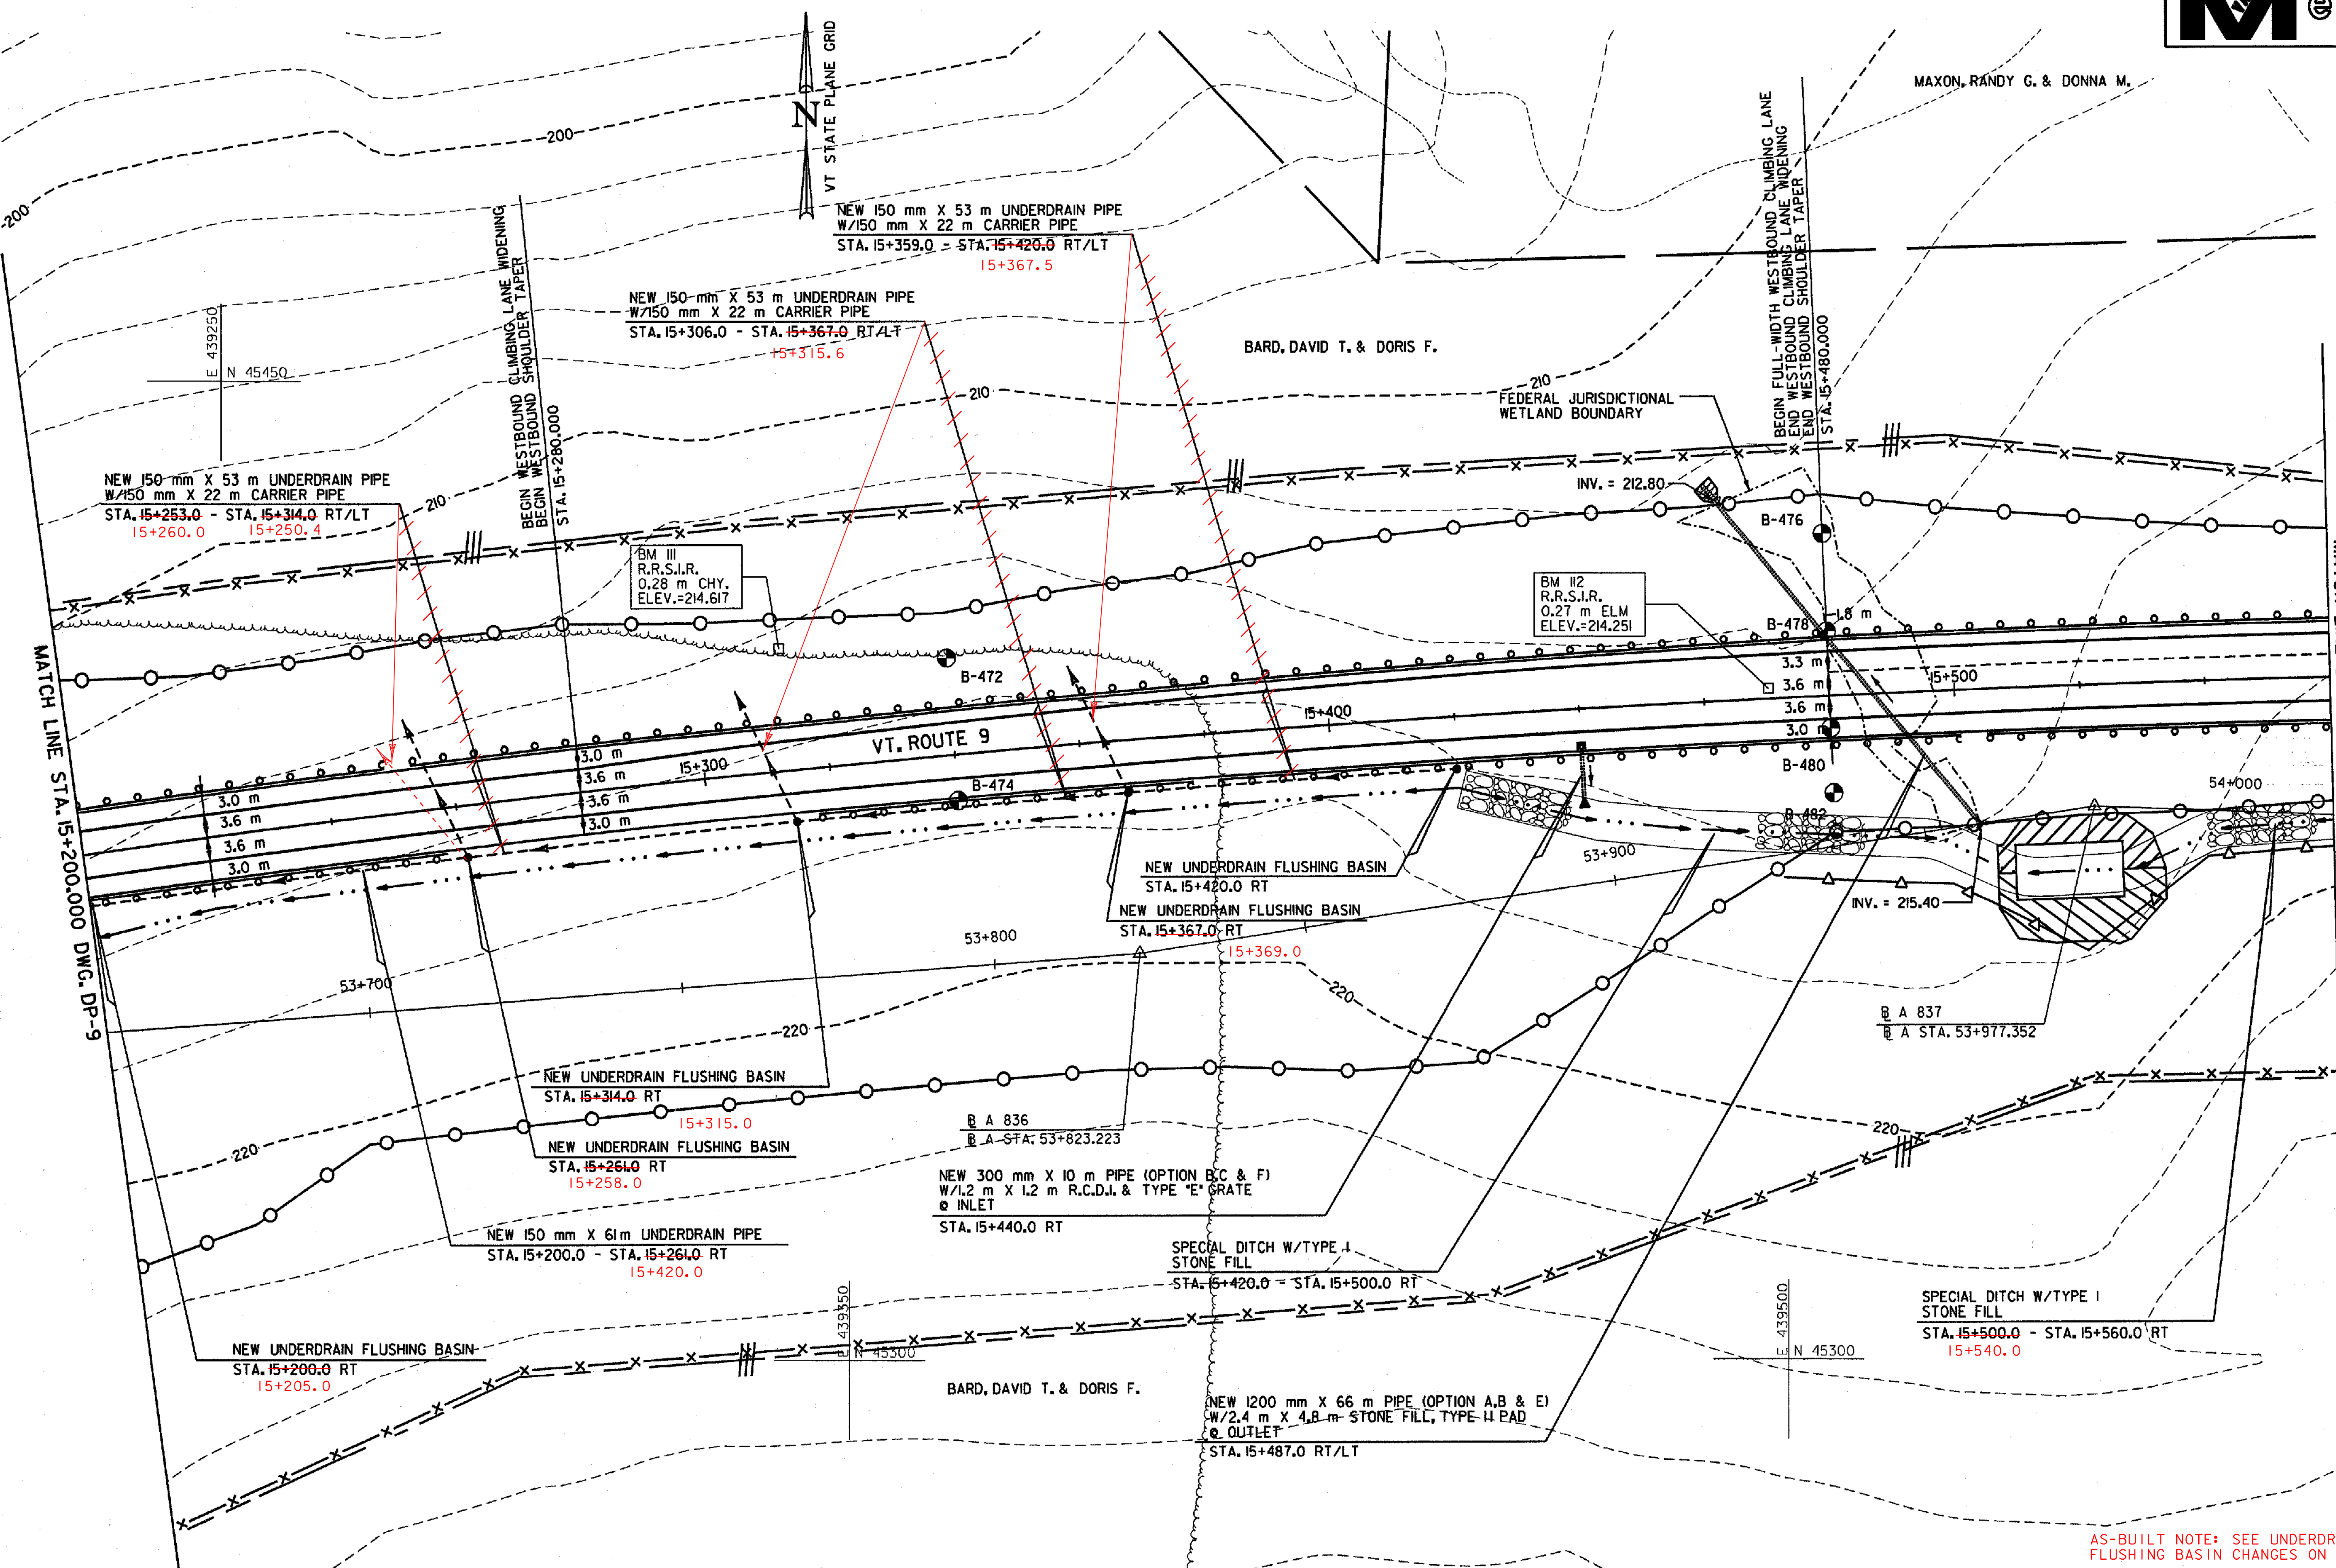


MATCH LINE STA. 15+200.000 DWG. DP-9

MATCH LINE STA. 15+560.000 DWG. DP-11

- NOTES:
- DIMENSIONS FOR STONE PADS ARE GIVEN IN THE FOLLOWING FORMAT: (WIDTH x LENGTH).
 - DRAINAGE PIPE OPTIONS ARE AS FOLLOWS:
 - OPTION A - RCP
 - OPTION B - PCCSP
 - OPTION C - CAAP
 - OPTION D - CPEP(SL)
 - OPTION E - PCCSP(W/P)
 - OPTION F - CPEP

DATUM	
VERTICAL	NAVD 88
HORIZONTAL	NAD 83 (1992)

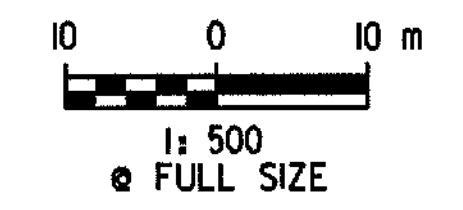

DRAINAGE PLAN

AS-BUILT NOTE: SEE UNDERDRAIN PIPE & FLUSHING BASIN CHANGES ON THIS SHEET
RMT 2/1/06

SURVEYED BY	C.H.A. & V.S.E.	DATE	12/93
DESIGNED BY	D.E.G.	DATE	11/01
DRAWN BY	J.S.L.	DATE	11/01
CHECKED BY	T.P.K.	DATE	11/01
DESIGN FILE NO.	/5116/vaot/vtdp17.dgn		
PROJ. NAME	BENNINGTON - HOOSICK		
PROJ. NO.	P.I.N. 1306.60		
DWG NO.	DP-10	SHEET	117 OF 473

FILE NAME = J:\5116\VAOT\CONTRACT3\VTDP17.DGN
DATE/TIME = 10/11/2001
USER = 664