


PHASE 3 CONSTRUCTION NOTES:

1. ESTABLISH PHASE 3 TRAFFIC PATTERNS AS SHOWN.
2. CONSTRUCT RAMP CD, RAMP C, RAMP D AND RAMP X TO LIMITS SHOWN.
3. INSTALL TRAFFIC SIGNAL AT VT. ROUTE 67A/RAMP CD INTERSECTION, ALSO INSTALL CONDUIT FOR STREET LIGHTING BENEATH RAMP'S AS INDICATED ON STREET LIGHTING PLANS.
4. USING SHORT DURATION SHOULDER AND LANE CLOSURES (SEE VAOT STANDARD SHEETS E-106M, E-110M AND E-111M), CONSTRUCT PROPOSED SANITARY SEWER LINE AND WATER LINE.
5. USING SHORT DURATION SHOULDER CLOSURES (SEE VAOT STANDARD SHEET E-111M), CONSTRUCT DETOUR 3 AND DETOUR 4 (TO STA. 4+050).
6. USING SHORT DURATION LANE CLOSURES (SEE VAOT STANDARD SHEETS E-106M AND E-110M), CONSTRUCT VT. ROUTE 67A LANE WIDENING OPERATIONS.
7. DIRECT EASTBOUND TRAFFIC THROUGH DETOUR 3 ONTO COMPLETED RAMP D AND RAMP CD (SEE PHASE 3 FOR DETAILS).
8. CONSTRUCT REMAINING PORTION OF TEMPORARY DETOUR 4.

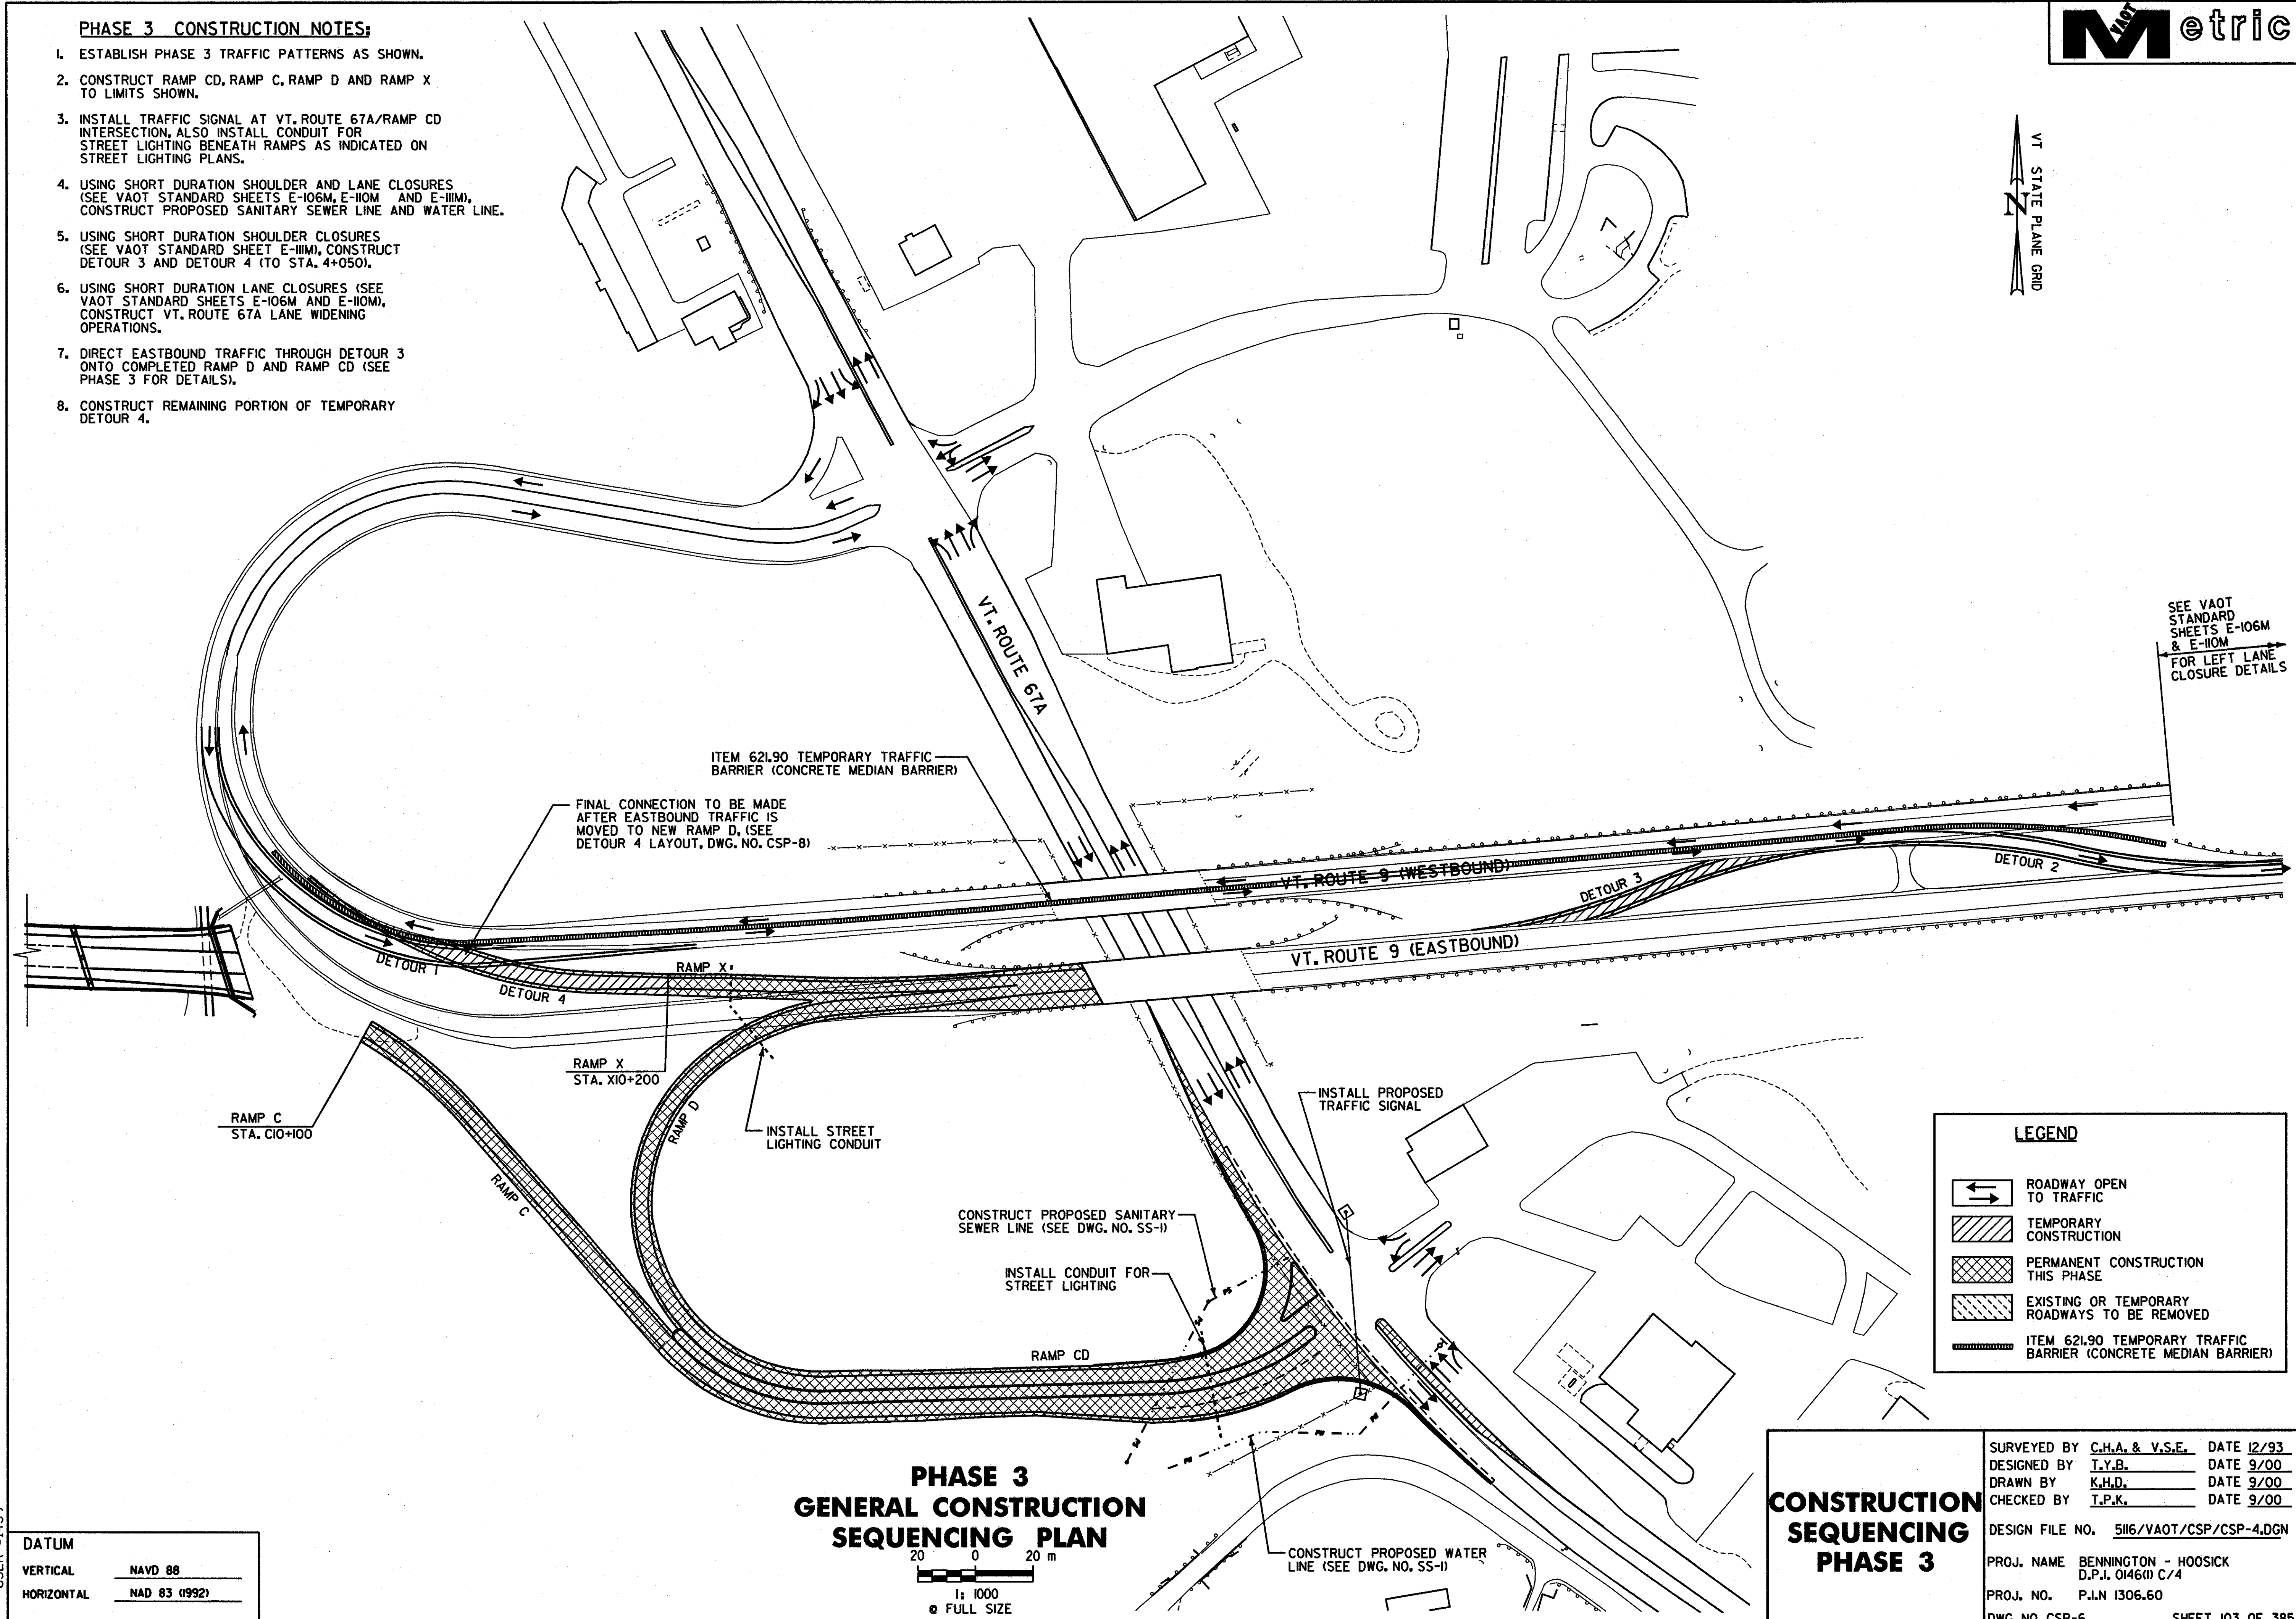


SEE VAOT STANDARD SHEETS E-106M & E-110M FOR LEFT LANE CLOSURE DETAILS

LEGEND

	ROADWAY OPEN TO TRAFFIC
	TEMPORARY CONSTRUCTION
	PERMANENT CONSTRUCTION THIS PHASE
	EXISTING OR TEMPORARY ROADWAYS TO BE REMOVED
	ITEM 621.90 TEMPORARY TRAFFIC BARRIER (CONCRETE MEDIAN BARRIER)

**PHASE 3
GENERAL CONSTRUCTION
SEQUENCING PLAN**

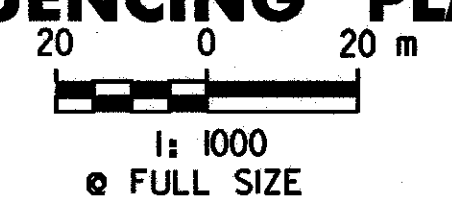

DATUM

VERTICAL	NAVD 88
HORIZONTAL	NAD 83 (1992)

**CONSTRUCTION
SEQUENCING
PHASE 3**

SURVEYED BY	C.H.A. & V.S.E.	DATE	12/93
DESIGNED BY	T.Y.B.	DATE	9/00
DRAWN BY	K.H.D.	DATE	9/00
CHECKED BY	T.P.K.	DATE	9/00
DESIGN FILE NO.	516/VAOT/CSP/CSP-4.DGN		
PROJ. NAME	BENNINGTON - HOOSICK D.P.L. 0146(1) C/4		
PROJ. NO.	P.L.N 1306.60		
DWG NO. CSP-6	SHEET 103 OF 385		

FILE NAME = u:\5116\vaot\contract4\csp\csp-4.dgn
 DATE/TIME = 07 SEP 2000
 USER = 1459