


PHASE 4 CONSTRUCTION NOTES:


1. INSTALL SIGNS AND LANE CONFIGURATION ON VT. ROUTE 67A AS SHOWN ON DWG. NO. CSP-II AND CSP-12.
2. ESTABLISH PHASE 4 TRAFFIC PATTERNS AS SHOWN.
3. CONSTRUCT RAMP B, RAMP AB AND RAMP Y TO LIMITS SHOWN. STAGE CONSTRUCTION OF VT. ROUTE 67A/RAMP AB TIE-IN AS DETAILED ON DWG. NO. CSP-10.
4. INSTALL NEW TRAFFIC SIGNAL AT VT. ROUTE 67/RAMP AB INTERSECTION. ALSO INSTALL CONDUIT FOR STREET LIGHTING BENEATH RAMPS AS INDICATED ON THE STREET LIGHTING PLANS (SEE SLP SERIES SHEETS).
5. USING SHORT DURATION SHOULDER CLOSURES (SEE VAOT STANDARD SHEET E-111M), REMOVE TEMPORARY DETOURS 1 AND 2 AND EXISTING VT. ROUTE 9 WESTBOUND RAMP TO VT. ROUTE 67A (LIMITS SHOWN ON THIS DWG.).
6. CONCRETE BARRIER DELINEATORS, REFLECTORS AND OBJECT MARKERS SHALL BE INSTALLED ALONG VT. ROUTE 9 AND DETOUR 3 IN ACCORDANCE WITH THE LAYOUT SHOWN ON THE VAOT STANDARD SHEETS E-103M AND E-104M. THE COST OF THESE ITEMS SHALL BE INCLUDED IN ITEM 621.90 TEMPORARY TRAFFIC BARRIER (CONCRETE MEDIAN BARRIER).

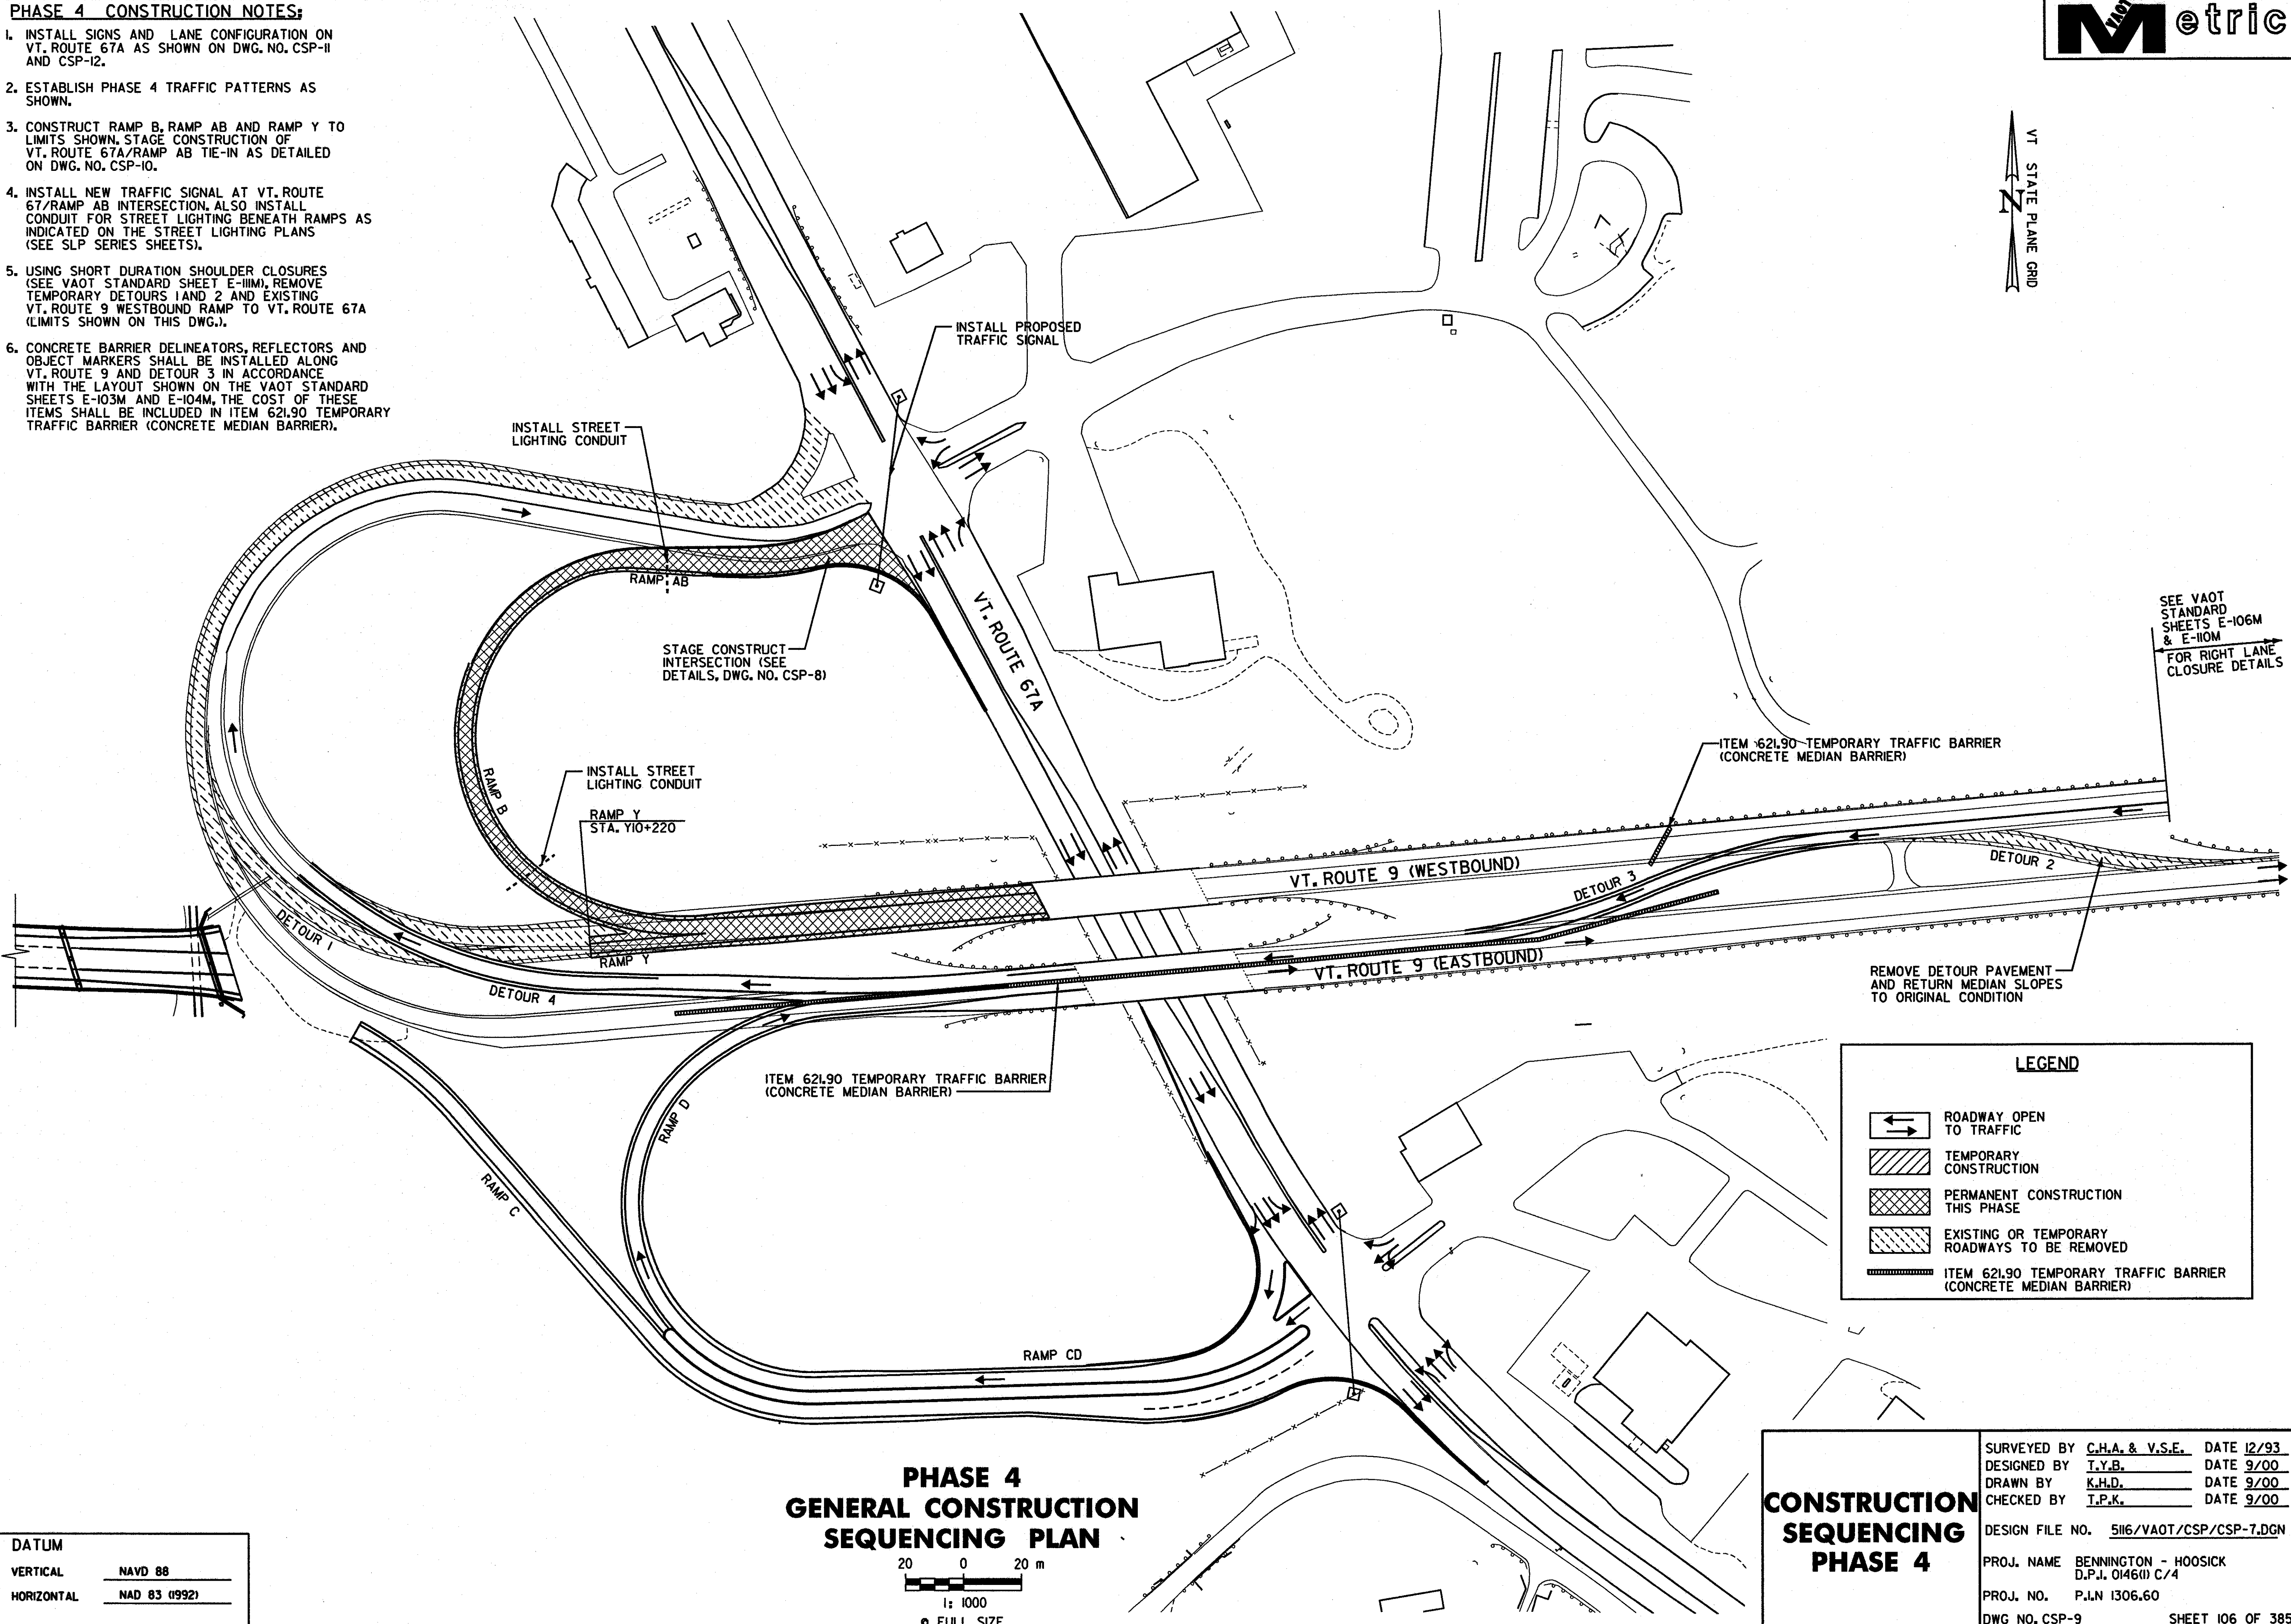

LEGEND

	ROADWAY OPEN TO TRAFFIC
	TEMPORARY CONSTRUCTION
	PERMANENT CONSTRUCTION THIS PHASE
	EXISTING OR TEMPORARY ROADWAYS TO BE REMOVED
	ITEM 621.90 TEMPORARY TRAFFIC BARRIER (CONCRETE MEDIAN BARRIER)

**PHASE 4
GENERAL CONSTRUCTION
SEQUENCING PLAN**

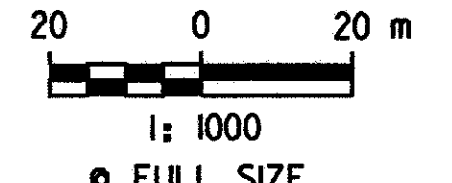

DATUM	
VERTICAL	NAVD 88
HORIZONTAL	NAD 83 (1992)

**CONSTRUCTION
SEQUENCING
PHASE 4**

SURVEYED BY	C.H.A. & V.S.E.	DATE	12/93
DESIGNED BY	T.Y.B.	DATE	9/00
DRAWN BY	K.H.D.	DATE	9/00
CHECKED BY	T.P.K.	DATE	9/00
DESIGN FILE NO.	5116/VAOT/CSP/CSP-7.DGN		
PROJ. NAME	BENNINGTON - HOOSICK D.P.J. 0146(1) C/4		
PROJ. NO.	P.L.N 1306.60		
DWG NO. CSP-9	SHEET 106 OF 385		

FILE NAME =u:\5116\vaot\contract4\csp\csp-7.dgn
 DATE/TIME =07 SEP 2000
 USER =1459