


VT STATE PLANE GRID

**PHASE 5 CONSTRUCTION NOTES:**

1. ESTABLISH PHASE 5 TRAFFIC PATTERNS AS SHOWN.
2. INSTALL REMAINING PORTION OF CONDUIT FOR STREET LIGHTING BENEATH RAMP AB AS INDICATED ON STREET LIGHTING PLANS.
3. CONSTRUCT RAMPS A, AB, C, X AND Y TO LIMITS SHOWN. COLD PLANE AND PAVE FINAL SURFACE ON VT. ROUTE 67A. CONTRACTOR SHALL ENSURE THAT ALL CONDUITS AND DUCTS FOR TRAFFIC SIGNALS AND STREET LIGHTING ARE INSTALLED ALONG VT. ROUTE 67A PRIOR TO FINAL PAVING ON VT. ROUTE 67A.
4. USING SHORT DURATION SHOULDER CLOSURES (SEE VAOT STANDARD SHEET E-111M), REMOVE EXISTING WESTBOUND RAMP TO VT. ROUTE 67A. ALSO REMOVE TEMPORARY DETOUR 3 AND DETOUR 4 PAVEMENT.
5. COMPLETE REMAINING INCIDENTAL WORK ITEMS.

**COLD PLANING AND PAVING NOTES:**

1. THE MINIMUM LANE WIDTH OF 3 m SHALL BE MAINTAINED.
2. THERE SHALL BE NO LONGITUDINAL DROP OFFS DURING THE OVERNIGHT HOURS. THEREFORE, THE FULL ROADWAY WIDTH MUST BE COLD PLANED AND PAVED DURING THE DAILY WORK PERIOD.
3. ALL COLD PLANED AREAS SHALL BE PAVED WITH A LEVELING COURSE FOR THE TRAVELING PUBLIC.

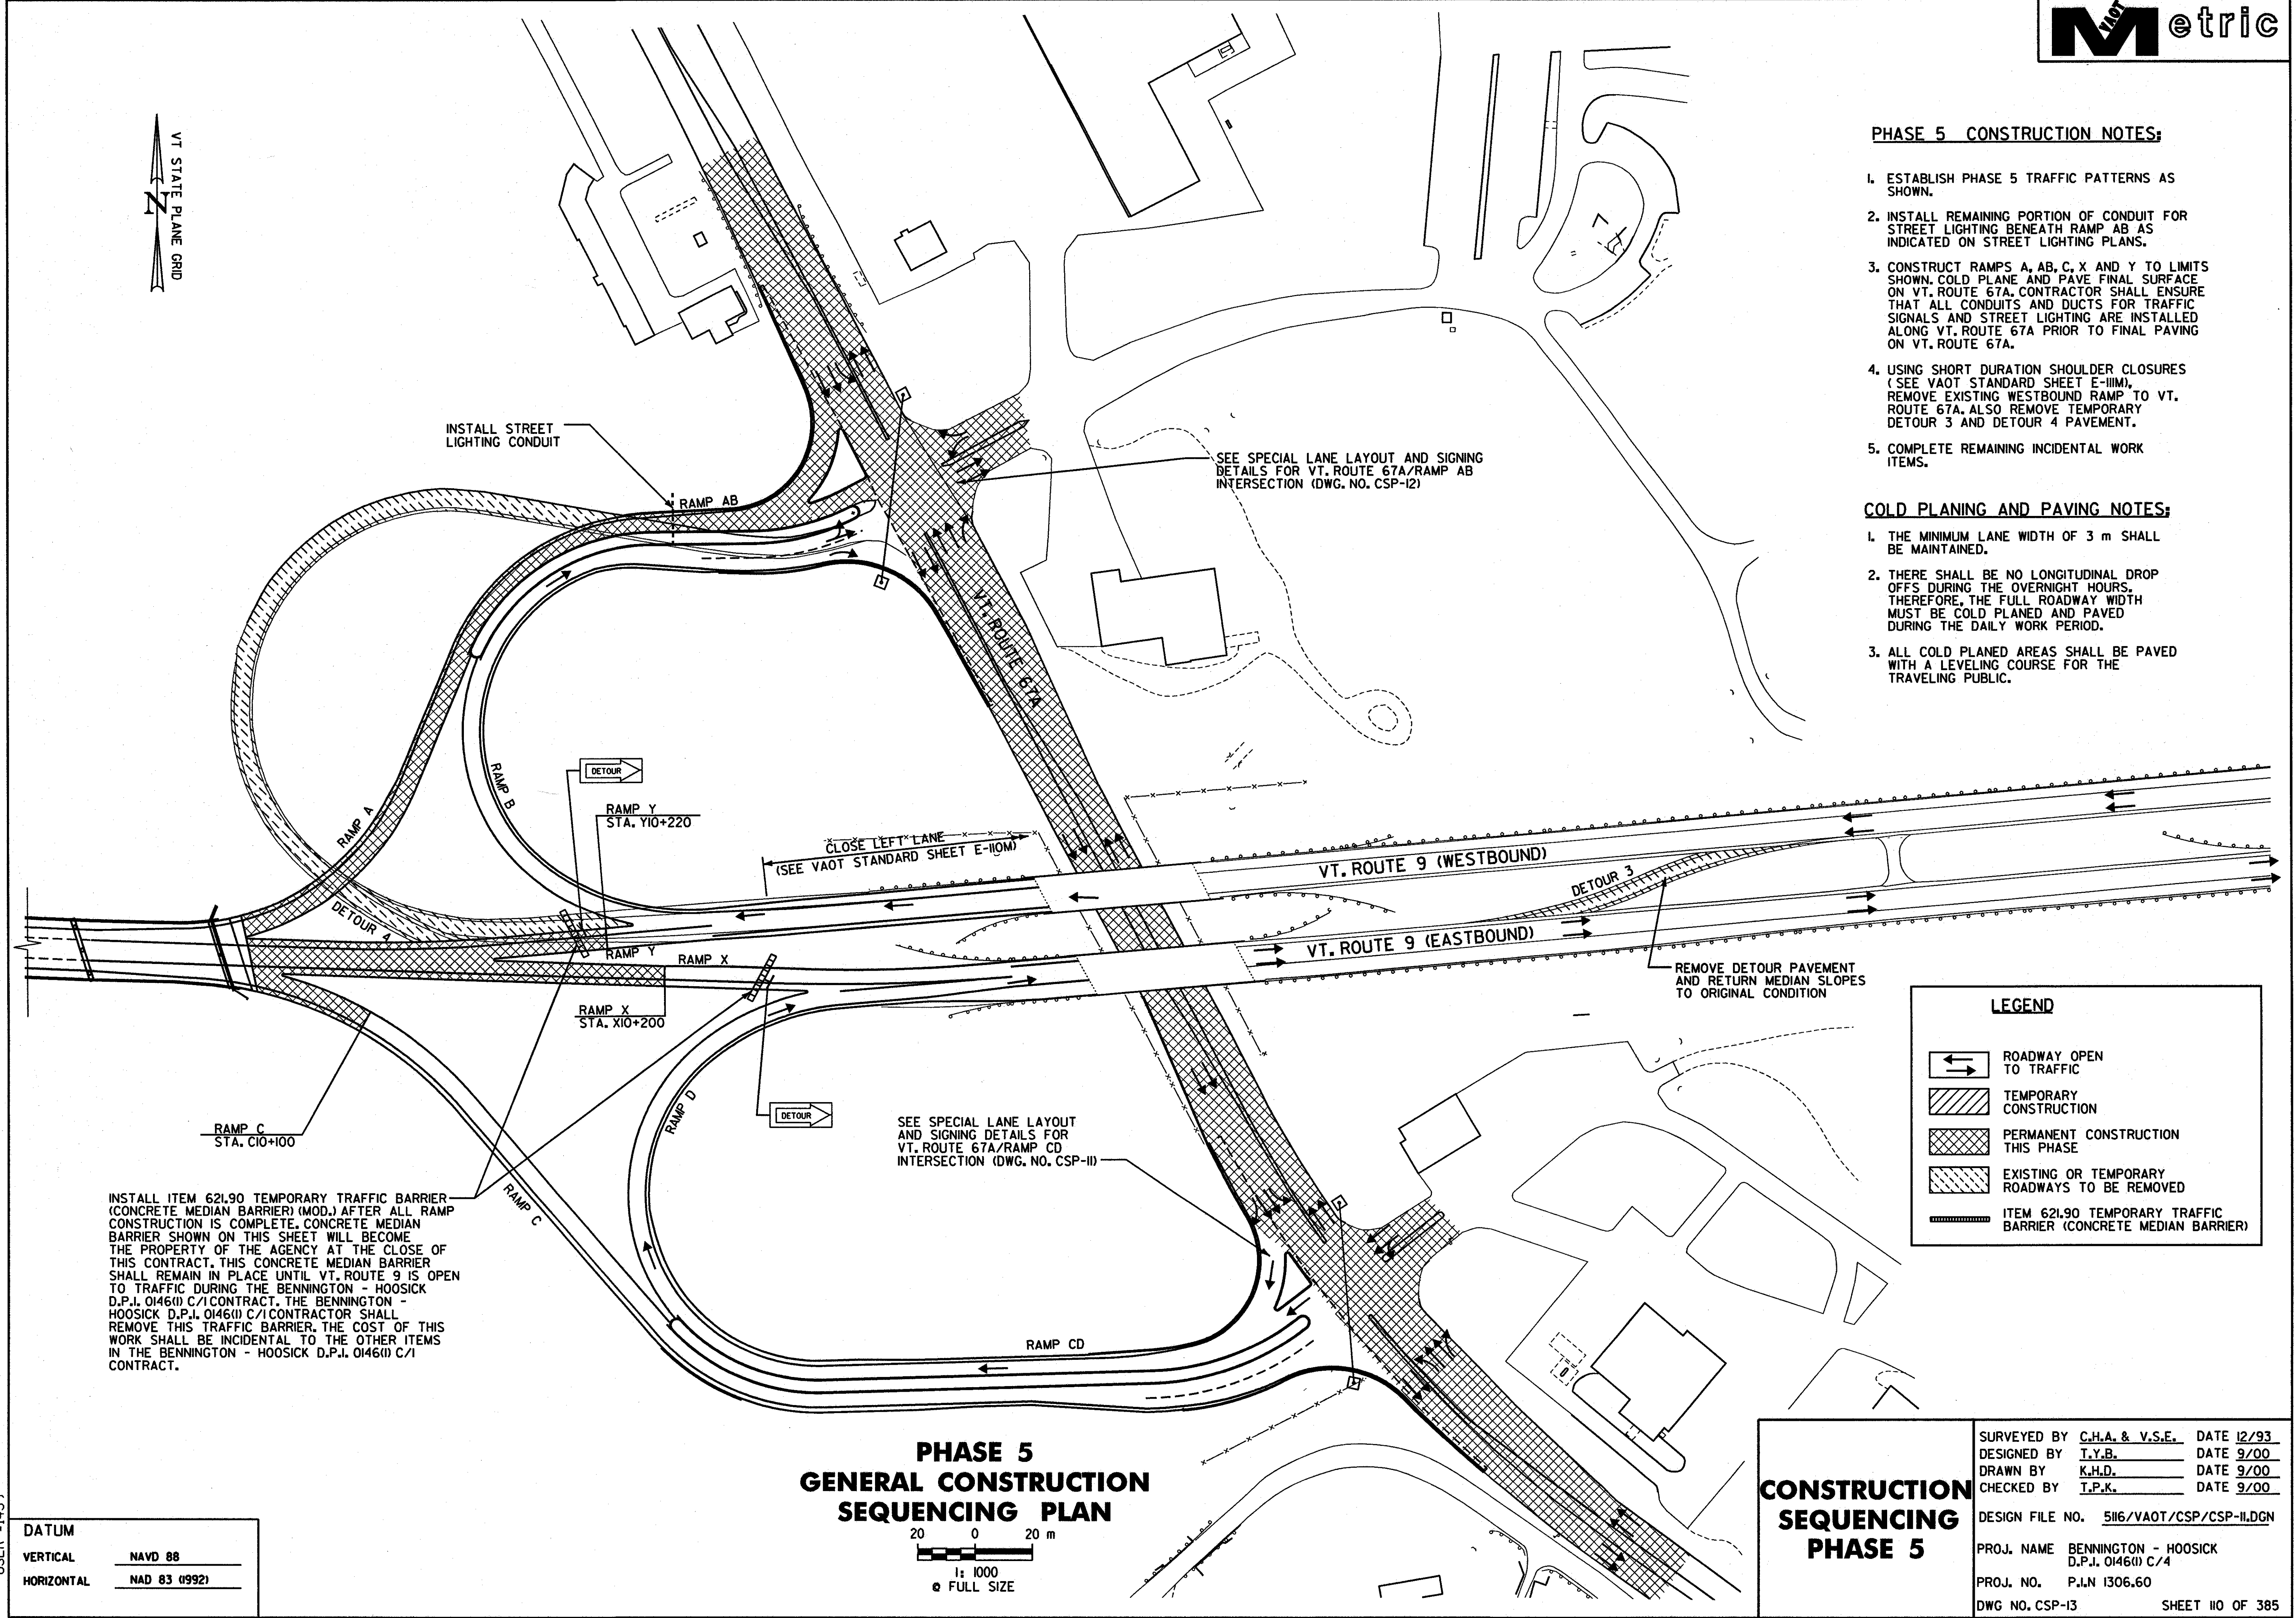


**LEGEND**

- ROADWAY OPEN TO TRAFFIC
- TEMPORARY CONSTRUCTION
- PERMANENT CONSTRUCTION THIS PHASE
- EXISTING OR TEMPORARY ROADWAYS TO BE REMOVED
- ITEM 621.90 TEMPORARY TRAFFIC BARRIER (CONCRETE MEDIAN BARRIER)

INSTALL ITEM 621.90 TEMPORARY TRAFFIC BARRIER (CONCRETE MEDIAN BARRIER) (MOD.) AFTER ALL RAMP CONSTRUCTION IS COMPLETE. CONCRETE MEDIAN BARRIER SHOWN ON THIS SHEET WILL BECOME THE PROPERTY OF THE AGENCY AT THE CLOSE OF THIS CONTRACT. THIS CONCRETE MEDIAN BARRIER SHALL REMAIN IN PLACE UNTIL VT. ROUTE 9 IS OPEN TO TRAFFIC DURING THE BENNINGTON - HOOSICK D.P.J. 0146(I) C/I CONTRACT. THE BENNINGTON - HOOSICK D.P.J. 0146(II) C/I CONTRACTOR SHALL REMOVE THIS TRAFFIC BARRIER. THE COST OF THIS WORK SHALL BE INCIDENTAL TO THE OTHER ITEMS IN THE BENNINGTON - HOOSICK D.P.J. 0146(I) C/I CONTRACT.

**PHASE 5  
GENERAL CONSTRUCTION  
SEQUENCING PLAN**

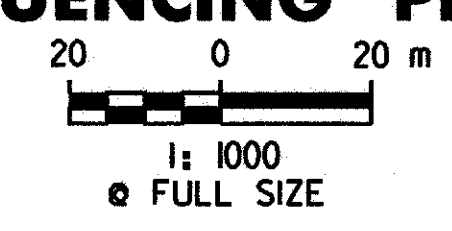

DATUM

VERTICAL	NAVD 88
HORIZONTAL	NAD 83 (1992)

**CONSTRUCTION  
SEQUENCING  
PHASE 5**

SURVEYED BY	C.H.A. & V.S.E.	DATE	12/93
DESIGNED BY	T.Y.B.	DATE	9/00
DRAWN BY	K.H.D.	DATE	9/00
CHECKED BY	T.P.K.	DATE	9/00
DESIGN FILE NO.	5116/VAOT/CSP/CSP-II.DGN		
PROJ. NAME	BENNINGTON - HOOSICK D.P.J. 0146(I) C/4		
PROJ. NO.	P.I.N 1306.60		
DWG NO.	CSP-13	SHEET	110 OF 385

FILE NAME =u:\5116\vaot\contract4\csp\csp-11.dgn  
 DATE/TIME =07 SEP 2000  
 USER =1459