


**U.S. ROUTE 7 STA. 37+08  
END APPROACH**

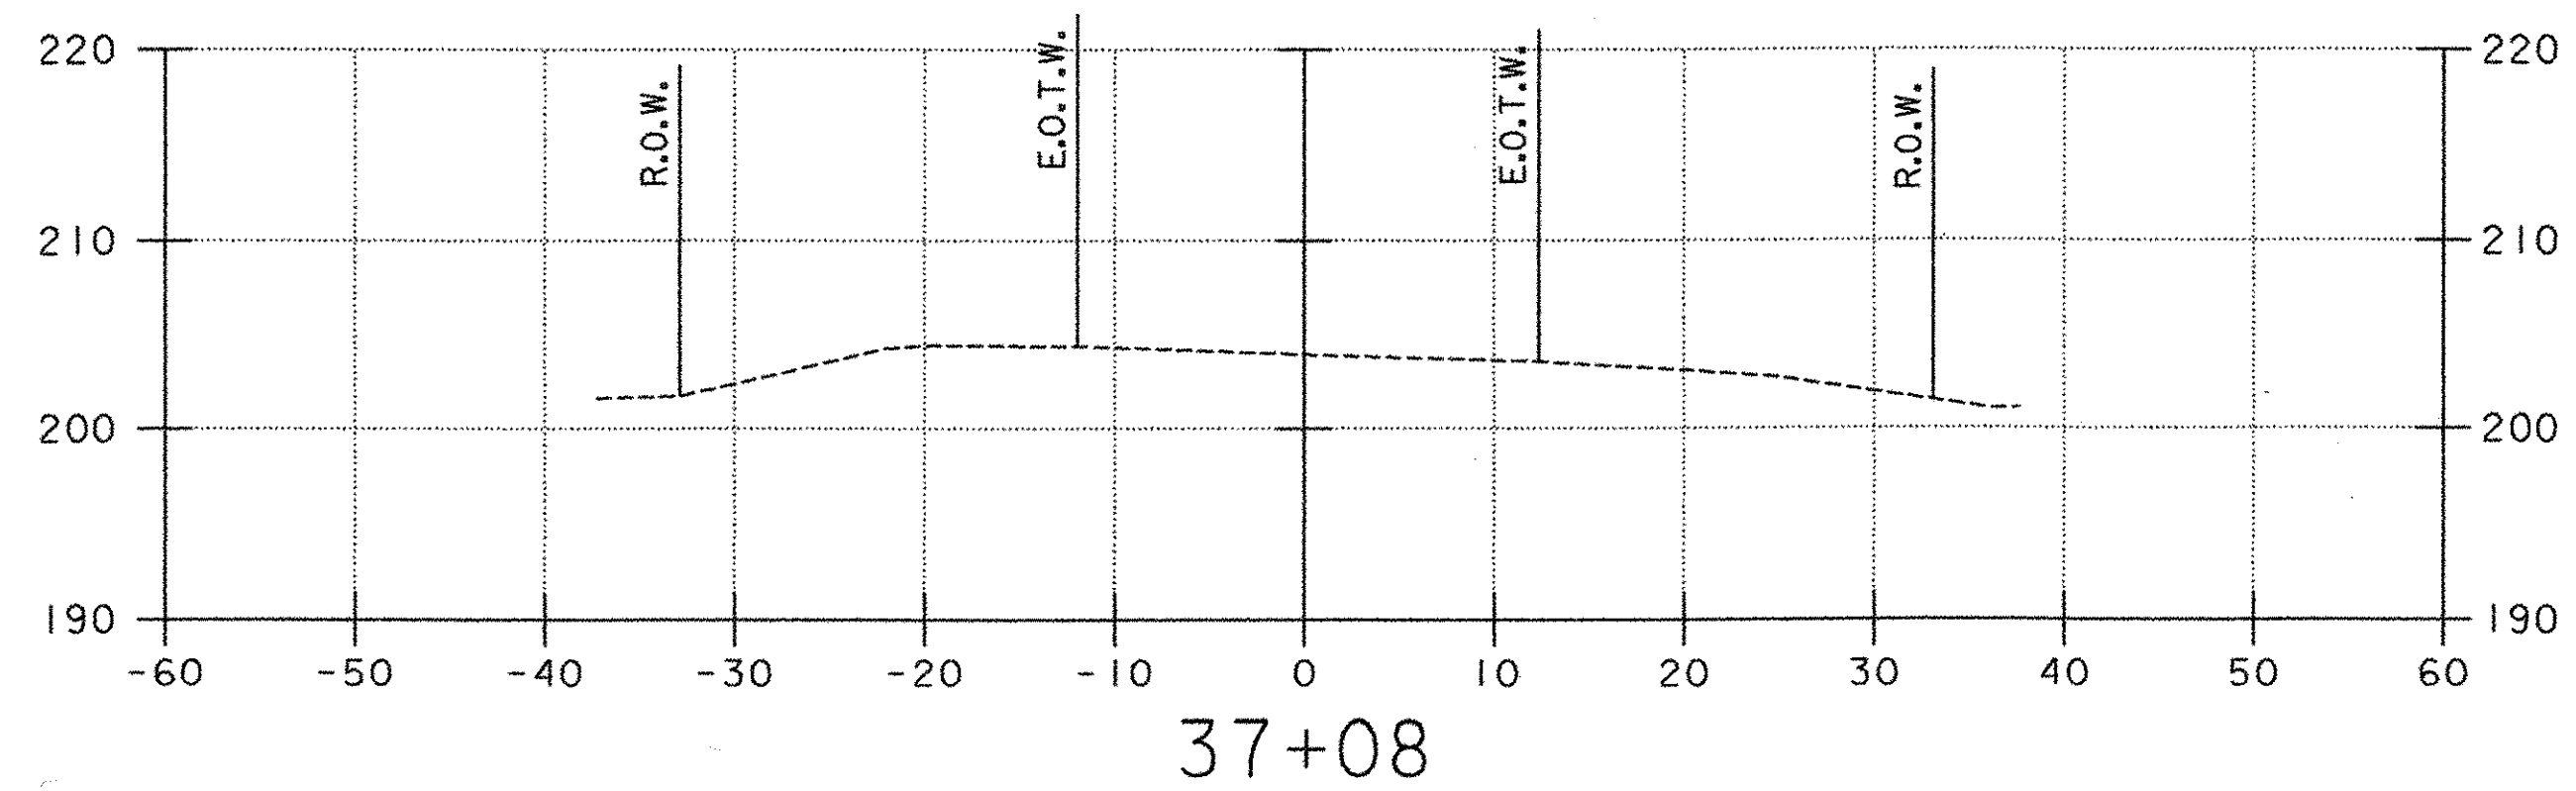

- LEGEND**
- ① PROPOSED UNDERDRAIN  
(SEE DRAINAGE PLAN, SHEET 20)
  - ③ PROPOSED STORMWATER PIPE  
(SEE DRAINAGE PLAN, SHEET 20)
  - Ⓐ PROPOSED CONDUIT FOR LIGHTING  
(SEE LIGHTING PLAN, SHEET 31)
  - UT EXISTING UNDERGROUND TELEPHONE
  - W EXISTING WATER
  - UD EXISTING UNDERDRAIN
  - G EXISTING GAS

10 FEET H 1"=10'  
 5.0 V 1"=10'  
 5.0 10 FEET @ FULL SIZE



PROJECT NAME: COLCHESTER PARK-AND-RIDE  
 PROJECT NUMBER: CMG PARK(18)S  
 FILE NAME: zk062xsl.dgn  
 PROJECT LEADER: CSP  
 DESIGNED BY: DH  
 U.S. ROUTE 7 - CROSS SECTION

PLOT DATE: 07/08/02  
 DRAWN BY: MAM  
 CHECKED BY: GAE  
 SHEET 56 OF 56

139-367-SECTION-01 07/08/02 12:13:39 PM