



at locations which may be in the immediate vicinity of underground utilities.

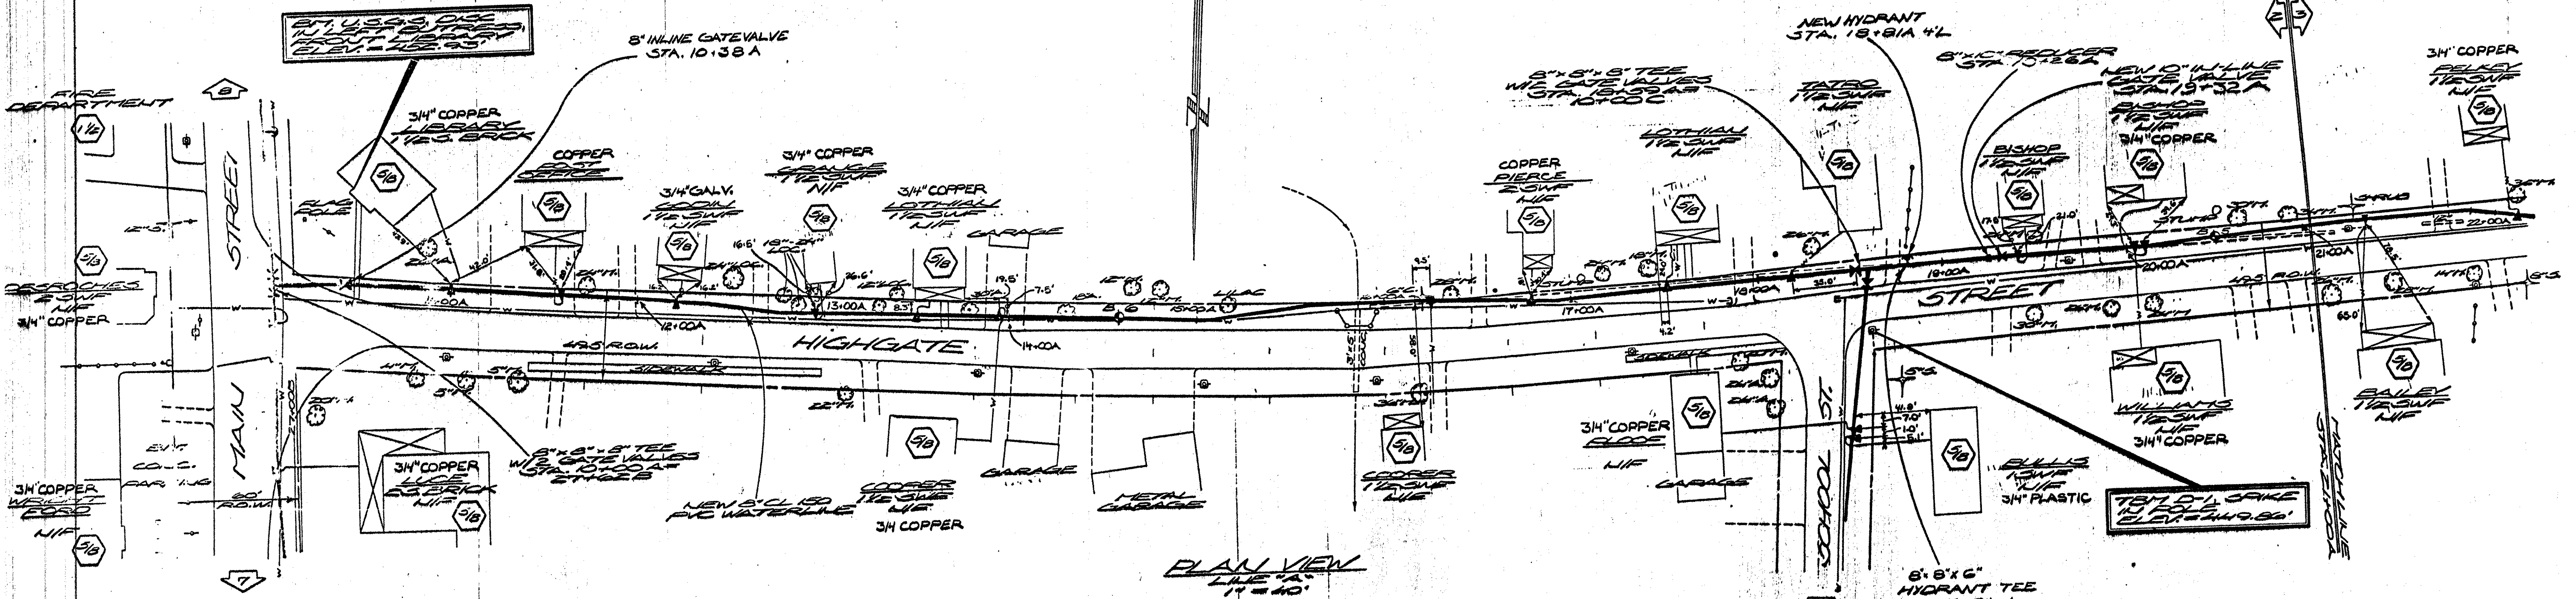


PLAN VIEW
LINE "A"
1"=40'

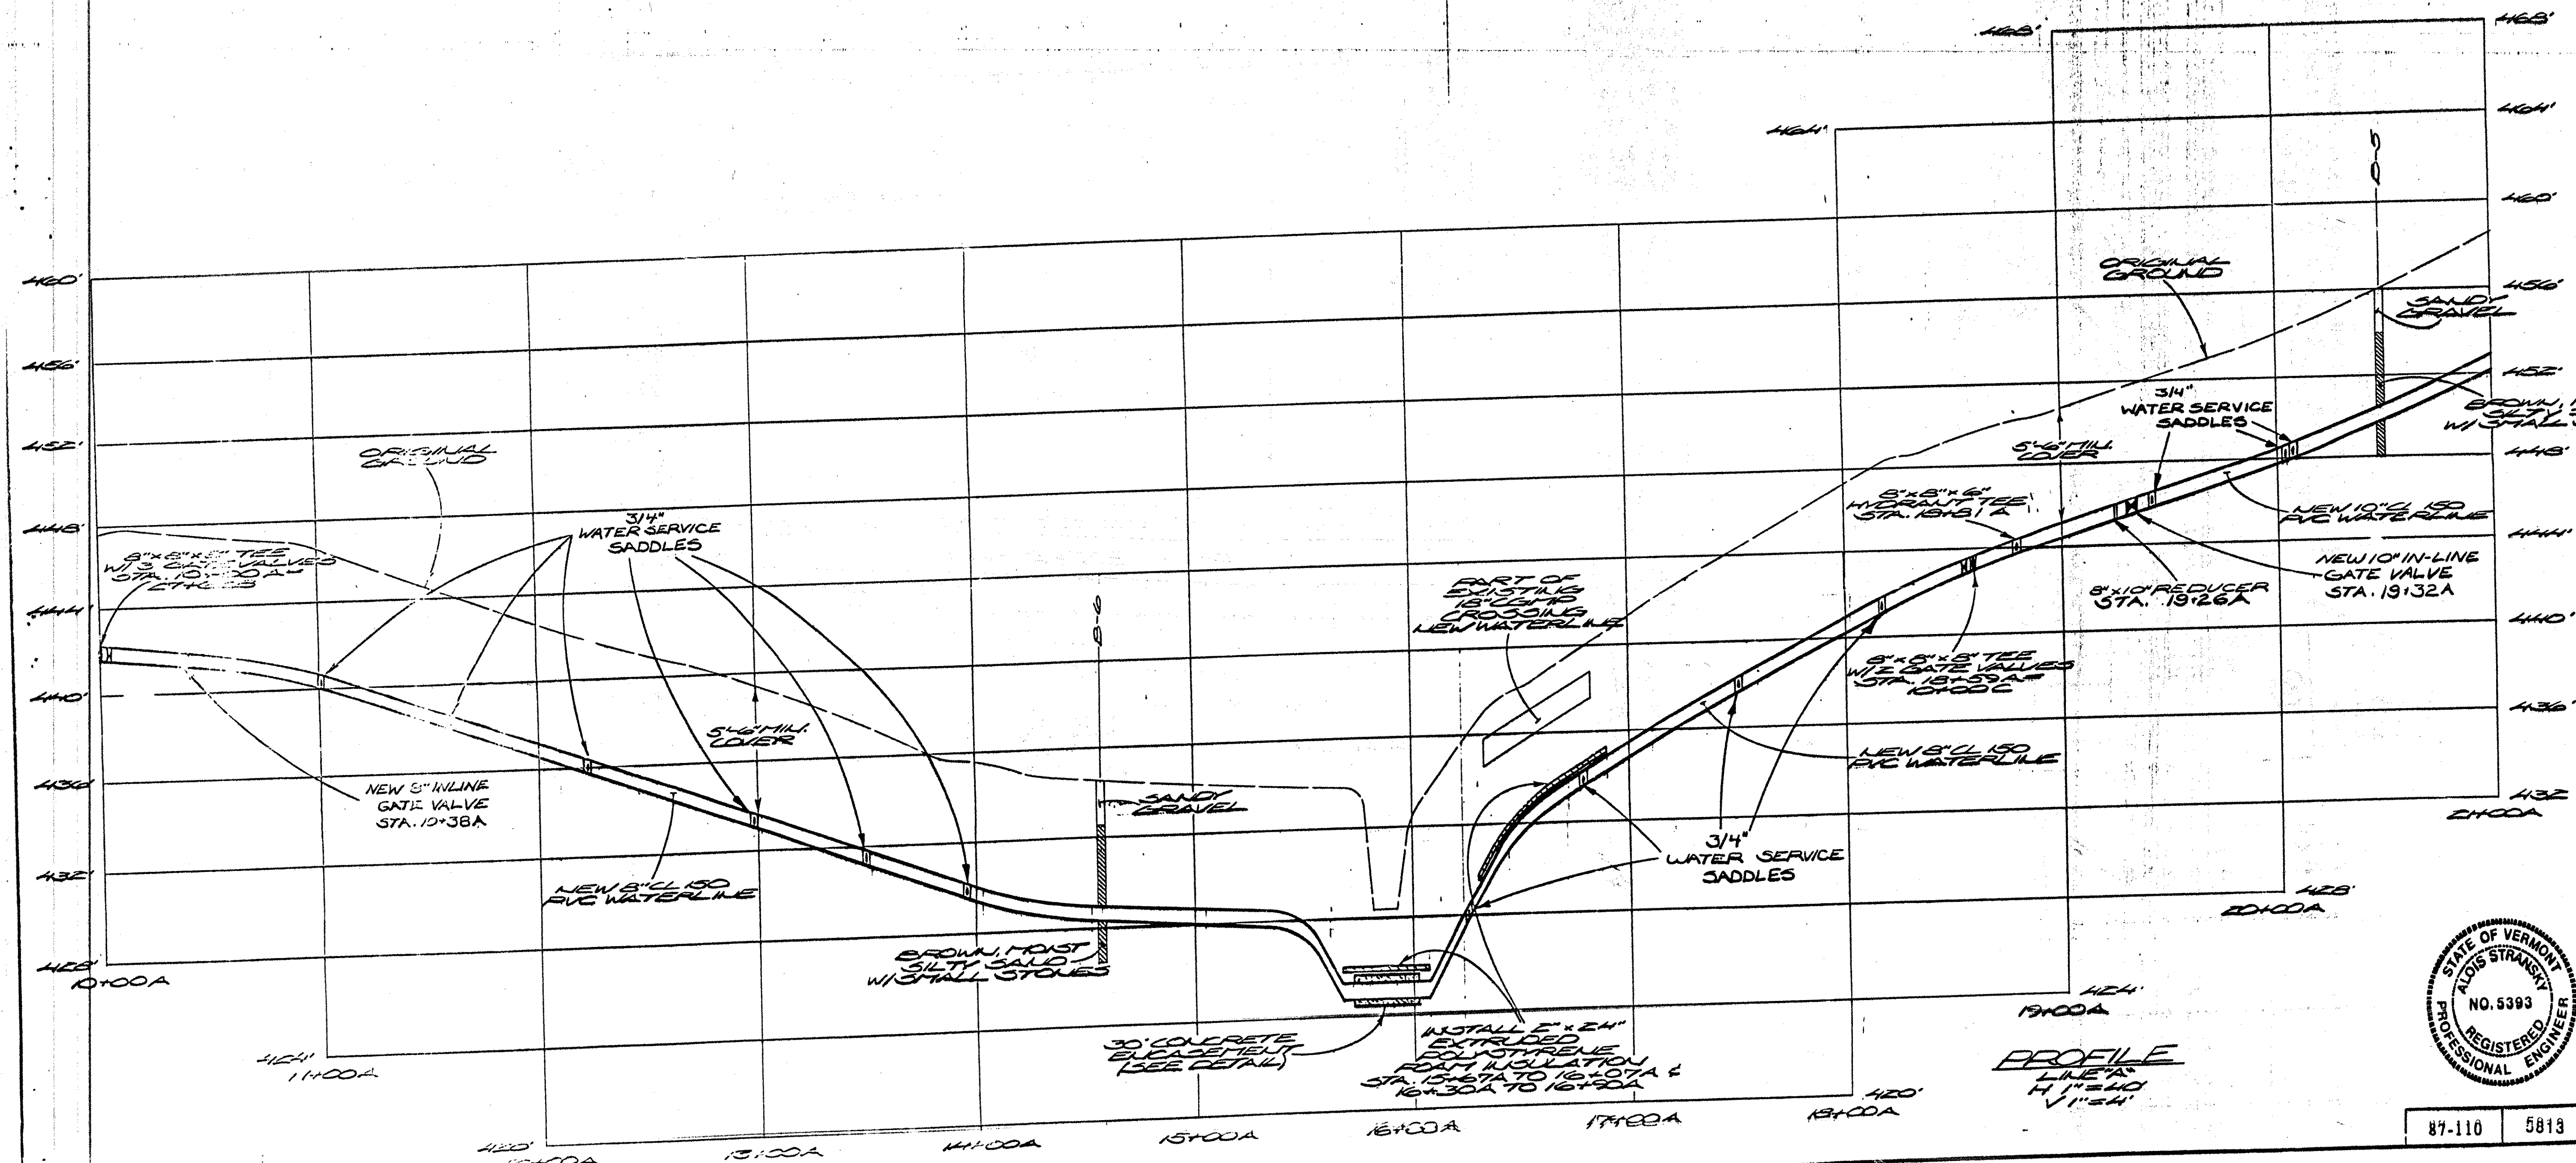

PROFILE
LINE "A"
1"=40'

RECORD DRAWING
FEBRUARY 1990

DATE	2/20/90	RECORD DRAWING	TCR
DATE	7/6/88	REVISION ADDED GATE VALVE STA. 18+95A	BY AS
FRANKLIN FIRE DISTRICT No. 1 FRANKLIN, VERMONT			
PLAN and PROFILE 10 + 00A to 21 + 00A			
SURVEY	MRM	DESIGN	AS
DRAWN	JRD	CHECKED	AS/MCW
		SCALE SHOWN DATE 5/24/88 DRW. NO. 2 of 20 57 OF 60	
CONSULTING ENGINEERS, INC. Essex Junction, Vermont		87-110	5813