

NO.	DATE	DESCRIPTION	ZDC	BY	CK'D
1	10/09/2013	ELECTRICAL SITE PLAN			

TOWN OF
WAITSFIELD
9 BRIDGE STREET
WAITSFIELD, VT

VILLAGE COVERED
BRIDGE REHAB. &
BRIDGE STREET
STORMWATER
IMPROVEMENTS

SHEET TITLE

PROPOSED
ELECTRICAL SITE
PLAN

DRAWN BY	DATE
ZDC	MAY 2014
CHECKED BY	D&K PROJECT #
HLV	121447
PROJ. ENG.	D&K ARCHIVE #
HLV	



SHEET NUMBER

30

SHEET 30 OF 30

LEGEND

690	CONTOUR
SD	STORMDRAIN
W	WATER MAIN
	FENCELINE
	OVERHEAD POWER
	EDGE OF WATER
	APPROXIMATE RIGHT OF WAY
	STRUCTURE
△	SURVEY CONTROL POINT
⊕	BENCHMARK
⊗	HYDRANT
⊕	WATER SHUTOFF
■	CATCHBASIN
+	SIGN
⊙	WELL
⊕	UTILITY POLE
— UGP —	UNDERGROUND POWER
— UGT —	UNDERGROUND TELECOMMUNICATION
—	STUB FOR FUTURE CONNECTION

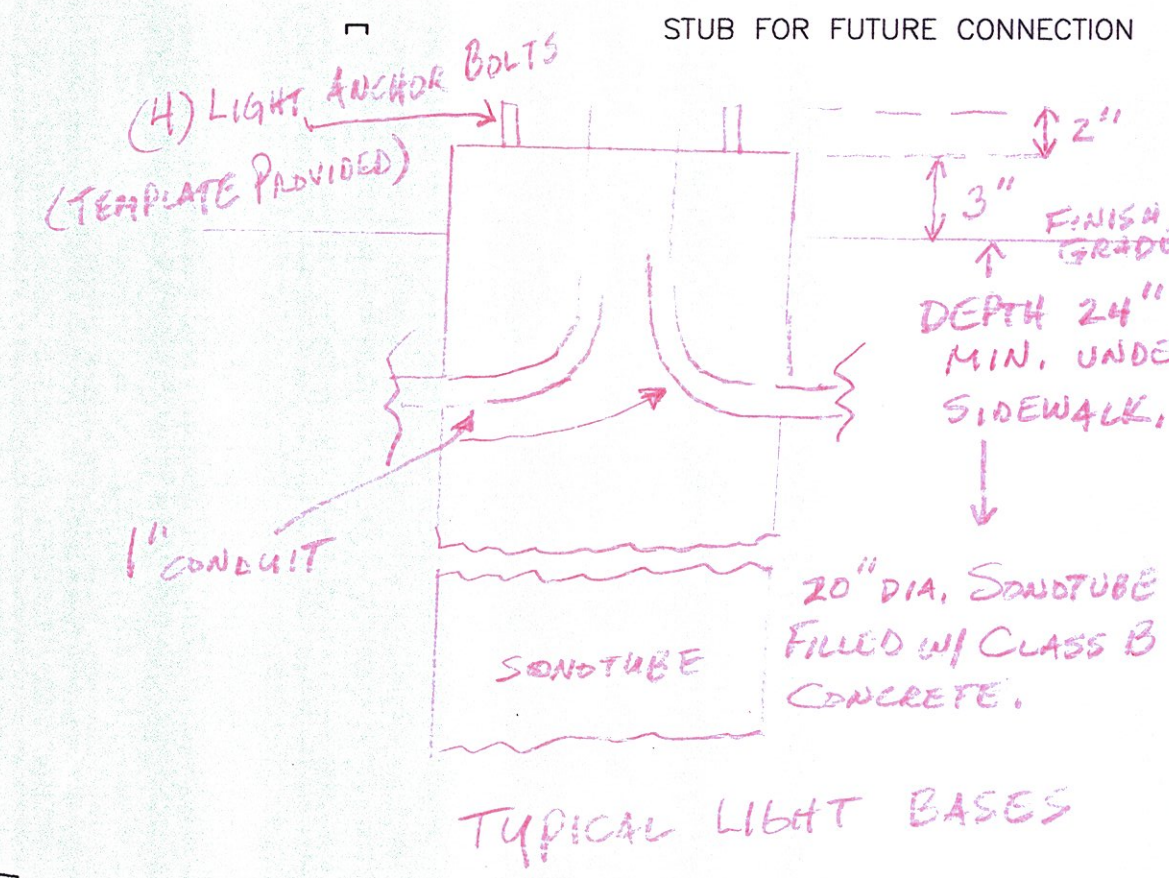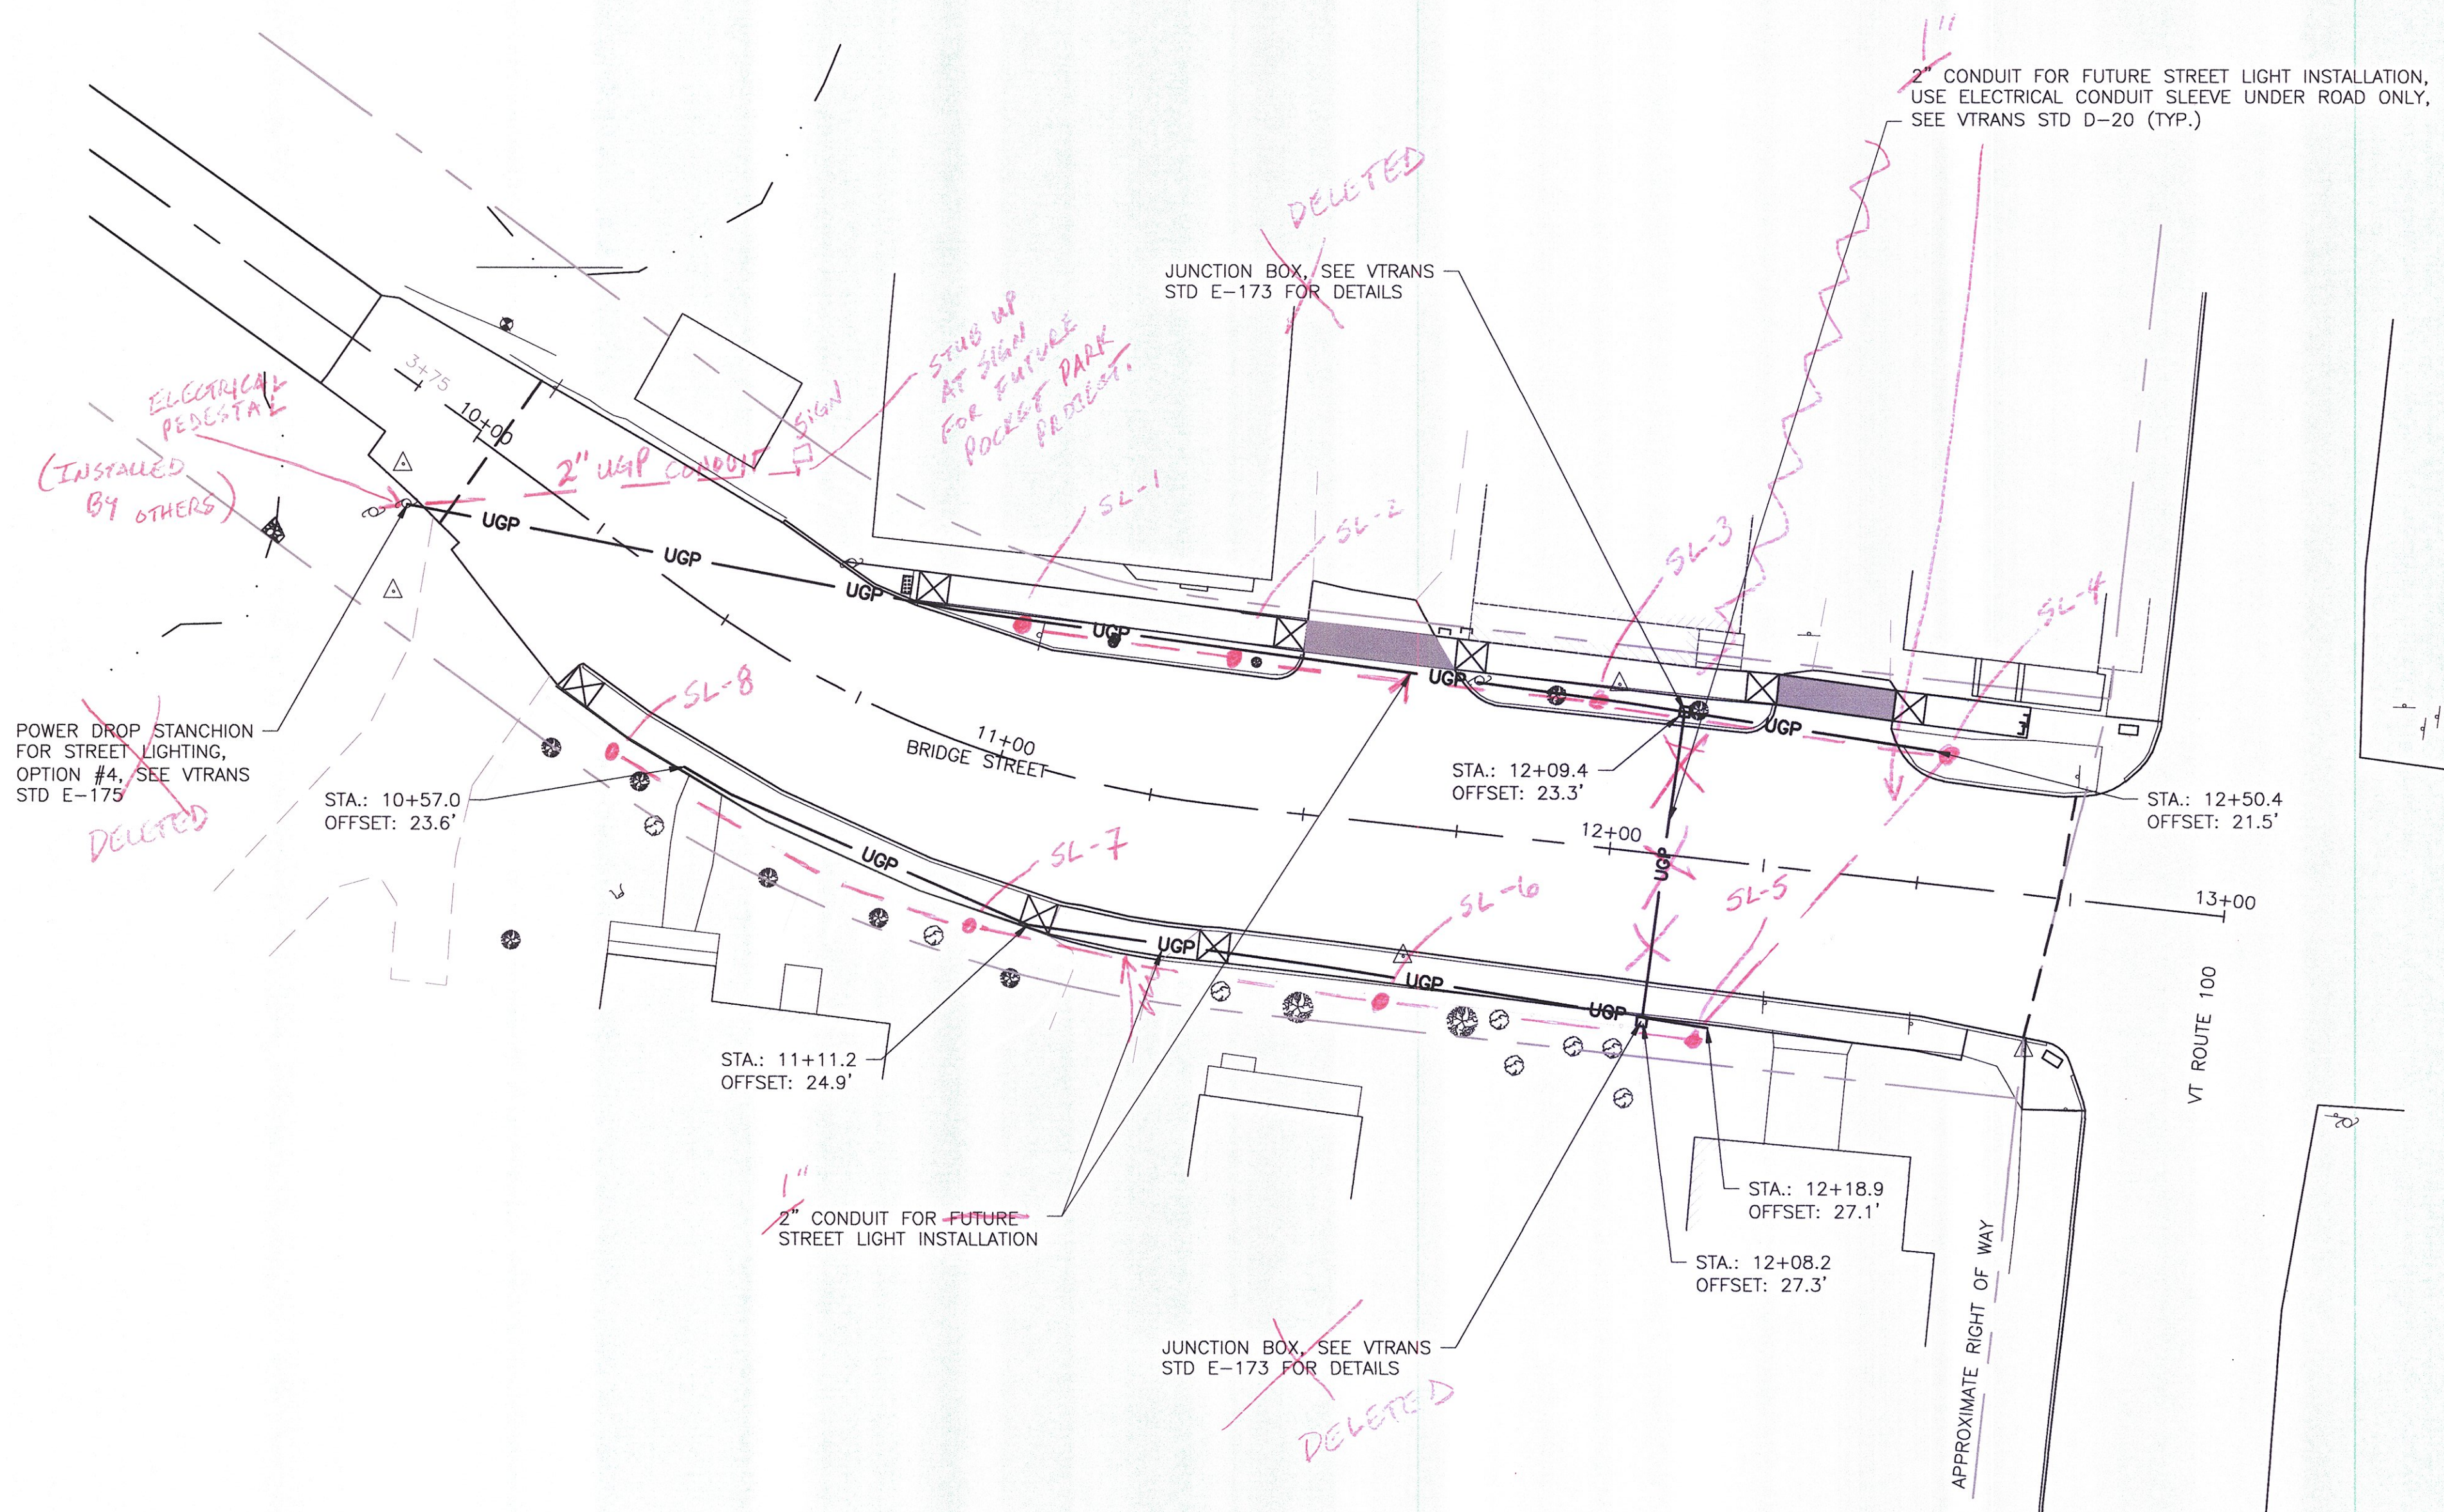

• STREET LAMP BASES w/
REBAR REINFORCED CONCRETE
BASES INSTALLED.
- LAMPS AND WIRING
INSTALLED BY OTHERS.

Ch...
12/2015

NOTE:
1. UNDERGROUND CONDUIT TO BE INSTALLED IN ACCORDANCE WITH VTRANS
STANDARD DETAILS E-175 AND D-20.

PROPOSED ELECTRICAL SITE PLAN

