

LEGEND


	tree line/hedge row
	1 foot contour
	5 foot contour
	underground electric
	underground telephone
	water line
	storm drain
	sanitary sewer
	fence
	tele. mh
	trash can
	bench
	flag pole
	monument found
	catch basin
	utility pole
	guy wire
	sanitary sewer manhole
	drainage manhole
	tree (type & size noted)
	bush
	light pole base
	light pole
	utility pole with light
	sign
	gate valve
	curb stop
	fire hydrant

EXISTING LIGHT POLE DESIGNATIONS: W - WOOD POLE
M - METAL POLE
1 - LIGHT ONLY
2 - POLE WITH TRANSFORMER
3 - POWER WITH LIGHT
4 - POWER ONLY

RECORD DRAWING

Record drawings have been prepared, in part, on the basis of information compiled and furnished by others. The engineer will not be responsible for any errors or omissions which have been incorporated into this document as a result. The location of items shown without labeled measurements are to be considered as approximate; do not scale the drawing to determine the actual location. All record drawing information is shown in italics.

- GENERAL NOTES:**
1. BASE MAP IS TOWN OF MIDDLEBURY UTILITY MAPS.
 2. TOWN GREEN AND TRIANGLE PARK AREA TOPOGRAPHIC INFORMATION FROM AN UNDATED PLAN FROM OTTER CREEK ENG.
 3. THIS IS NOT A BOUNDARY SURVEY.
 4. ELEVATIONS ARE BASED ON N.G.V.D. 29 DATUM. HORIZONTAL POSITIONS ARE BASED ON AN ARBITRARY COORDINATE SYSTEM.
 5. THE LOCATION OF EXISTING UNDERGROUND UTILITIES ARE SHOWN IN AN APPROXIMATE WAY ONLY AND HAVE NOT BEEN INDEPENDENTLY VERIFIED BY THE OWNER OR ITS REPRESENTATIVE.
 6. THE CONTRACTOR SHALL DETERMINE THE EXACT LOCATION OF ALL EXISTING UTILITIES BEFORE COMMENCING WORK, AND AGREES TO BE FULLY RESPONSIBLE FOR ANY AND ALL DAMAGES WHICH MIGHT BE OCCASIONED BY THE CONTRACTOR'S FAILURE TO EXACTLY LOCATE AND PRESERVE ANY AND ALL UNDERGROUND UTILITIES.
 7. CONTRACTORS SHALL COORDINATE WITH DIG-SAFE (1-888-344-7233) A MINIMUM OF 48 HOURS PRIOR TO ANY EXCAVATION. DIG-SAFE SHALL BE NOTIFIED "FOR EXCAVATION ACTIVITIES CONDUCTED WITHIN 100 FEET OF AN UNDERGROUND UTILITY FACILITY." CONTRACTOR SHALL "PREMARK PROPOSED EXCAVATION AREAS BEFORE CALLING DIG-SAFE."

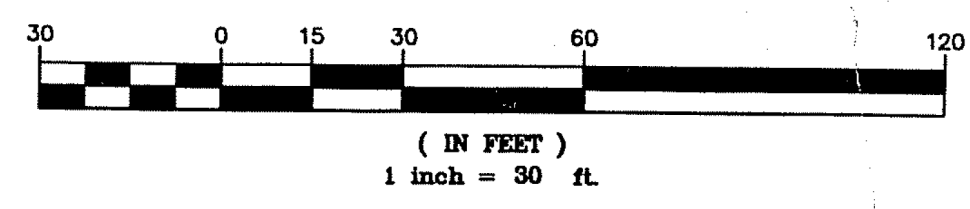

REVISIONS

STATE OF VERMONT
Professional Engineer
No. 7704
J. S. D. P.

THE DRAWINGS FOR THIS PROJECT SHALL NOT BE REUSED OR ALTERED IN ANY WAY WITHOUT THE WRITTEN APPROVAL AND AUTHORITY OF THE ENGINEER. ANY REVISIONS SHALL BE MADE BY THE ENGINEER AND NOTED IN THE REVISION BLOCK.

PHELPS ENGINEERING, INC.
3 MILL HOLLOW MILL
3 Mill St., P.O. Box 367
Middlebury, Vt. 05753
Telephone (802) 388-7829

SCALE: 1" = 30'
DATE: 12/6/04
DR. BY: JS/DP
CK'D BY: JK
SHEET NO. 1R OF 3R
DWG. NO. 200403-1R

TOWN OF MIDDLEBURY
VILLAGE AREA
HISTORICAL LIGHTING PLAN
MIDDLEBURY, VERMONT
PROPOSED GENERAL PLAN