
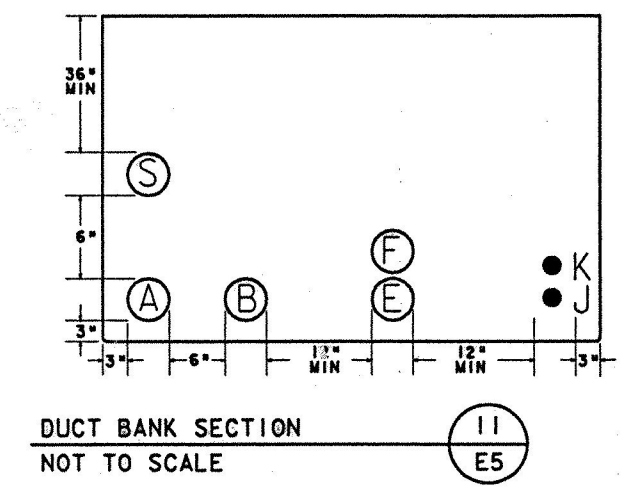


SITE PLAN  
1"=20'

NOTE:  
BENNINGTON MONUMENT AND BENNINGTON MONUMENT STREET LIGHTS ELECTRIC SERVICE METER TO BE BILLED TO VERMONT STATE DIVISION FOR HISTORIC PRESERVATION.

DUCT BANK SCHEDULE				
DUCT BANK SECTION NO.	CONDUIT	FUNCTION	FROM	TO
10	A 4"	3Ø PRIMARY ELECTRIC HOUSE SERVICE ELECTRIC	TERMINAL CABINET, TC-2 HOUSE NO.8	T-5
	C 3"			T-4
	E 4"	TELEPHONE - DISTRIBUTION TELEPHONE - HOUSE SERVICE	TP-2 HOUSE NO.8	TP-4
	F 2"			TP-4
11	J C/C CABLE	CATV - DISTRIBUTION	TERMINAL CABINET, TC-2 T-4	T-5
	K C/C CABLE			CP-2 HOUSE NO. 8
	A 4"	3Ø PRIMARY ELECTRIC	TERMINAL CABINET, TC-2 T-4	TP-5
				B 3"
E 4"	TELEPHONE - DISTRIBUTION TELEPHONE - HOUSE SERVICE	TP-4	CP-4	END OF VAOT CONTRACT LINE (SEE E5 FOR CONTINUATION OUTSIDE OF VAOT CONTRACT)
F 2"				HOUSE NO.9
J C/C CABLE	CATV - HOUSE SERVICE	CP-4	SL-6	BENNINGTON MONUMENT STREET LIGHTS ELECTRIC SERVICE
				S 2"

- NOTES:
- SEE RISER DIAGRAMS, SHEET E7, FOR CONDUIT/CABLE SYSTEMS.
  - ELECTRIC PRIMARY CABLES TO BE INSTALLED BY CENTRAL VERMONT PUBLIC SERVICE (CVPS).
  - TELEPHONE CABLES TO BE INSTALLED BY BELL ATLANTIC.
  - CATV AND FIBER OPTIC CABLES TO BE INSTALLED BY ADELPHIA CABLE COMMUNICATION CO. C/C CABLE IS A DIRECT BURIAL CABLE.

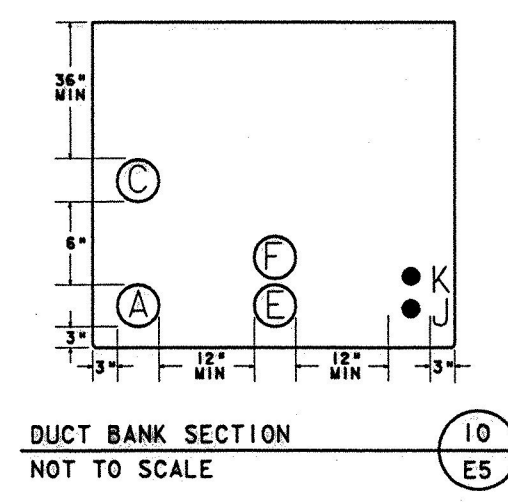

Dufresne-Henry, Inc.  
Consulting Engineers  
North Springfield, Vermont  
Tel: (802) 886-2551 • Fax: (802) 886-2550 • www.d-hinc.com

Rev.	Date	Description
1	JULY/98	GENERAL REVISIONS

VERMONT

OLD BENNINGTON

**MONUMENT CIRCLE DRIVE SECTION**

BENNINGTON

Project No.	28600018
Proj. Manager	R.F. KISCHIKO
Proj. Designer	L.A. BLACK
Drawn By	R. PREBLE
Checked By	R.F. KISCHIKO
Scale	AS SHOWN
Approved	
Date	MARCH 1998

E5

Sheet 27 of 63  
D 6170051