



PLAN
SCALE: 1"=20'

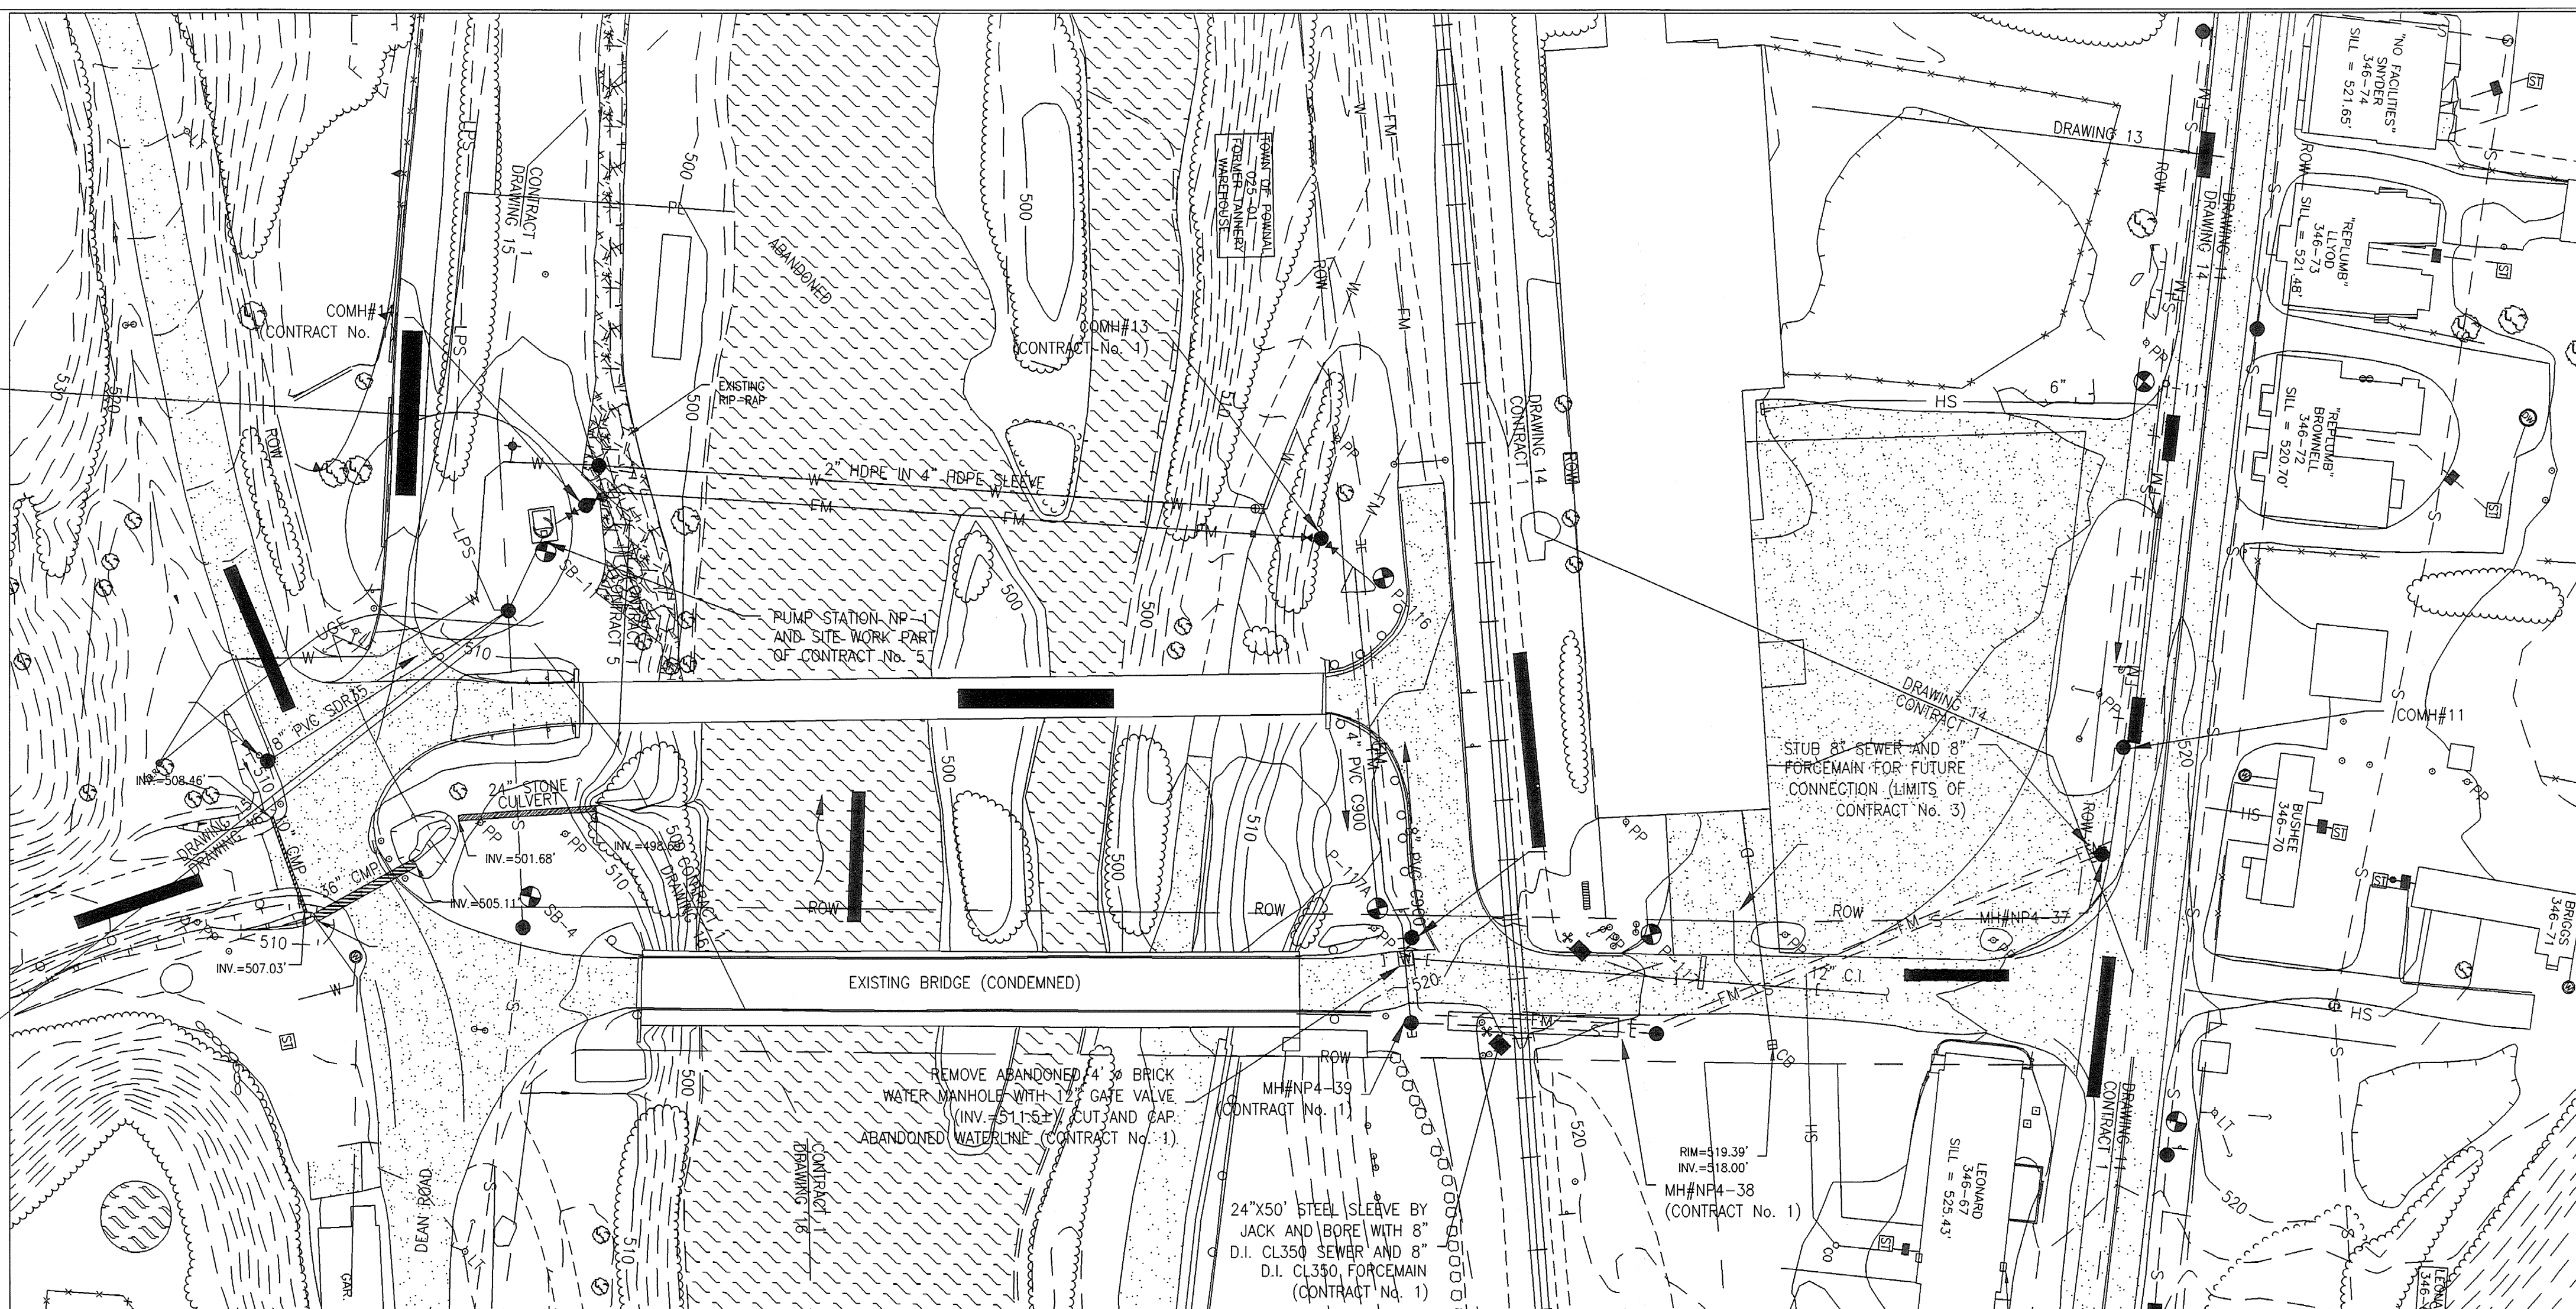

PLAN
SCALE: 1"=40'

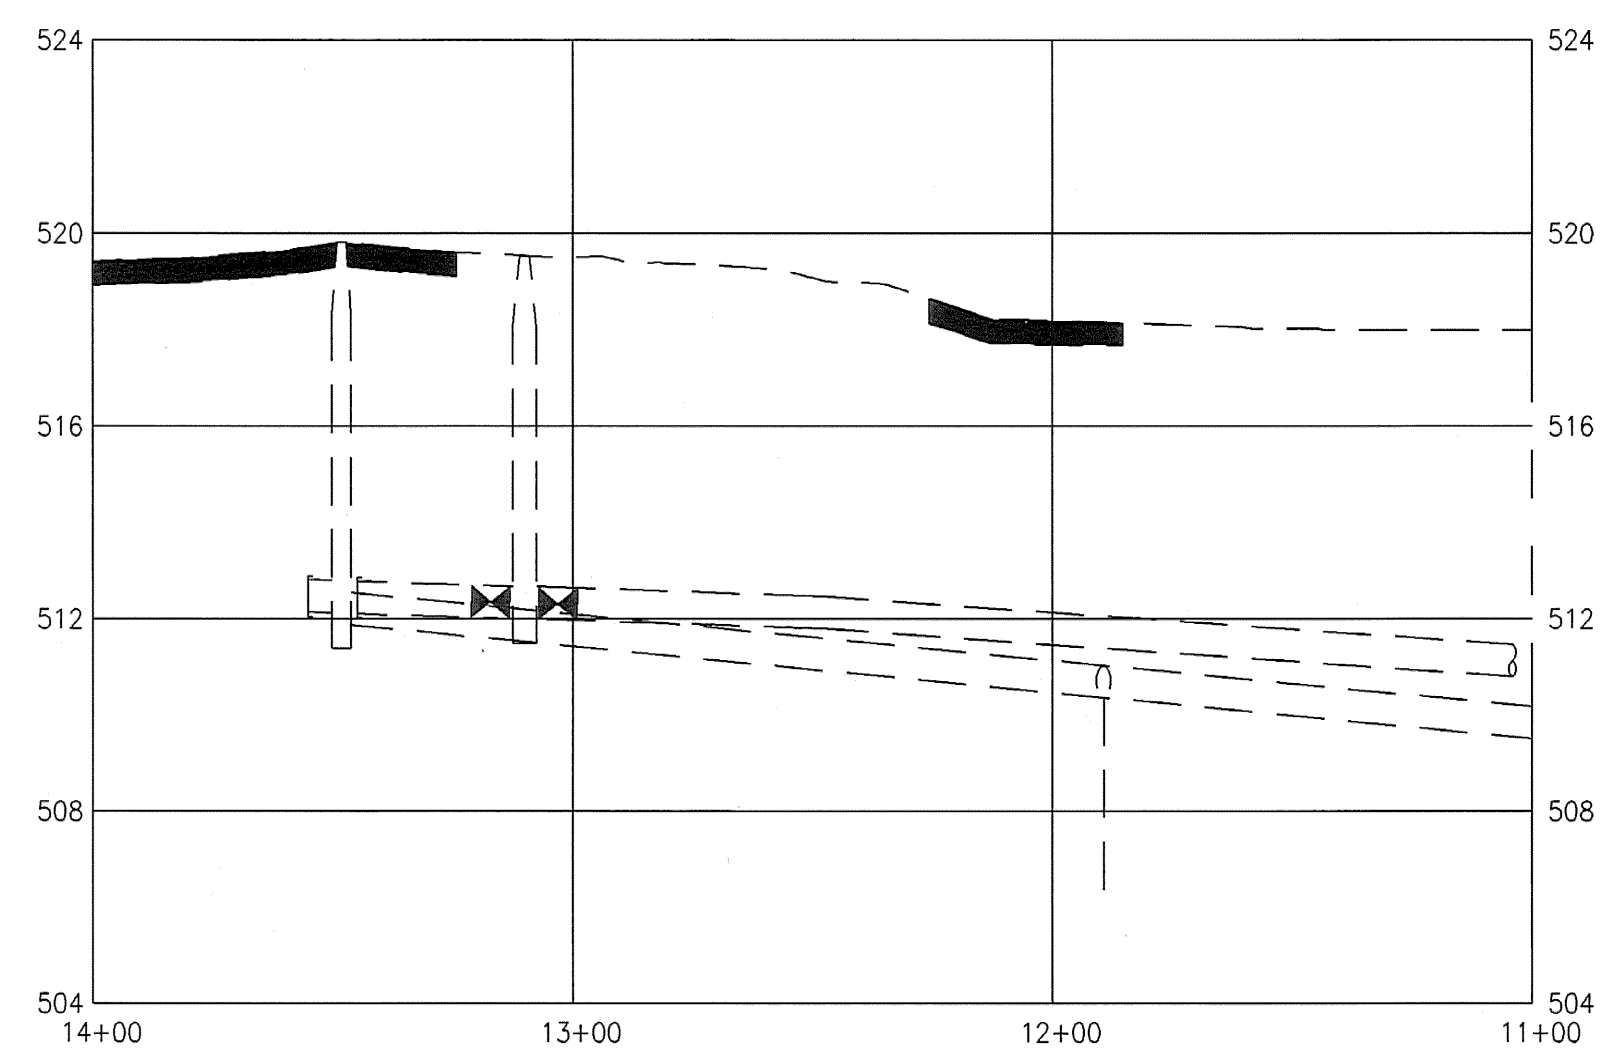

PROFILE
SCALE: HORIZ.=1"=40'
VERT.=1"=4'

POWNAI
BRZ 1441 (19) C/2
EXISTING WATER AND SEWER
SHEET 90A OF 108

RECORD
DRAWING

THE RECORD DRAWING INFORMATION FOR THIS PROJECT IS AS PROVIDED BY THE CONTRACTOR AND IS COMPILED FOR RECORD PURPOSES. THERE IS NO GUARANTEE OF ACCURACY.

| | | | |
|--|-----|--|-----------|
| | | Forcier Aldrich & Associates Consulting Engineers 6 Market Place, Suite 2 Essex Junction, VT 05452 (802) 879-7733 (802) 879-1742 (Fax) | |
| | | TOWN OF POWNAI POWNAI, VERMONT WASTEWATER COLLECTION SYSTEM NORTH POWNAI SEWER SYSTEM CONTRACT No. 3 AND No. 7 | |
| DESIGNED | JJD | PROJECT NO. | 02008 |
| DRAWN | JEN | DRAWING NO. | 14 |
| CHECKED | DEP | DATE | MAR. 2003 |
| NO. DATE REVISION DESCRIPTION CHECKED | | STA. 11+00 TO 20+45 ROUTE 346 WESTSIDE GRAVITY SEWER AND FORCEMAIN PLAN AND PROFILE | SHEET 17 |