
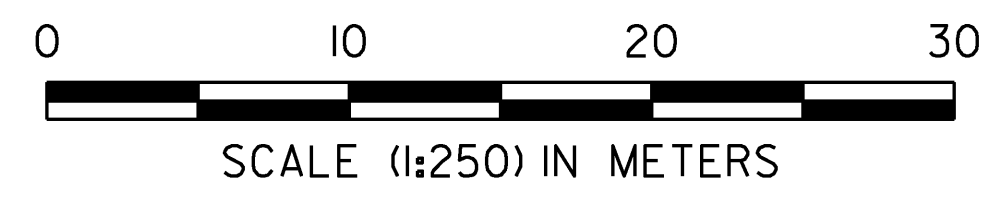
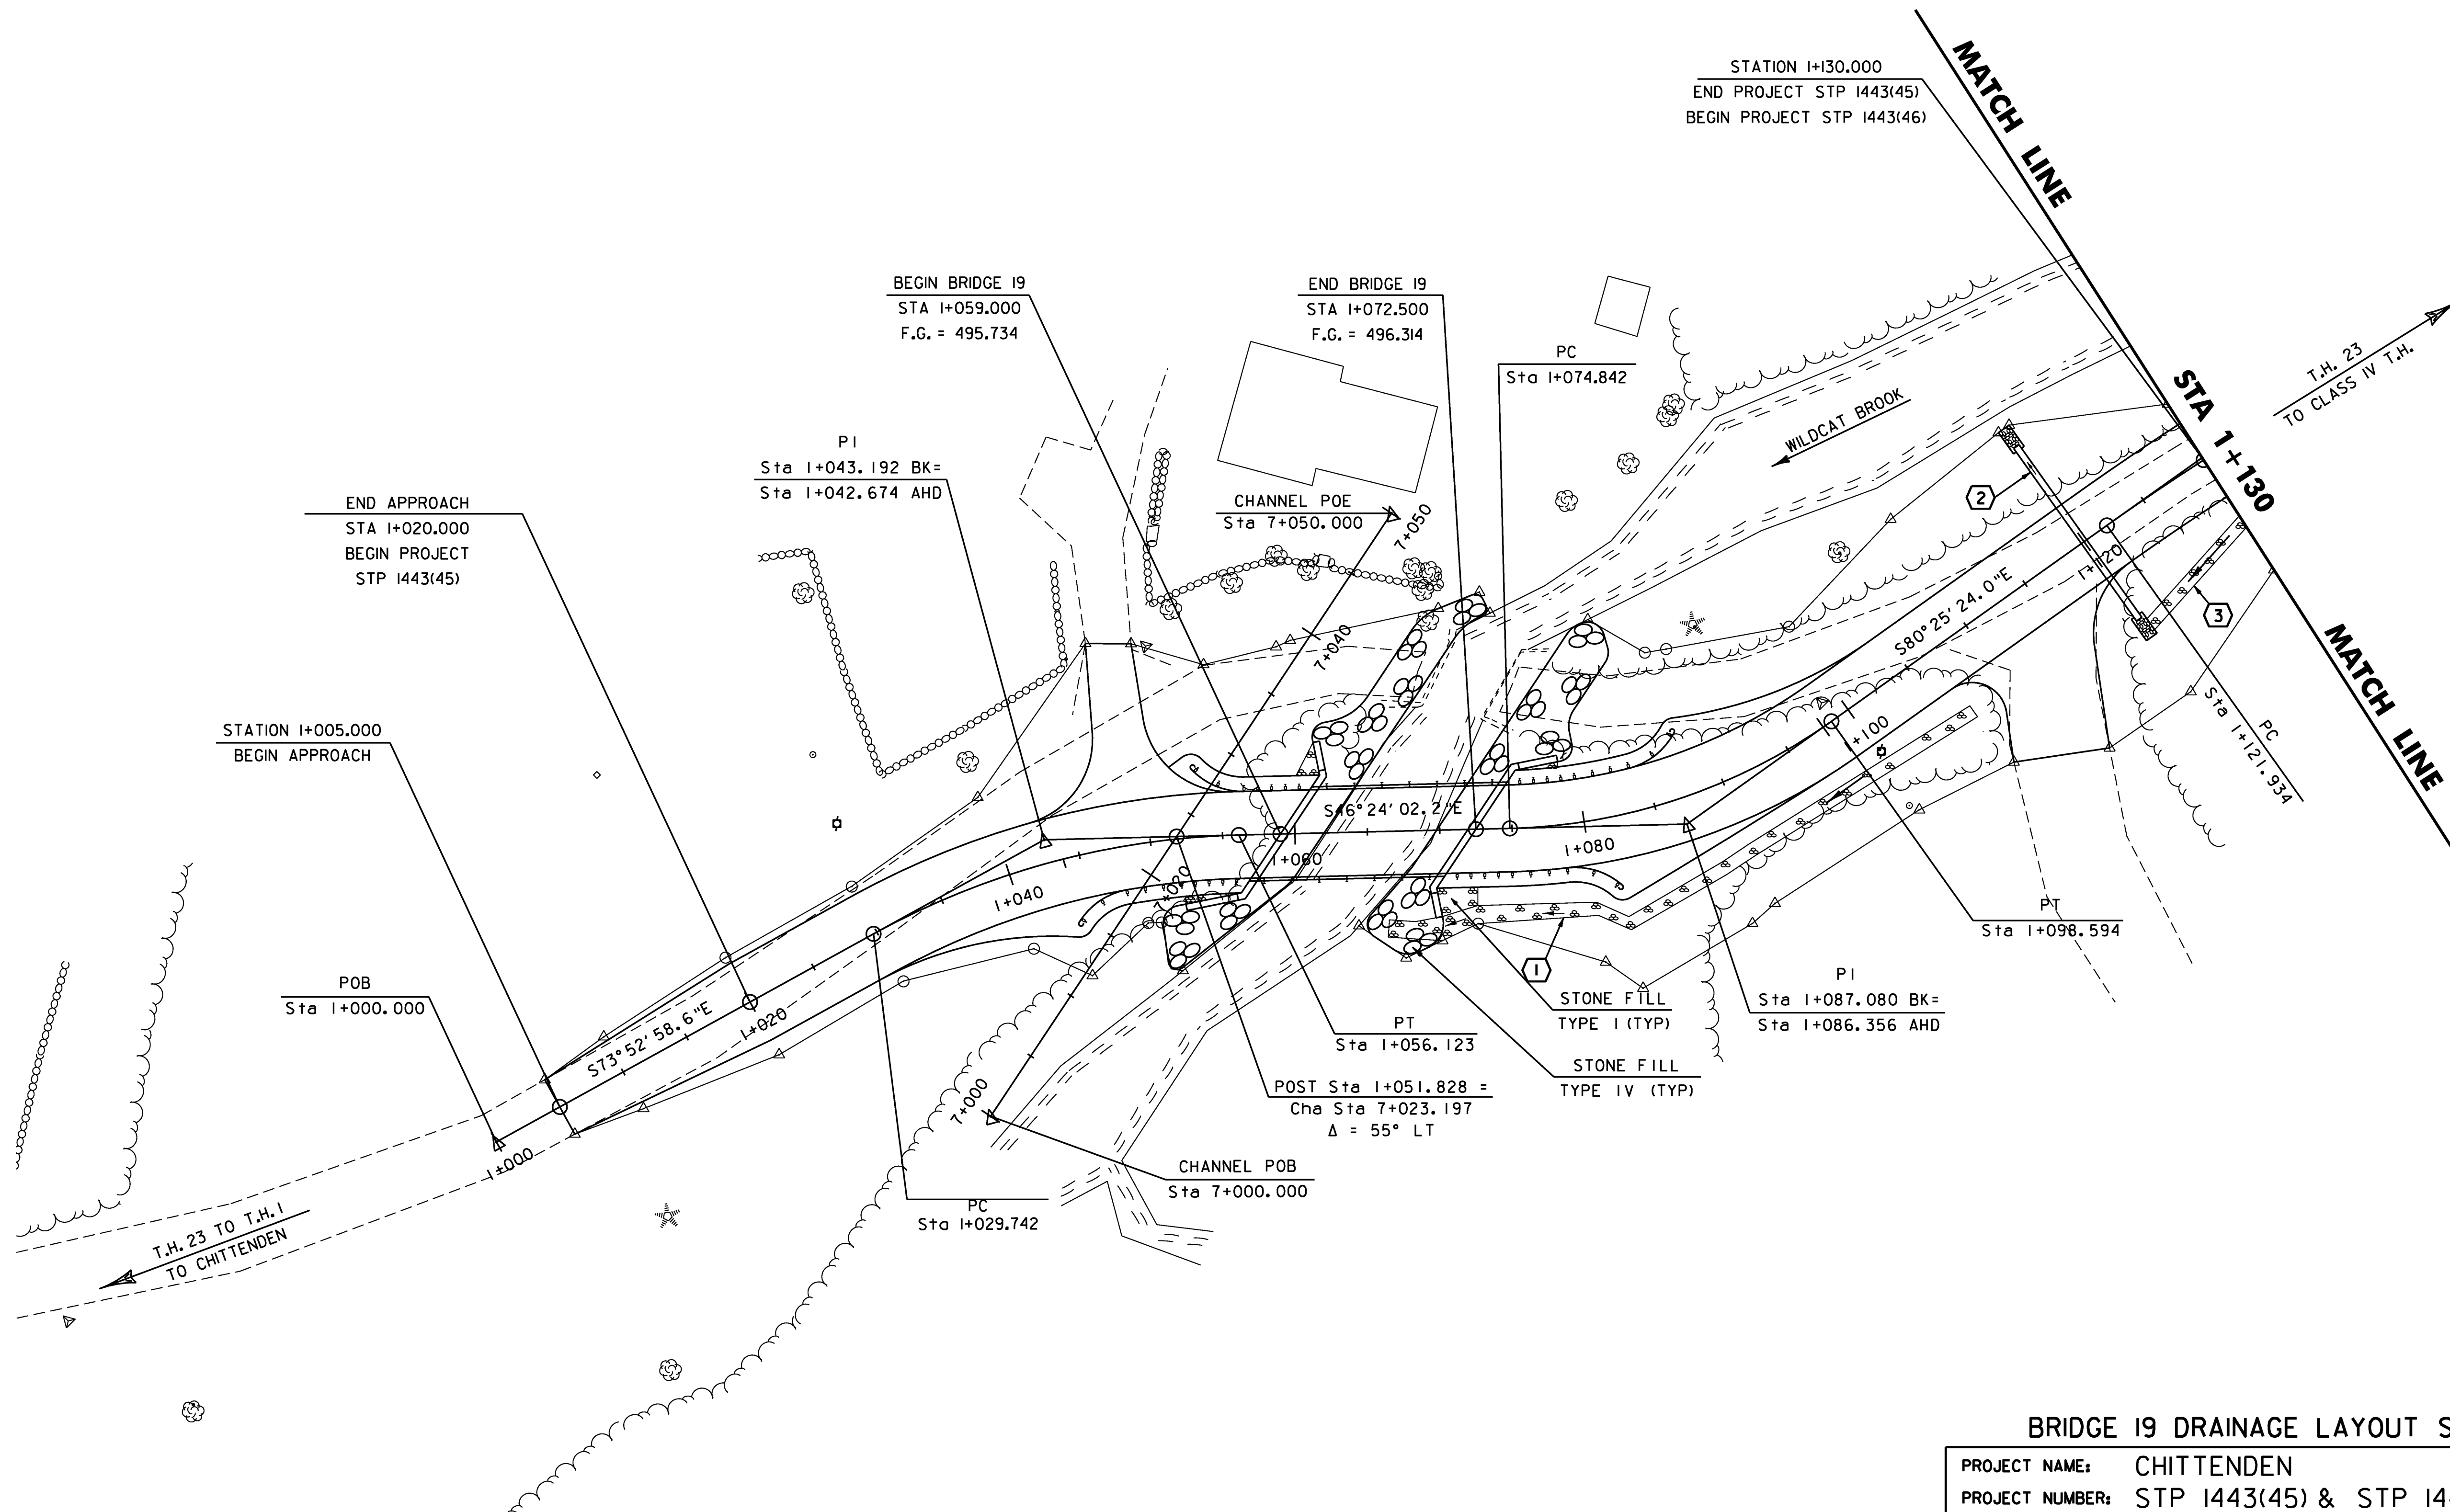


NO.	LOCATION	DESCRIPTION
①	I+070.119 RT - I+107.000 RT	CONSTRUCT STONE FILL TYPE I DITCH
②	I+120.000 RT - I+120.000 LT	450 x 15000 PIPE OPTIONS WITH STONE PAD, TYPE I AT INLET AND OUTLET
③	I+120.450 RT - I+130.000 RT	CONSTRUCT STONE FILL TYPE I DITCH

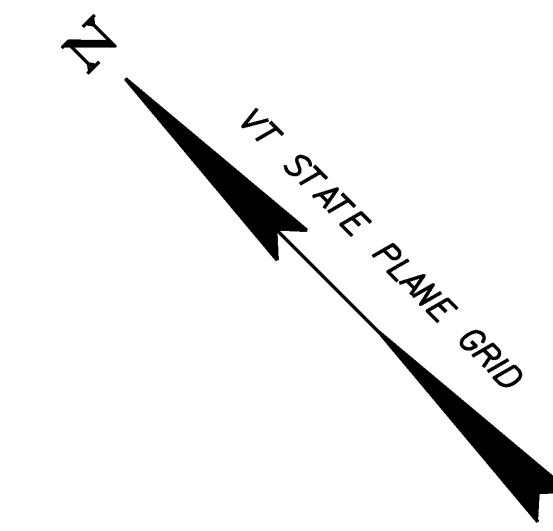

BRIDGE 19 DRAINAGE LAYOUT SHEET

PROJECT NAME:	CHITTENDEN
PROJECT NUMBER:	STP I443(45) & STP I443(46)
FILE NAME:	/96J236/str/sj236drn.dgn
DESIGNED BY:	K. UPMAL
PLOT DATE:	14-AUG-2009
DRAWN BY:	STR
CHECKED BY:	C. CARLSON
SHEET	8 OF 81