
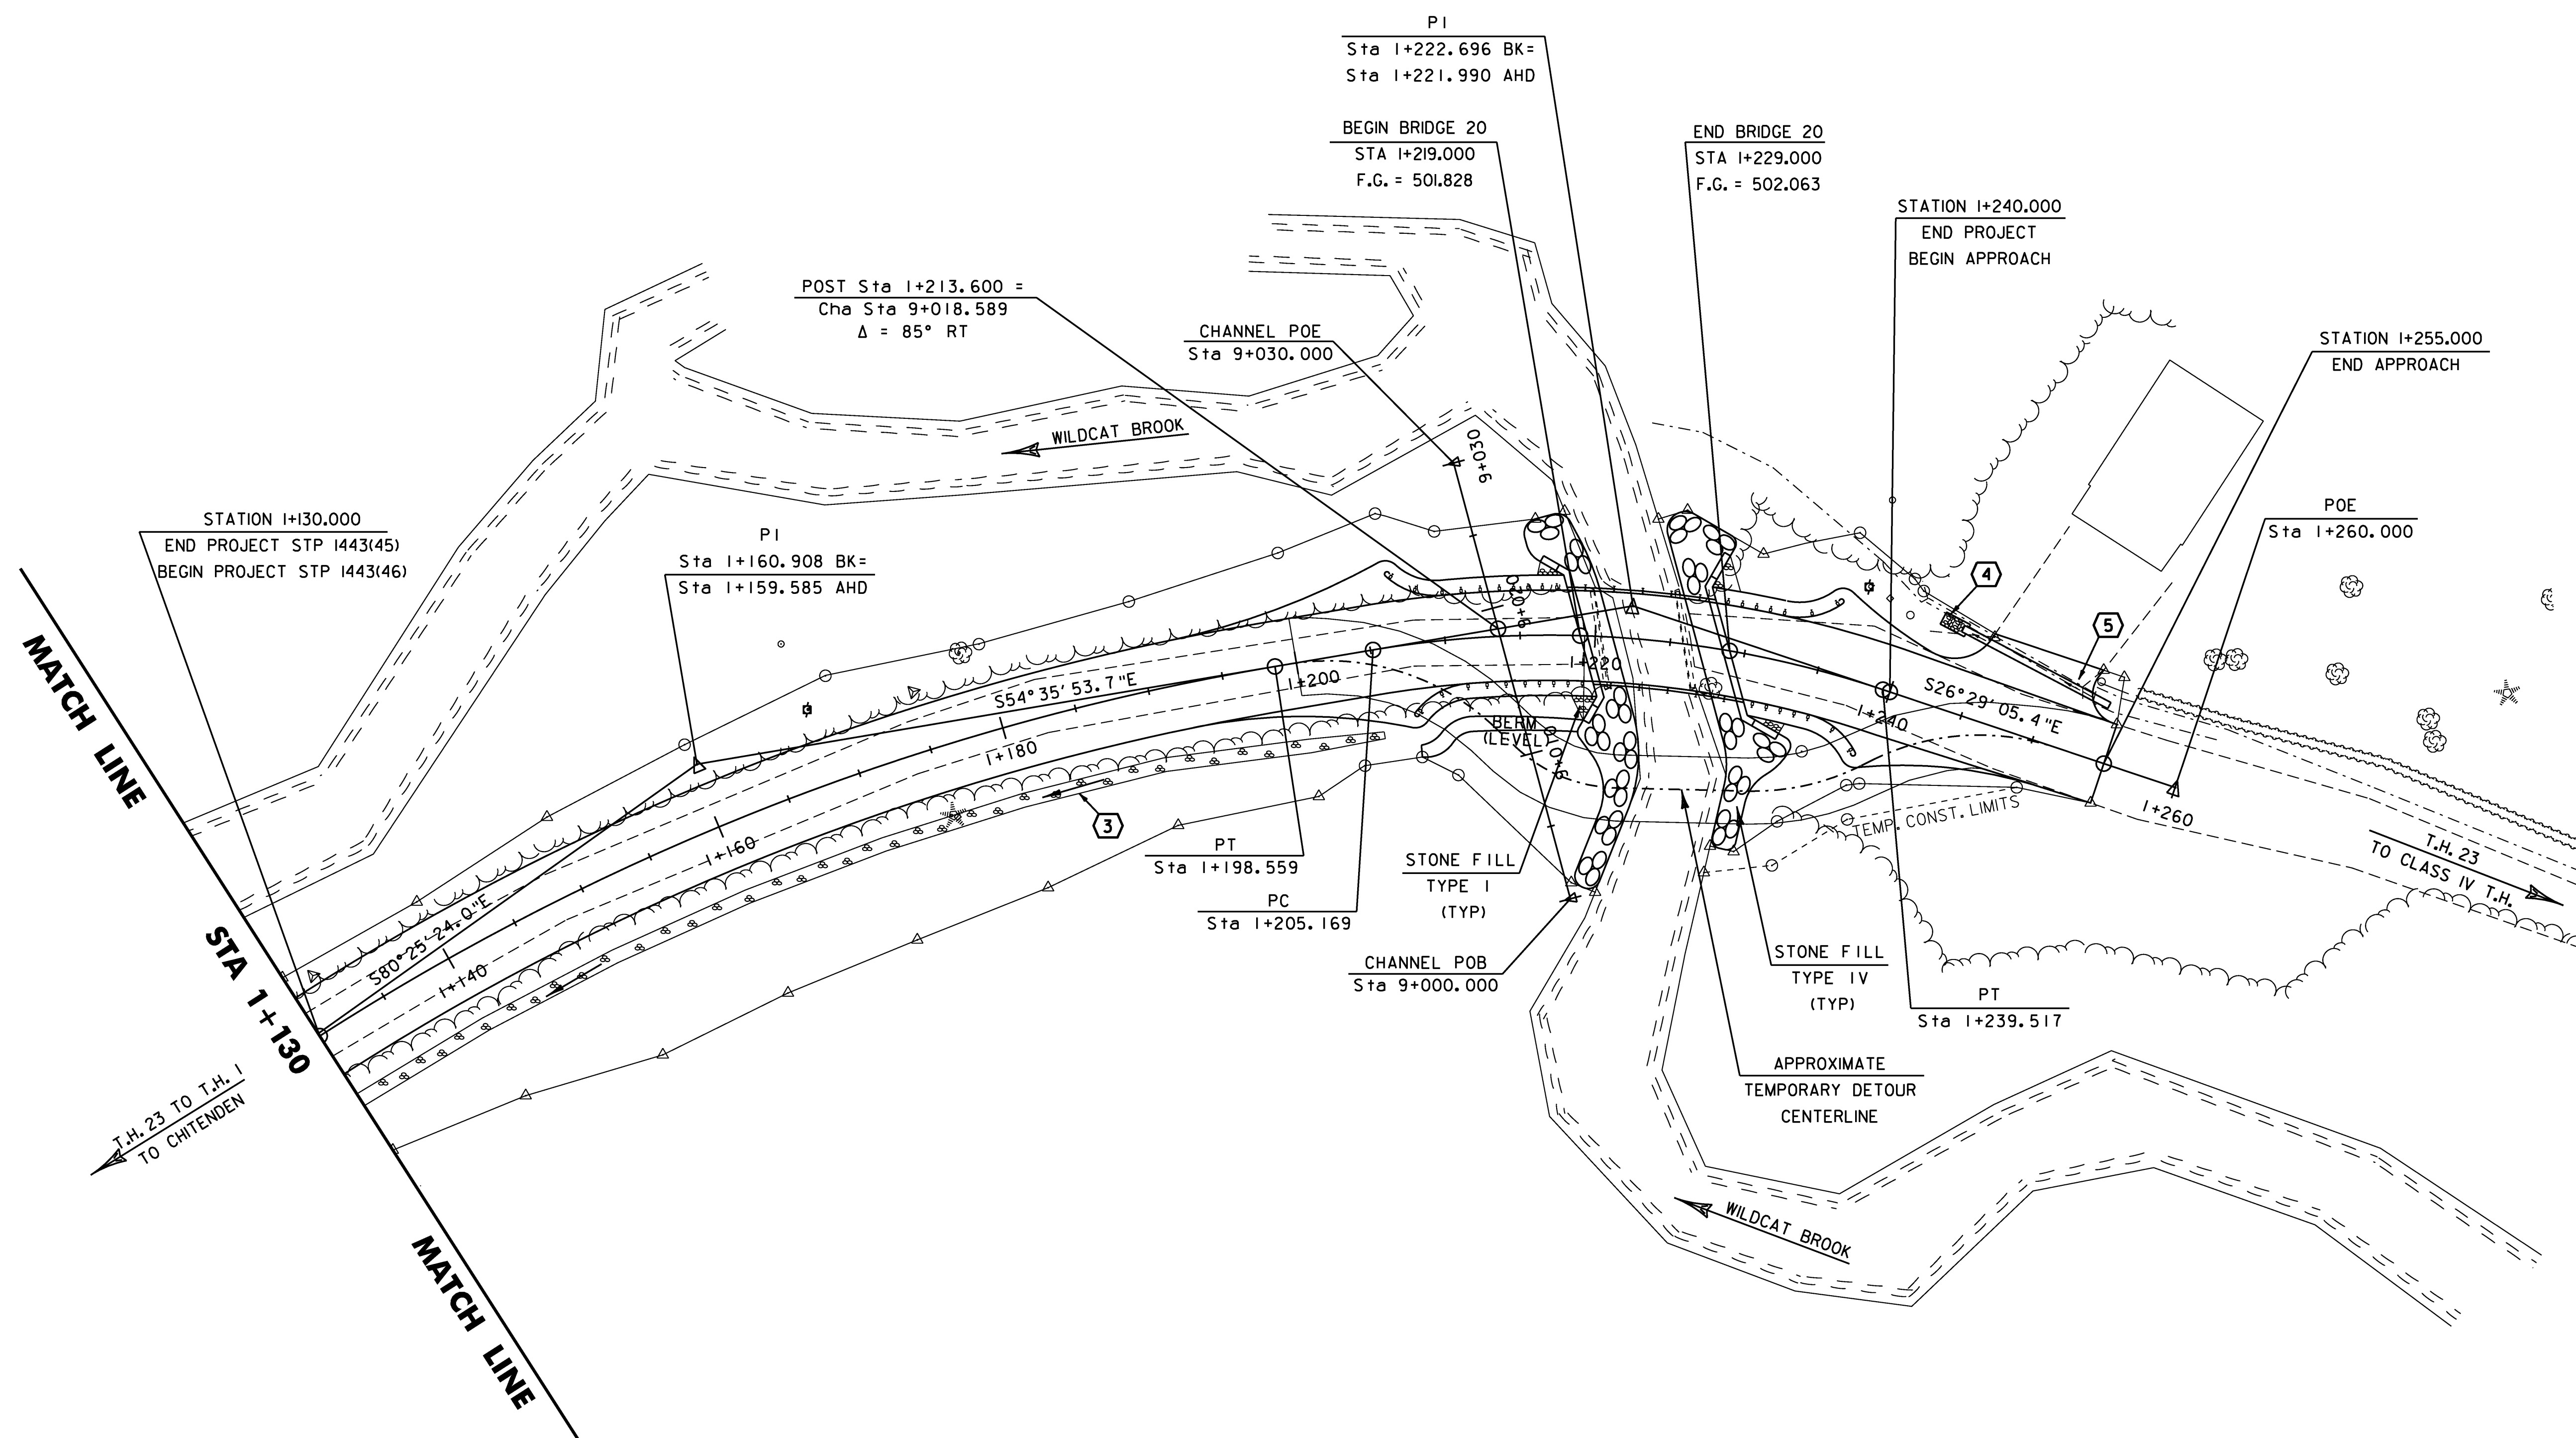


NO.	LOCATION	DESCRIPTION
3	I+130.000 RT - I+205.000 RT	CONSTRUCT STONE FILL TYPE I DITCH
4	I+240.415 LT - I+252.976 LT	REMOVE 300 PVC PIPE
5	I+243.203 LT - I+254.173 LT	450 x 11000 PIPE OPTION WITH STONE PAD, TYPE I AT OUTLET

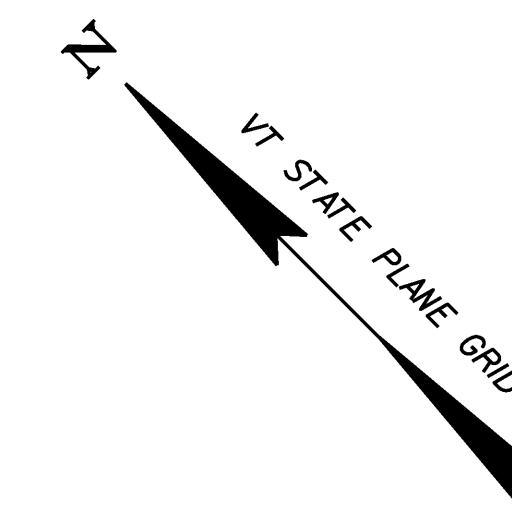

BRIDGE 20 DRAINAGE LAYOUT SHEET

PROJECT NAME: CHITTENDEN
PROJECT NUMBER: STP I443(45) & STP I443(46)

FILE NAME: /96j236/str/sj236drn.dgn
PROJECT LEADER: C. CARLSON
DESIGNED BY: K. UPMAL
PLOT DATE: 14-AUG-2009
DRAWN BY: STR
CHECKED BY: C. CARLSON
SHEET 9 OF 81

