

INSTALL STREET LIGHTING (RA40-16)

STA. 1+105.0, 6.6 LT. & RT. SL-1 & SL-2
 STA. 1+135, 6.6 LT. & RT. SL-3 & SL-4

ADJUST ELEVATION OF VALVE BOX

STA. 1+074.0, LT.
 STA. 1+087.0, LT.
 STA. 1+088.0, LT.
 STA. 1+092.0, RT.
 STA. 1+098.0, LT.
 STA. 1+140.3, RT.
 STA. U 10+009.0, LT.
 STA. R 5+033.0, RT.

SLEEVES FOR UTILITIES

STA. 1+104.6 LT. TO RT.
 STA. 1+134.7 LT. TO RT.

DIRECT BURIAL CABLE

STA. 1+068.0 TO 1+153.0, LT. (EST.)
 STA. 1+095.0 TO 1+147.0, RT. (EST.)

CHANGE ELEVATION OF SEWER MANHOLE


STA. 1+096.0, Q
 STA. 1+143.0, RT.
 STA. 1+146.0, RT.
 STA. 1+165.0, RT.
 STA. R 5+073.0, LT.

LIGHT POLE

STA. 1+105.0, LT. & RT.
 STA. 1+135.0, LT. & RT.

LUMINAIRE

STA. 1+105.0, LT. & RT.
 STA. 1+135.0, LT. & RT.

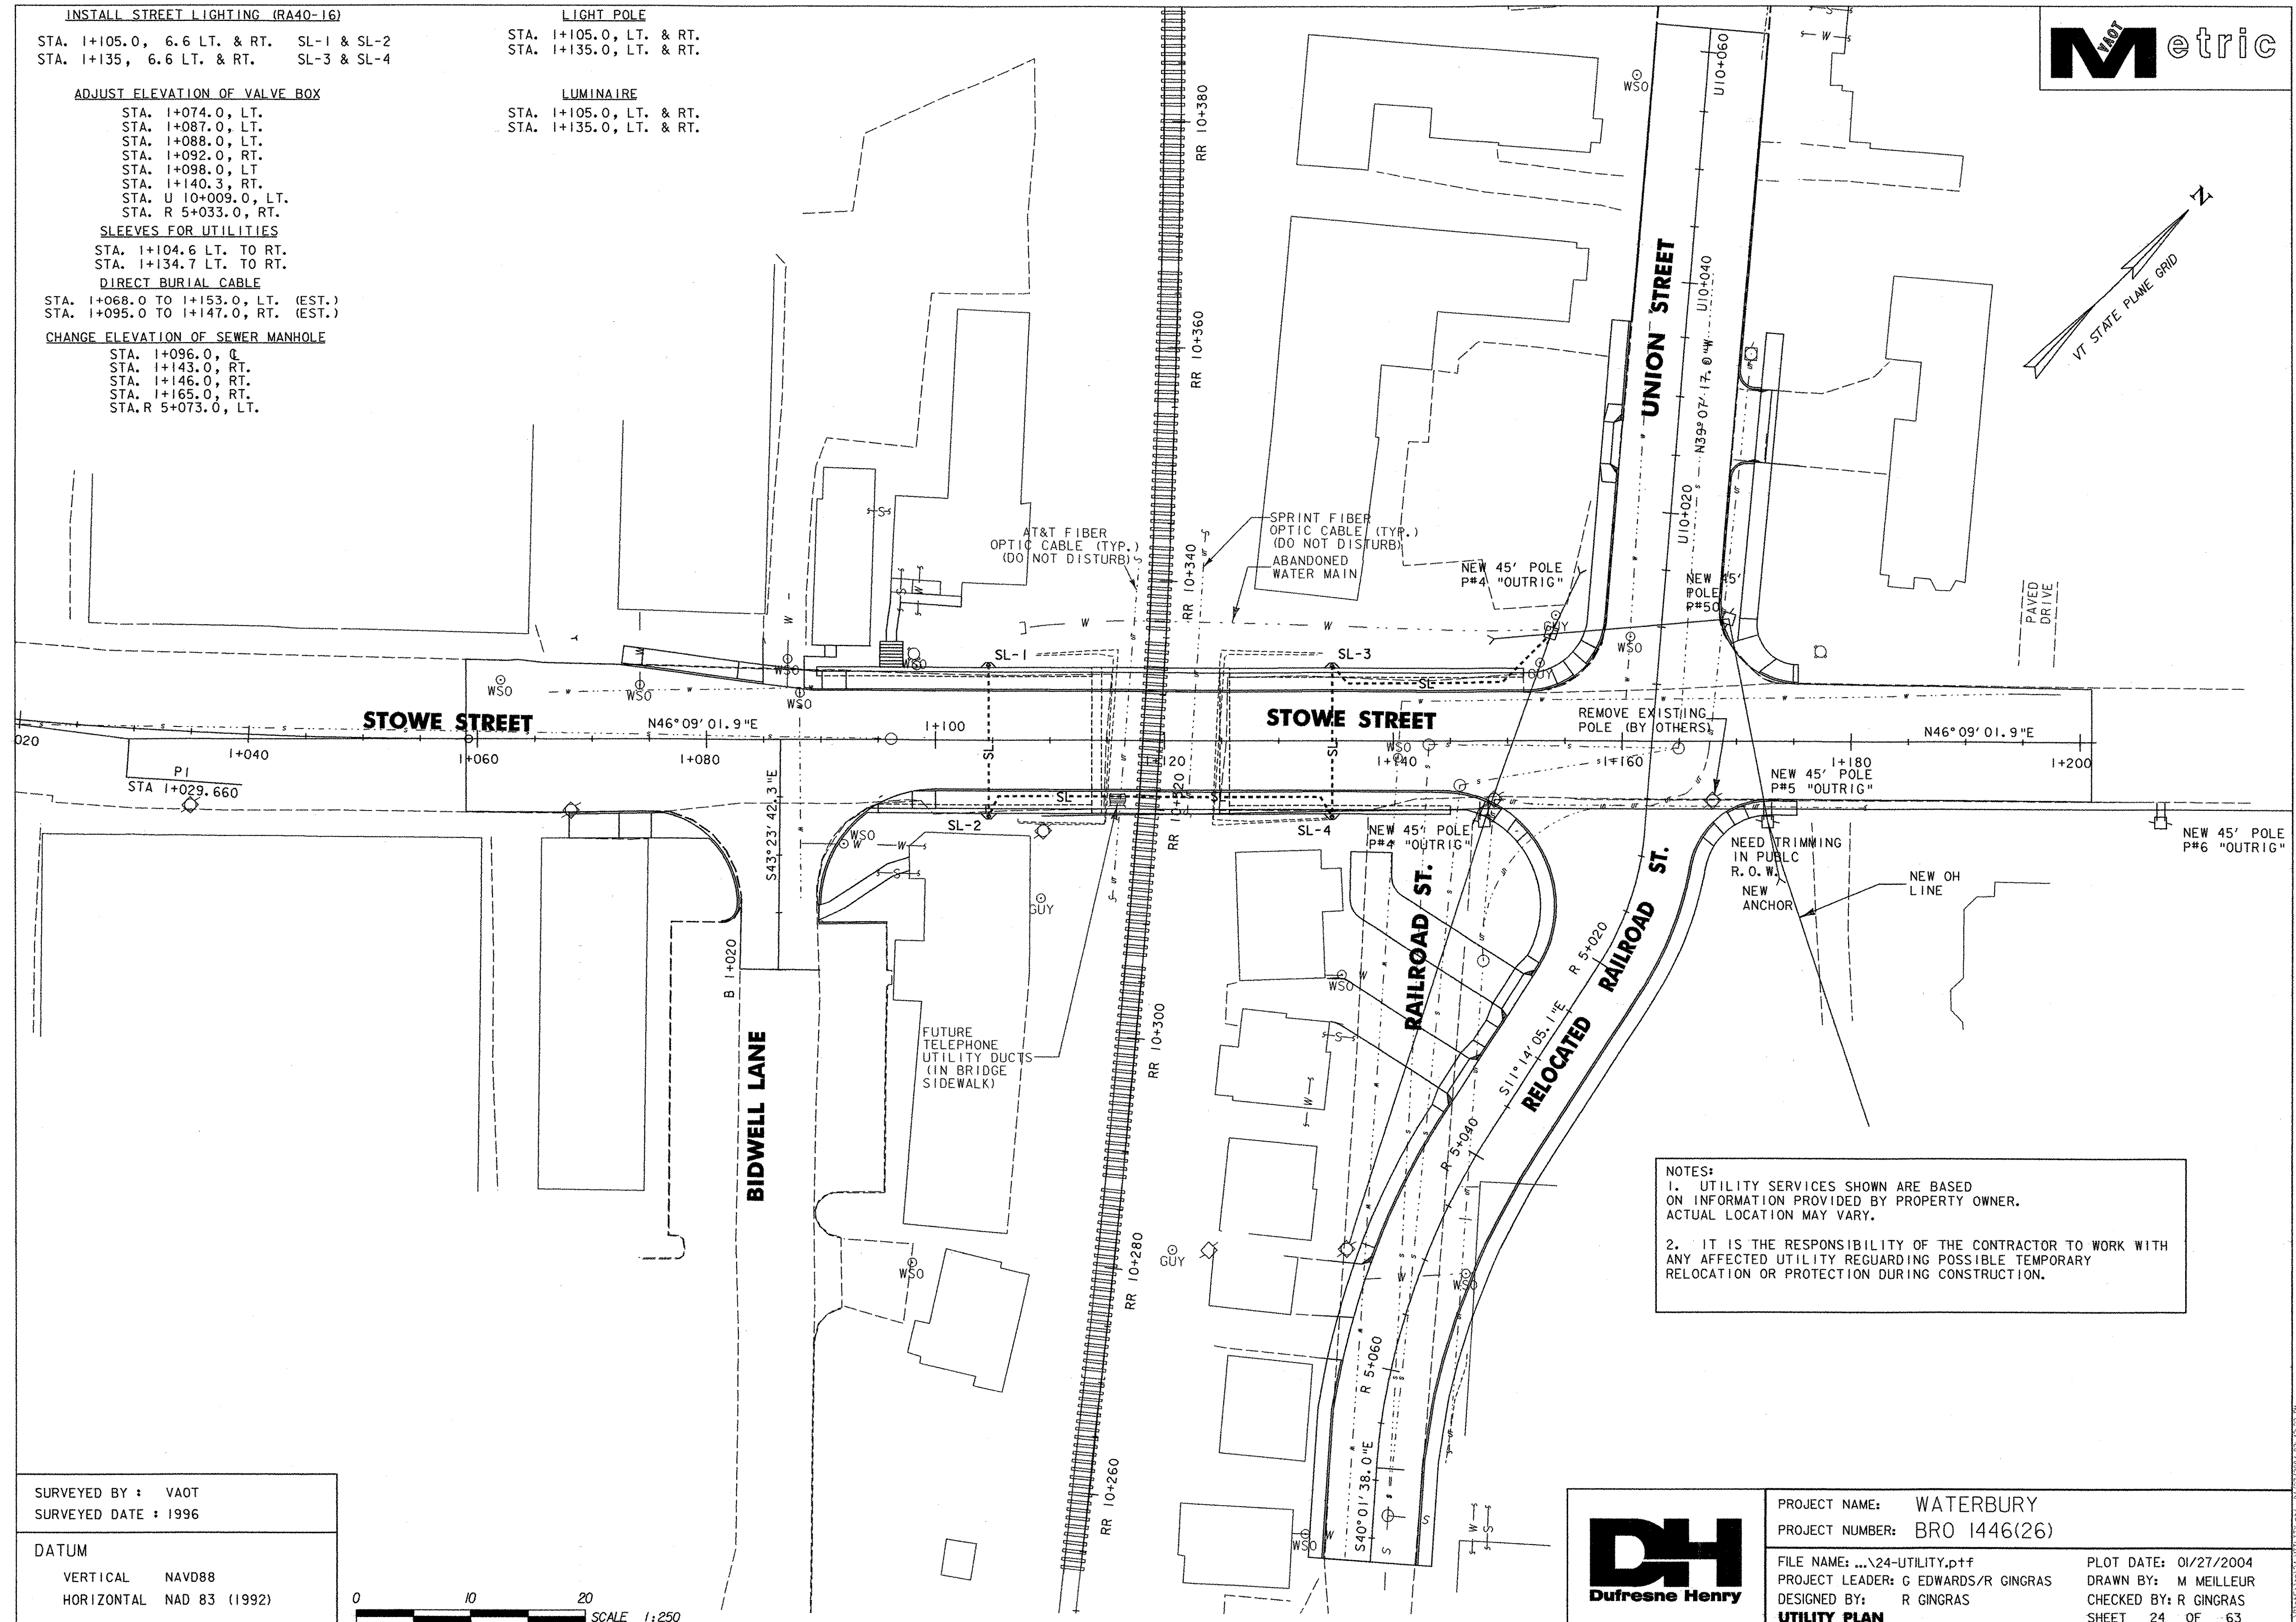

NOTES:
 1. UTILITY SERVICES SHOWN ARE BASED ON INFORMATION PROVIDED BY PROPERTY OWNER. ACTUAL LOCATION MAY VARY.
 2. IT IS THE RESPONSIBILITY OF THE CONTRACTOR TO WORK WITH ANY AFFECTED UTILITY REGARDING POSSIBLE TEMPORARY RELOCATION OR PROTECTION DURING CONSTRUCTION.

SURVEYED BY : VAOT
 SURVEYED DATE : 1996

DATUM
 VERTICAL NAVD88
 HORIZONTAL NAD 83 (1992)



PROJECT NAME: WATERBURY
 PROJECT NUMBER: BRO 1446(26)

FILE NAME: ...24-UTILITY.pjf
 PROJECT LEADER: G EDWARDS/R GINGRAS
 DESIGNED BY: R GINGRAS

UTILITY PLAN

PLOT DATE: 01/27/2004
 DRAWN BY: M MEILLEUR
 CHECKED BY: R GINGRAS
 SHEET 24 OF 63