


678.23 WIRED CONDUIT (50 mm DIA. - SCHEDULE 40)
 STA. I+340.0 - STA. I+345.0 LT

679.21 LIGHT POLE BASE
 STA. I+345.0, 4.6 m LT

679.45 LIGHT POLE (MOD.)
 STA. I+345.0, 4.6 m LT

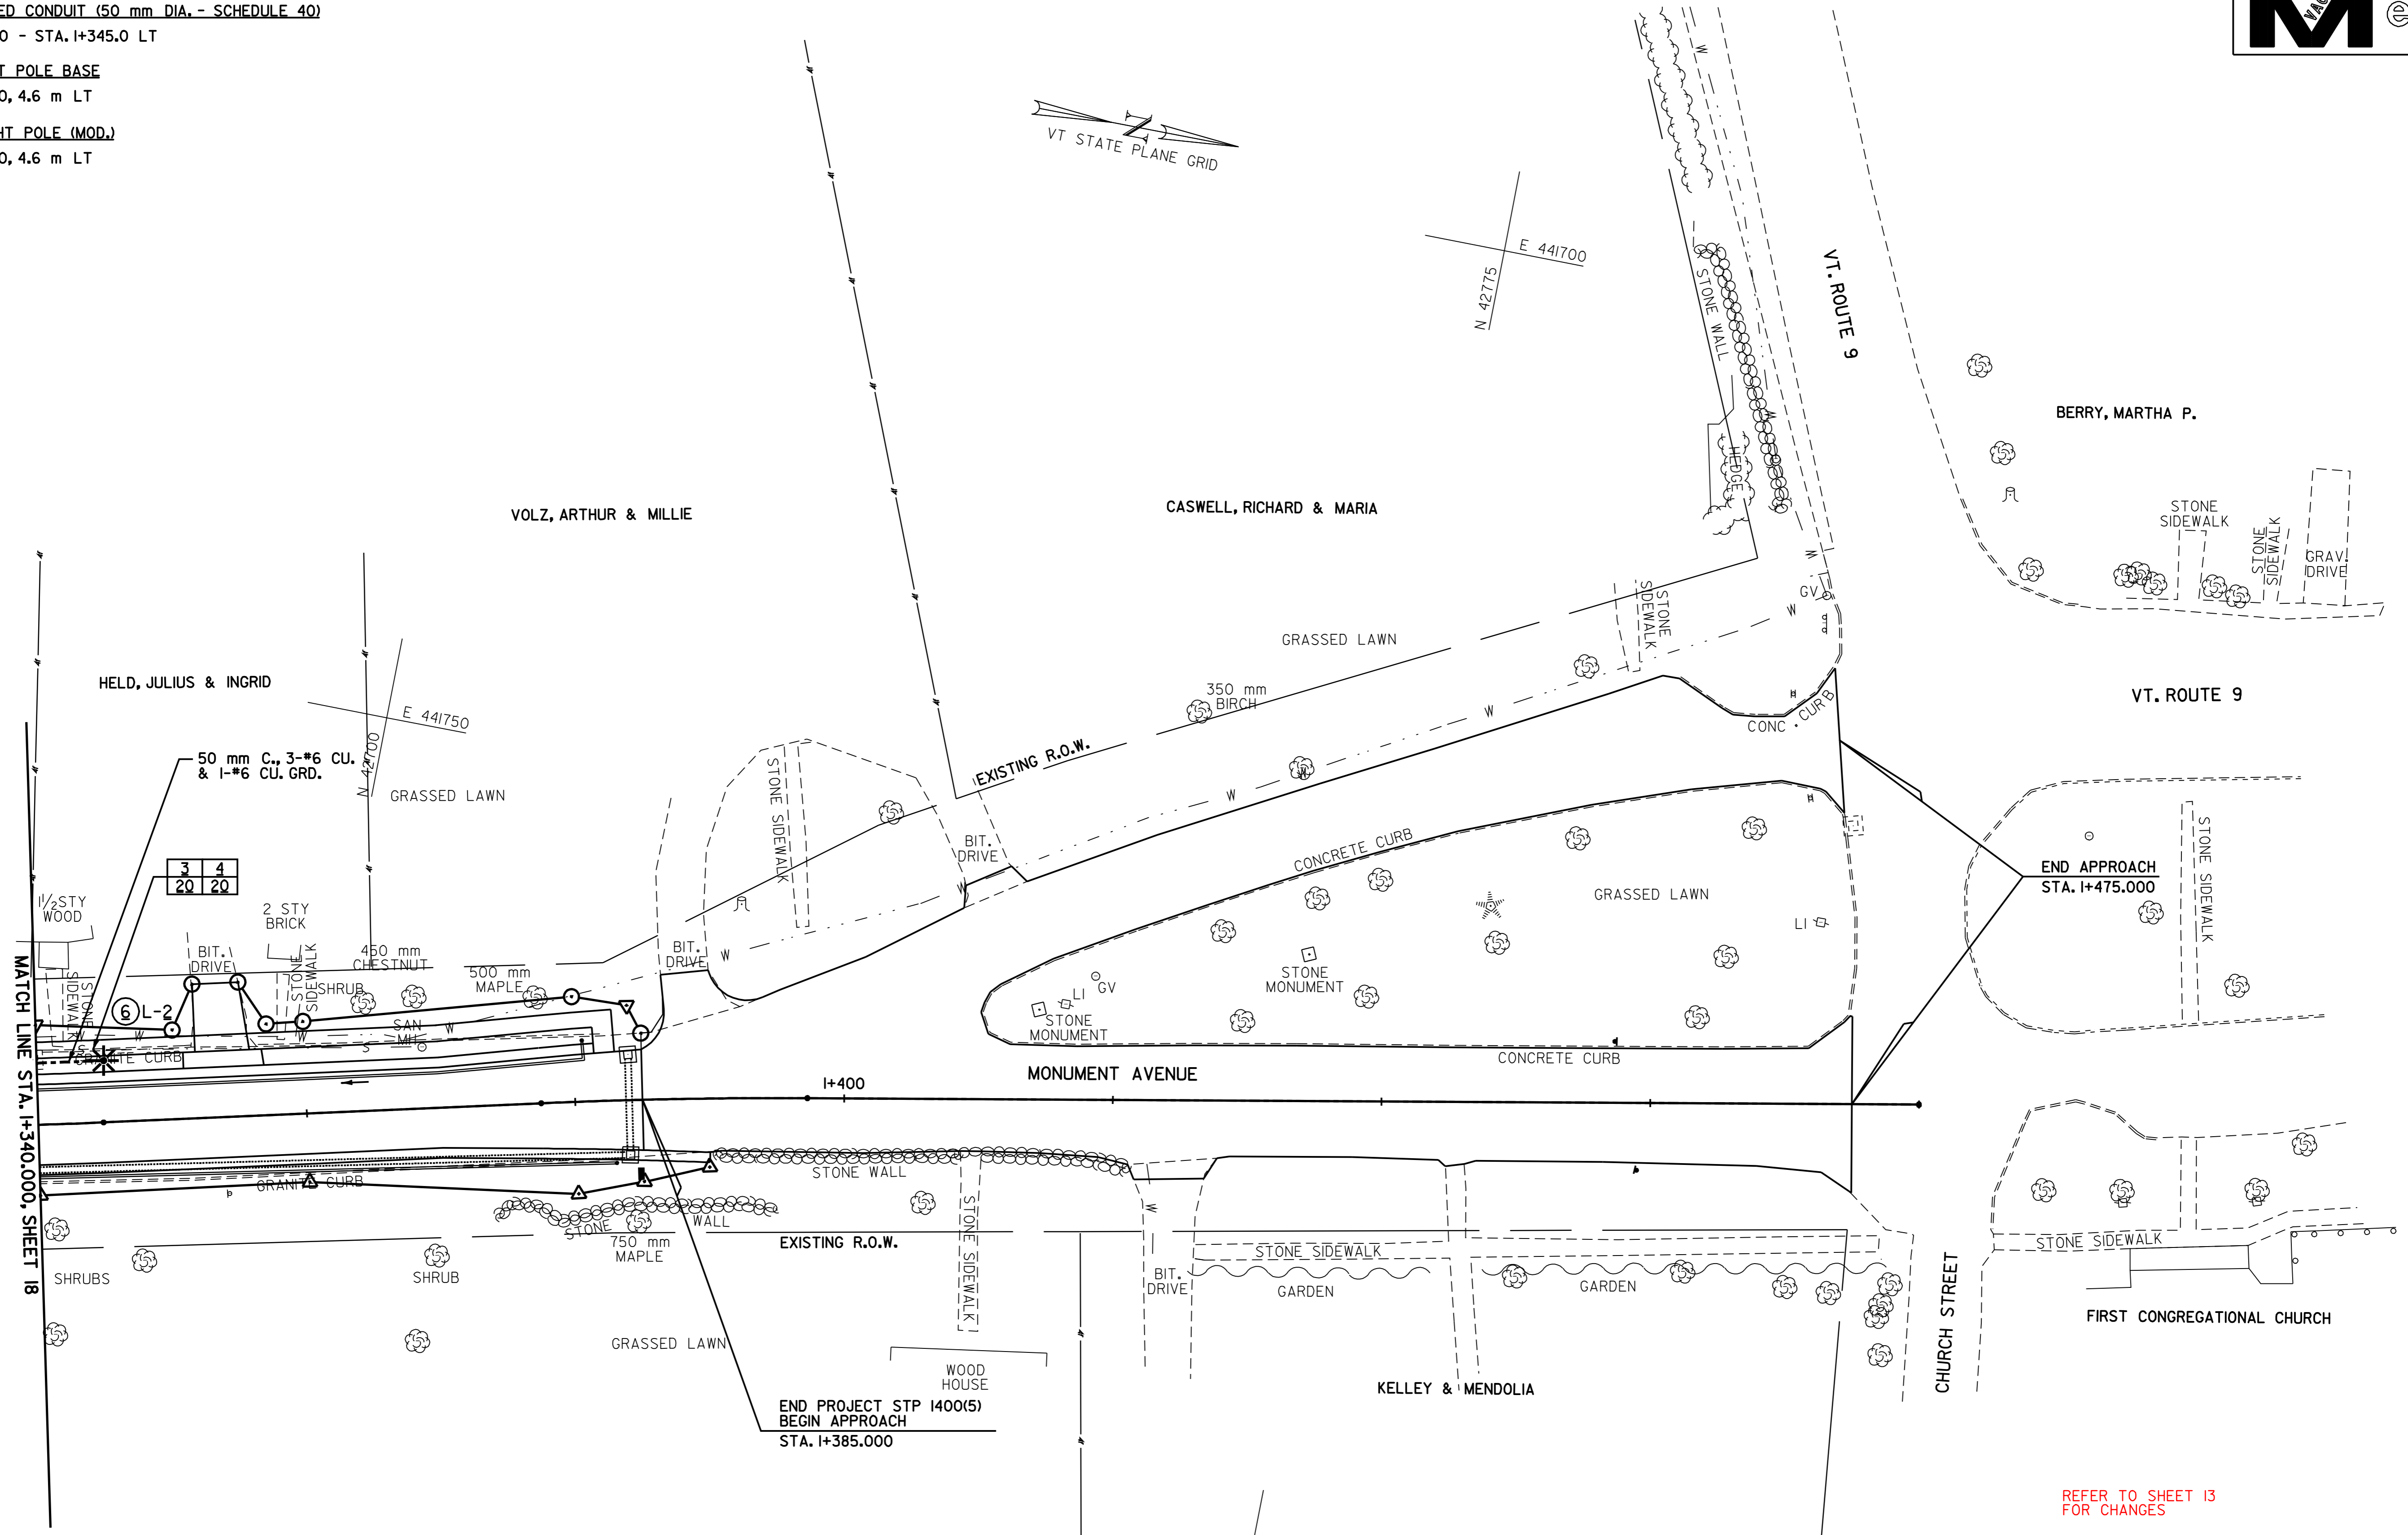


MATCH LINE STA. I+340.000, SHEET 18

REFER TO SHEET 13 FOR CHANGES

NEW STREET LIGHTING LEGEND	
	LIGHT POLE
	CONDUIT
	JUNCTION BOX
	CONDUIT SLEEVE
	POWER STANCHION
	LIGHT POLE NUMBER
	CIRCUIT NUMBER
	DETAIL NUMBER ON SHEET NUMBER

DATUM	
VERTICAL	N/A
HORIZONTAL	NAD 83 (1996)

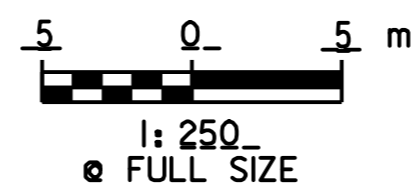

UTILITY PLAN SHEET # 3

VERMONT AGENCY OF TRANSPORTATION

CHA CLOUGH, HARBOUR & ASSOCIATES <small>ENGINEERS, SURVEYORS, PLANNERS & LANDSCAPE ARCHITECTS</small> <small>80 WINNERS CIRCLE ALBANY, NEW YORK, 12208</small>	PROJECT NAME: OLD BENNINGTON	PLOT DATE: 05-MAY-2008 14	
	PROJECT NUMBER: STP 1400(5)	DRAWN BY: C.A.K.	
	FILE NAME: /pave/97d228/p97d228.dgn	DESIGNED BY: J.S.P.	CHECKED BY: D.E.G.
	PROJECT LEADER: I.E.K.	SHEET 19 OF 48	