


**PLANTING SCHEDULE**

DECIDUOUS TREES - ACER RUBRUM (RED MAPLE)			
NO.	STATION	OFFSET	SIZE
RM-1	2+97.82	99.39' RT	2 - 2.5 IN CAL IPER
RM-2	2+41.43	84.43' RT	2 - 2.5 IN CAL IPER
RM-3	1+96.42	78.91' RT	2 - 2.5 IN CAL IPER
RM-4	1+50.76	78.51' RT	2 - 2.5 IN CAL IPER
RM-5	1+01.30	64.06' RT	2 - 2.5 IN CAL IPER
RM-6	7+50.13	182.20' LT	2 - 2.5 IN CAL IPER
RM-7	7+90.19	163.26' LT	2 - 2.5 IN CAL IPER
RM-8	8+25.90	138.02' LT	2 - 2.5 IN CAL IPER
RM-9	1+44.60	112.94' LT	2 - 2.5 IN CAL IPER
RM-10	2+33.23	114.58' LT	2 - 2.5 IN CAL IPER

EVERGREEN TREES - PICEA GLAUCA (WHITE SPRUCE)			
NO.	STATION	OFFSET	SIZE
WS-1	6+33.00	60.00' RT	5 - 6 FT HEIGHT
WS-2	7+00.00	60.00' RT	5 - 6 FT HEIGHT
WS-3	7+50.00	60.00' RT	5 - 6 FT HEIGHT

**LANDSCAPING LEGEND**

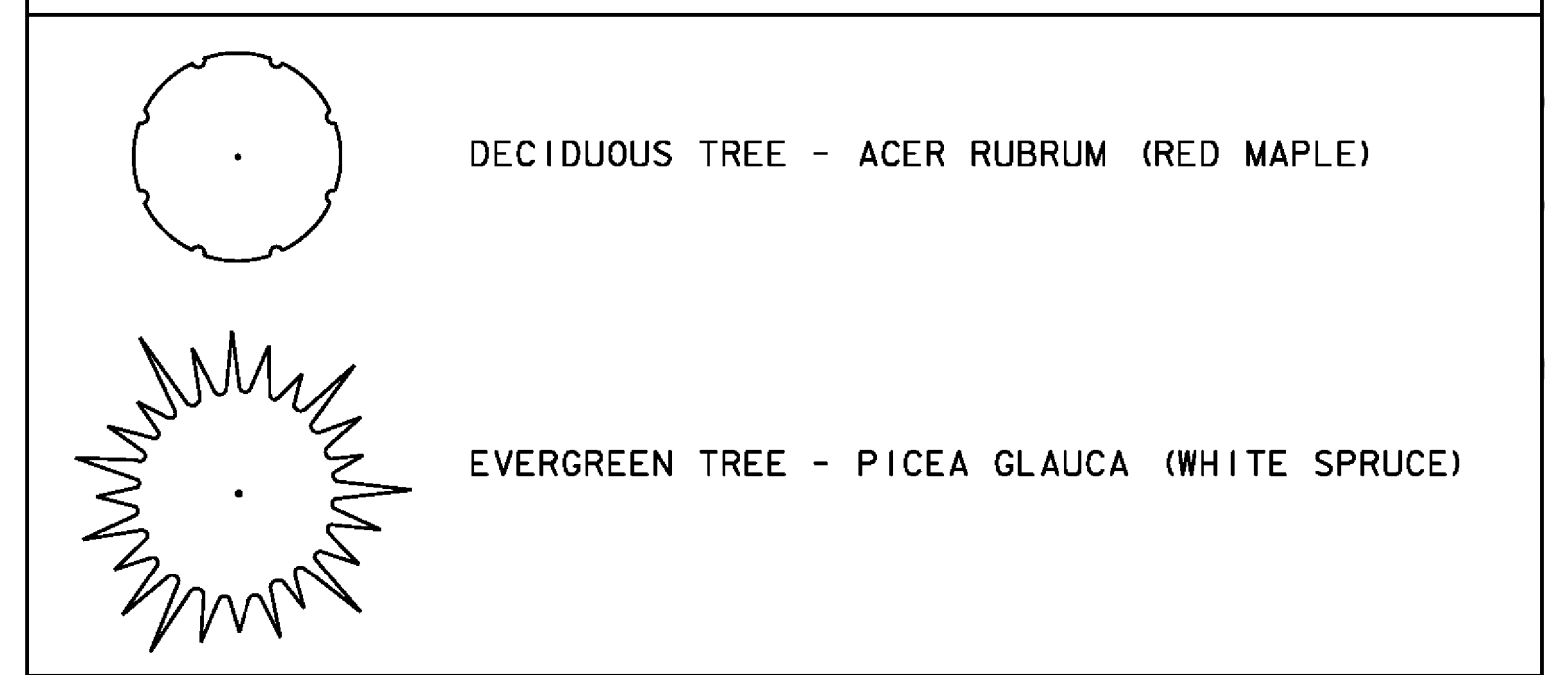


STA. BL2 5+87.15, 35.28' LT TO 5+45.62, 16.50 RT.  
 ELECTRICAL CONDUIT SLEEVE (3")  
 STA. BL1 2+04.78, 2.5' RT. TO 2+03.16, 61.8' RT.  
 STA. BL1 2+03.16, 61.8 RT. TO 3+10, 10' LT.  
 JUNCTION BOX  
 STA. BL 2+63.74, 94.7' LT. (HH-1) ELIMINATED  
 STA. BL 1+09.19, 95.1' LT. (HH-2)  
 STA. BL 1+09.50, 50.9' RT. (HH-3)  
 STA. BL 2+03.07, 62.6' RT. (HH-4)


**SITE LIGHTING LOCATIONS**

POLE NO.	LOCATION	OFFSET TO FACE OF BASE	FIXTURE TYPE	XFMR/CIRCUIT	REMARKS
SL-1	5+45.62	16.50' RT	A		BASELINE 2
SL-2	6+74.65	23.50' RT	A		BASELINE 2
SL-3	2+33.61	97.30' LT	A		BASELINE 1
SL-4	1+43.89	97.30' LT	A		BASELINE 1
SL-5	1+06.00	19.00' LT	A		BASELINE 1
SL-6	1+51.73	64.70' RT	A		BASELINE 1
SL-7	2+41.63	67.70' RT	A		BASELINE 1
SL-8	5+87.15	35.28' LT	A		BASELINE 2
SL-9	2+04.89	1.41' RT	B		BASELINE 1

**SITE LIGHTING LEGEND**

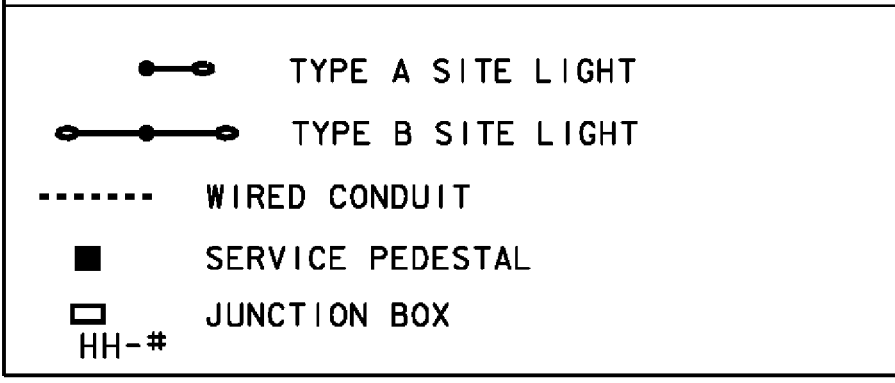

NOTE:  
 1. FOR DETAIL ON ALL PERTINENT ITEMS ON THIS SHEET REFER TO VTRANS STANDARDS E-173, 175, 180A, AND 180B.  
 2. WORK TO BE PAID FOR AS ITEM 679.55 POWER DROP STANCHION, STREET LIGHTING.  
 3. REMOVAL AND DISPOSAL OF EXISTING LIGHT FIXTURES ON UTILITY POLES AS DIRECTED BY THE ENGINEER. WORK REQUIRED SHALL BE INCIDENTAL TO PAY ITEM 679.50 LUMINAIRE.

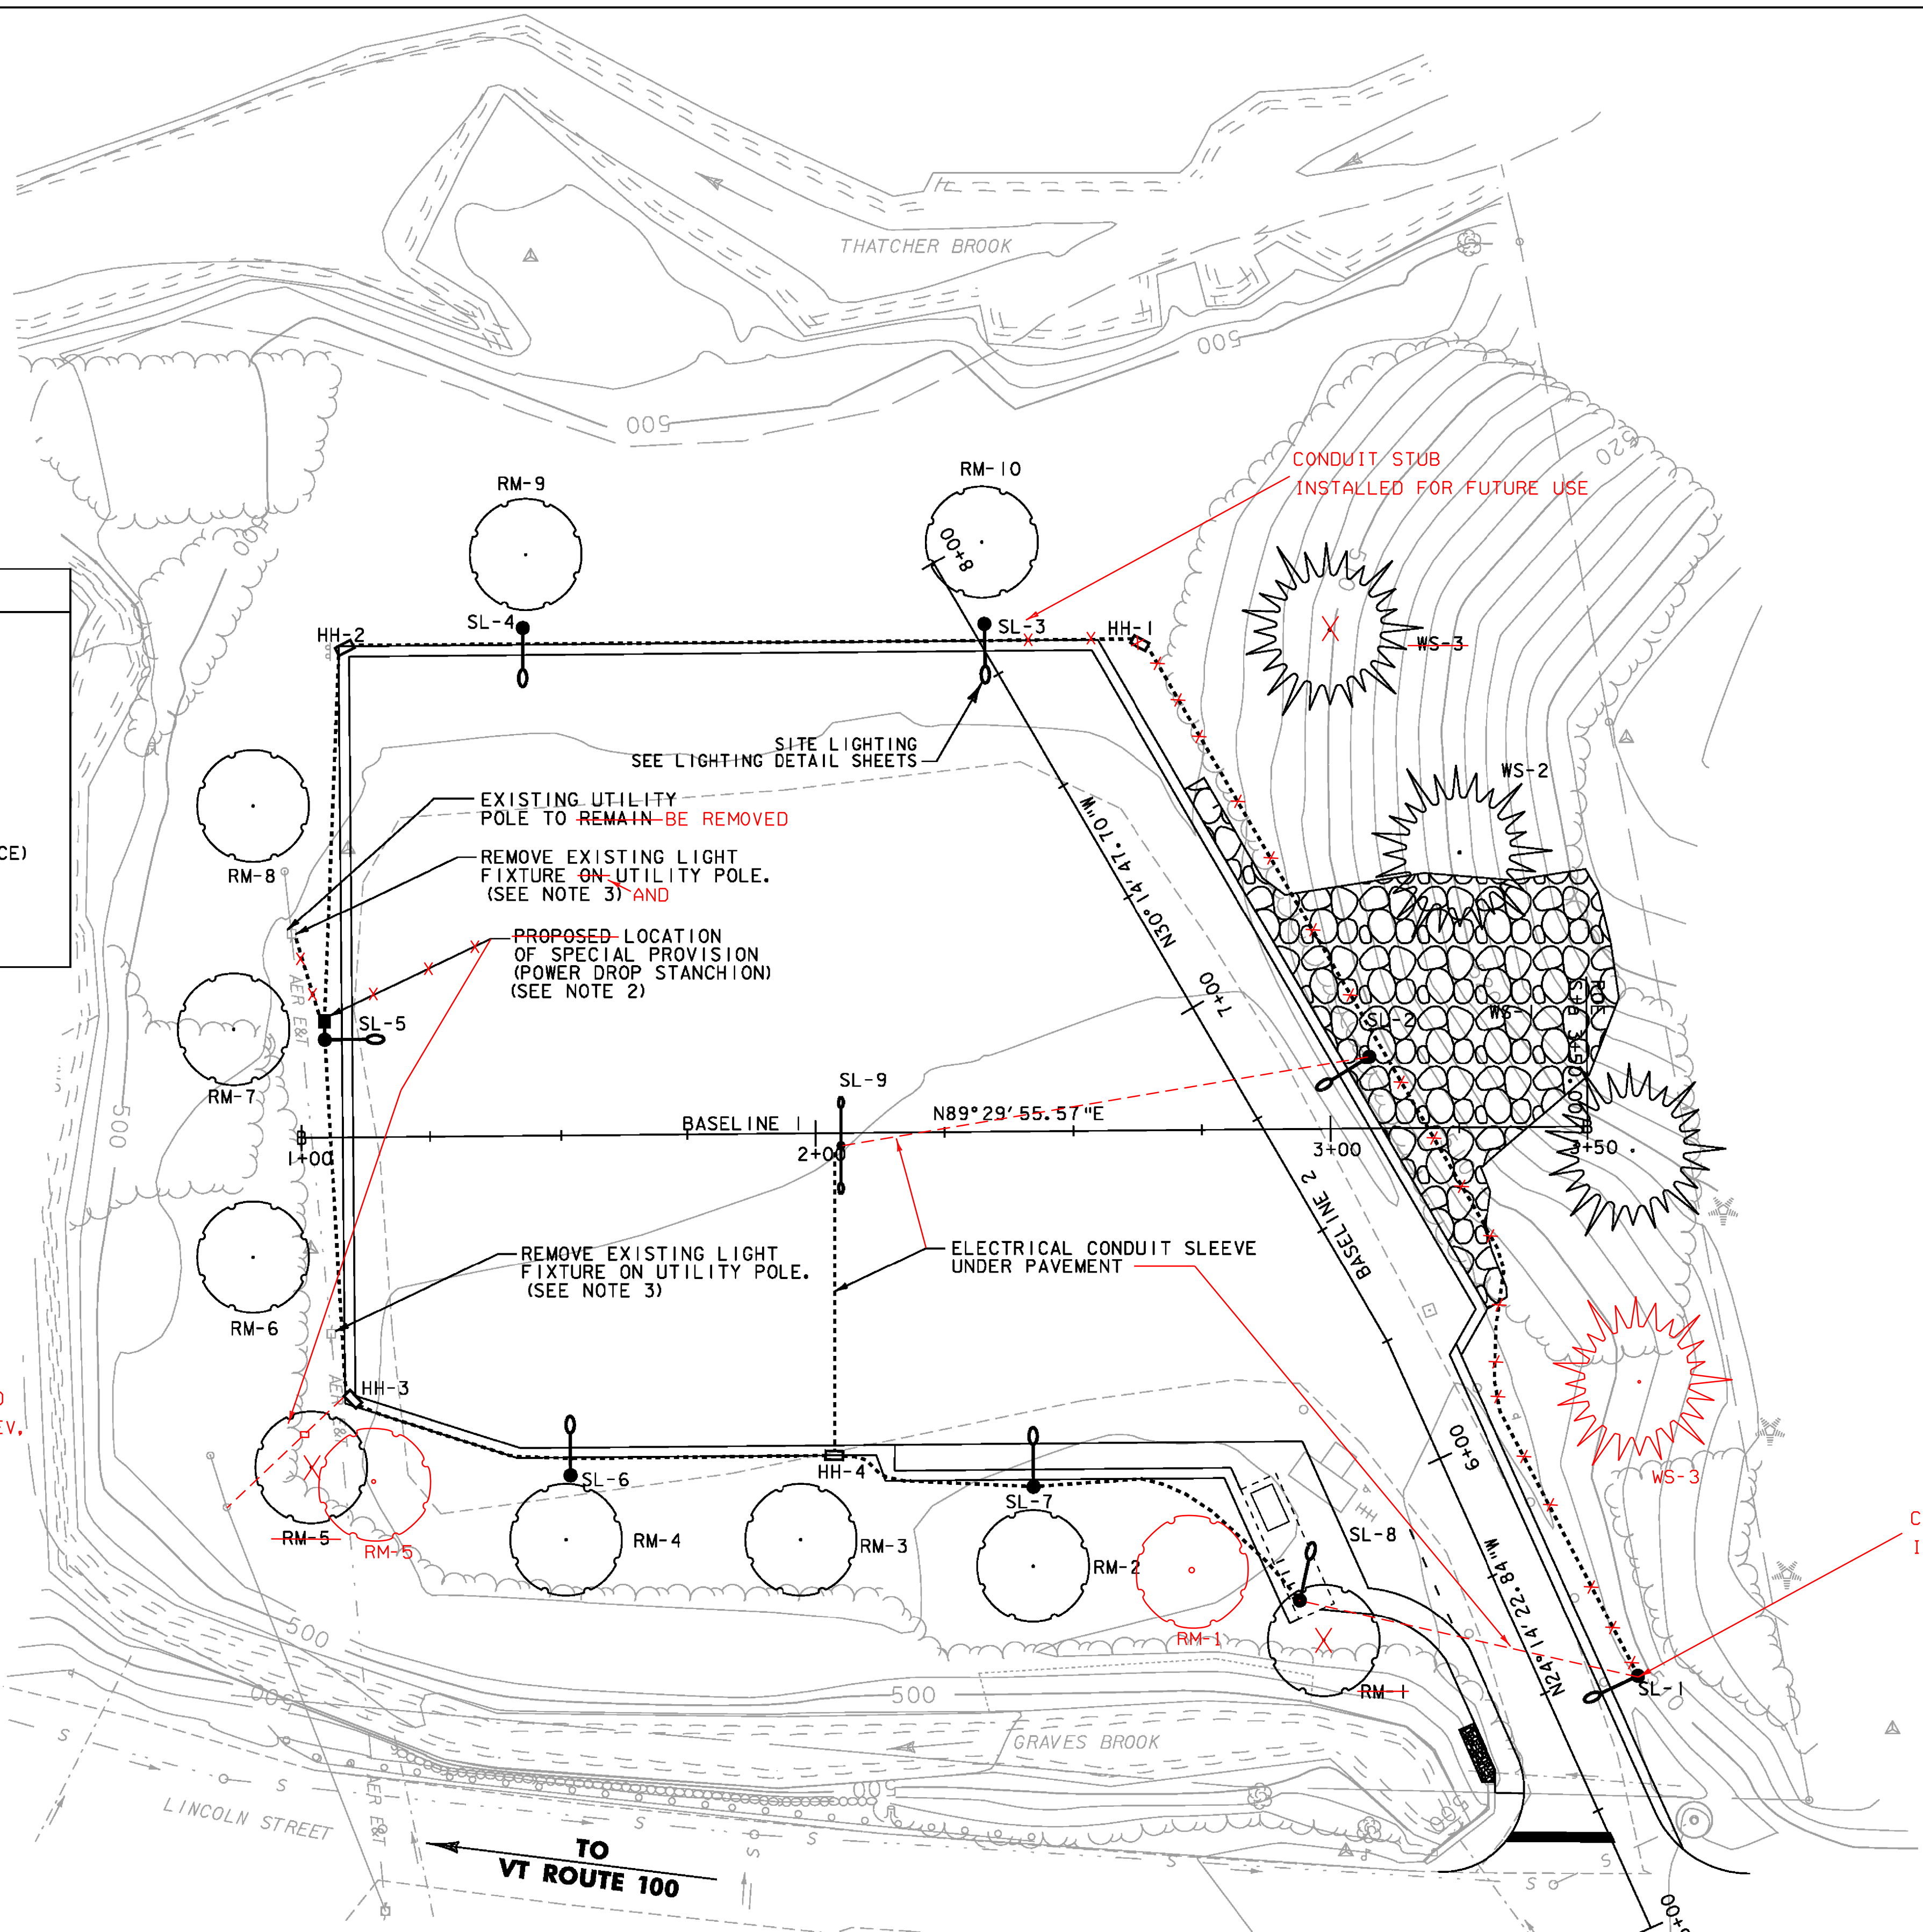

PROJECT NAME: WATERBURY  
 PROJECT NUMBER: CMG PARK(I)S RE-ADVERTISED  
 FILE NAME: zk002bdr.dgn  
 PROJECT LEADER: WLD  
 DESIGNED BY: BEM  
 LIGHTING, LANDSCAPING & UTILITY PLAN  
 PLOT DATE: 19-NOV-2009  
 DRAWN BY: BEM  
 CHECKED BY: AJB  
 SHEET 16 OF 32