





DSCN1225


LOOKING FROM SOUTH TO NORTH



DSCN1226

LOOKING FROM SOUTH TO WEST

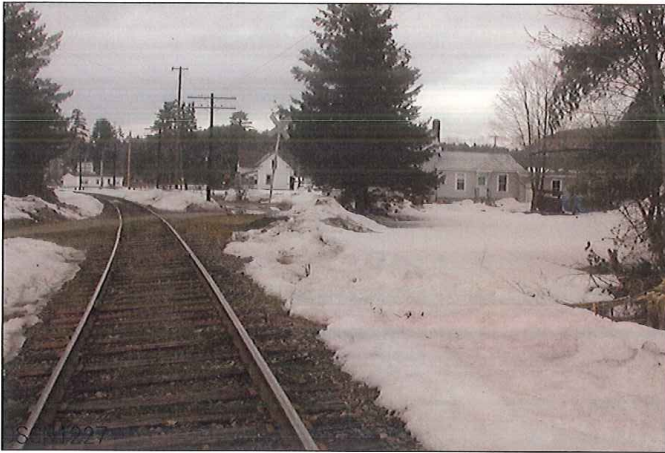

 PARSONS, BRINCKERHOFF, QUADE & DOUGLAS, INC. 75 Arlington St., Boston, MA	Drawing Title NORTHERN VERMONT RAILROAD LYNDONVILLE SUBDIVISION POWER PLANT XING				
	Power Service Meter No.: _____ Type Roadway Material: _____ Railweight in Crossing: _____ Roundel Size: _____	Railroad Crossing MP: 36.56	City/Town LYNDONVILLE	U.S. DOT. NO. 850-922L	
By: RO	Check By:	Drawn By: MYM	Scale: NTS	Date: 4-15-01	



LOOKING FROM SOUTH TO EAST



LOOKING FROM SOUTH TO NORTH



 PARSONS, BRINCKERHOFF, QUADE & DOUGLAS, INC. 75 Arlington St., Boston, MA	Drawing Title NORTHERN VERMONT RAILROAD LYNDONVILLE SUBDIVISION POWER PLANT XING				
	Power Service Meter No.: _____ Type Roadway Material: _____ Railweight in Crossing: _____ Roundel Size: _____	Railroad Crossing MP: 36.56	City/Town LYNDONVILLE	U.S. DOT. NO. 850-922L	
By: RO	Check By:	Drawn By: MYM	Scale: NTS		



LOOKING FROM SOUTH TO NORTH



LOOKING FROM NORTH TO SOUTH

 PARSONS, BRINCKERHOFF, QUADE & DOUGLAS, INC. 75 Arlington St., Boston, MA	Drawing Title NORTHERN VERMONT RAILROAD LYNDONVILLE SUBDIVISION POWER PLANT XING			
	Railroad Crossing MP: 36.56	City/Town LYNDONVILLE	U.S. DOT. NO. 850-922L	
Power Service Meter No.: _____ Type Roadway Material: _____ Railweight in Crossing: _____ Roundel Size: _____	By: RO	Check By: _____	Drawn By: MYM	Scale: NTS
				Date: 4-15-01
				NV-37-03





DSCN1229

LOOKING FROM NORTH TO EAST



DSCN1230

LOOKING FROM NORTH TO WEST



 PARSONS, BRINCKERHOFF, QUADE & DOUGLAS, INC. 75 Arlington St., Boston, MA	Drawing Title NORTHERN VERMONT RAILROAD LYNDONVILLE SUBDIVISION POWER PLANT XING				
	Power Service Meter No.: _____ Type Roadway Material: _____ Railweight in Crossing: _____ Roundel Size: _____	Railroad Crossing MP: 36.56	City/Town LYNDONVILLE	U.S. DOT. NO. 850-922L	
	By: RO	Check By: _____	Drawn By: MYM	Scale: NTS	Date: _____



LOOKING FROM EAST TO SOUTH



LOOKING FROM EAST TO NORTH



 PARSONS, BRINCKERHOFF, QUADE & DOUGLAS, INC. 75 Arlington St., Boston, MA	Drawing Title NORTHERN VERMONT RAILROAD LYNDONVILLE SUBDIVISION POWER PLANT XING				
	Power Service Meter No.: _____ Type Roadway Material: _____ Railweight in Crossing: _____ Roundel Size: _____	Railroad Crossing MP: 36.56	City/Town LYNDONVILLE	U.S. DOT. NO. 850-922L	
	By: RO	Check By: _____	Drawn By: MYM	Scale: NTS	Date: 4-15-01



LOOKING FROM WEST TO EAST





LOOKING FROM WEST TO NORTH

 PARSONS, BRINCKERHOFF, QUADE & DOUGLAS, INC. 75 Arlington St., Boston, MA	Drawing Title NORTHERN VERMONT RAILROAD LYNDONVILLE SUBDIVISION POWER PLANT XING				
	Power Service Meter No.: _____ Type Roadway Material: _____ Railweight in Crossing: _____ Roundel Size: _____	Railroad Crossing MP: 36.56	City/Town LYNDONVILLE	U.S. DOT. NO. 850-922L	
By: RO	Check By:	Drawn By: MYM	Scale: NTS		



LOOKING FROM WEST TO SOUTH

 PARSONS, BRINCKERHOFF, QUADE & DOUGLAS, INC. 75 Arlington St., Boston, MA	Drawing Title NORTHERN VERMONT RAILROAD LYNDONVILLE SUBDIVISION POWER PLANT XING				
	Railroad Crossing MP: 36.56	City/Town LYNDONVILLE	U.S. DOT. NO. 850-922L	County CALEDONIA	
Power Service Meter No.: _____ Type Roadway Material: _____ Railweight in Crossing: _____ Roundel Size: _____	By: RO	Check By: MYM	Scale: NTS	Date: 4-15-01	