



DETAIL ~ FUEL DISPENSER
1" = 3'



SITE PLAN
1" = 80'

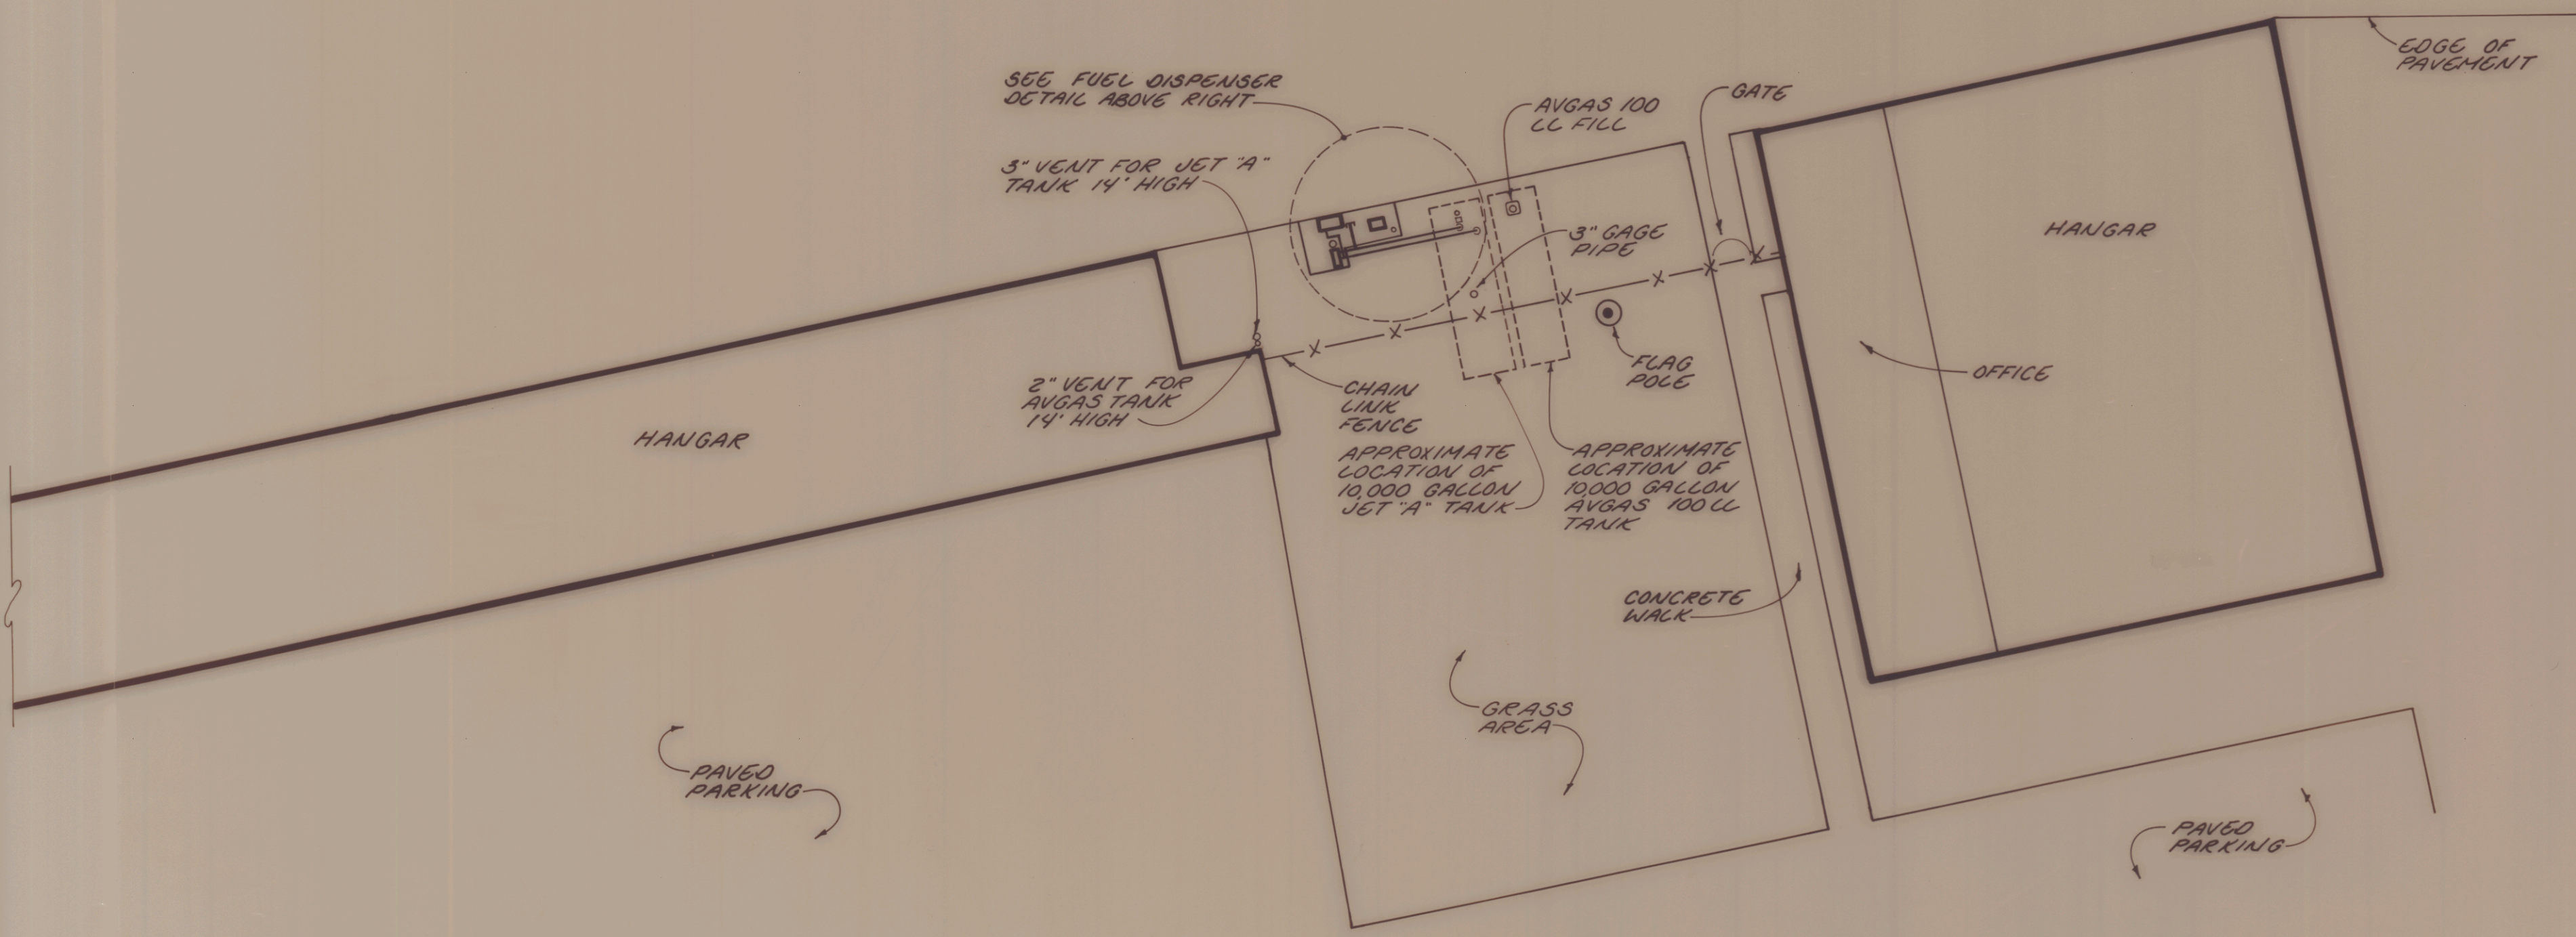

VICINITY MAP
1" = 1 MILE

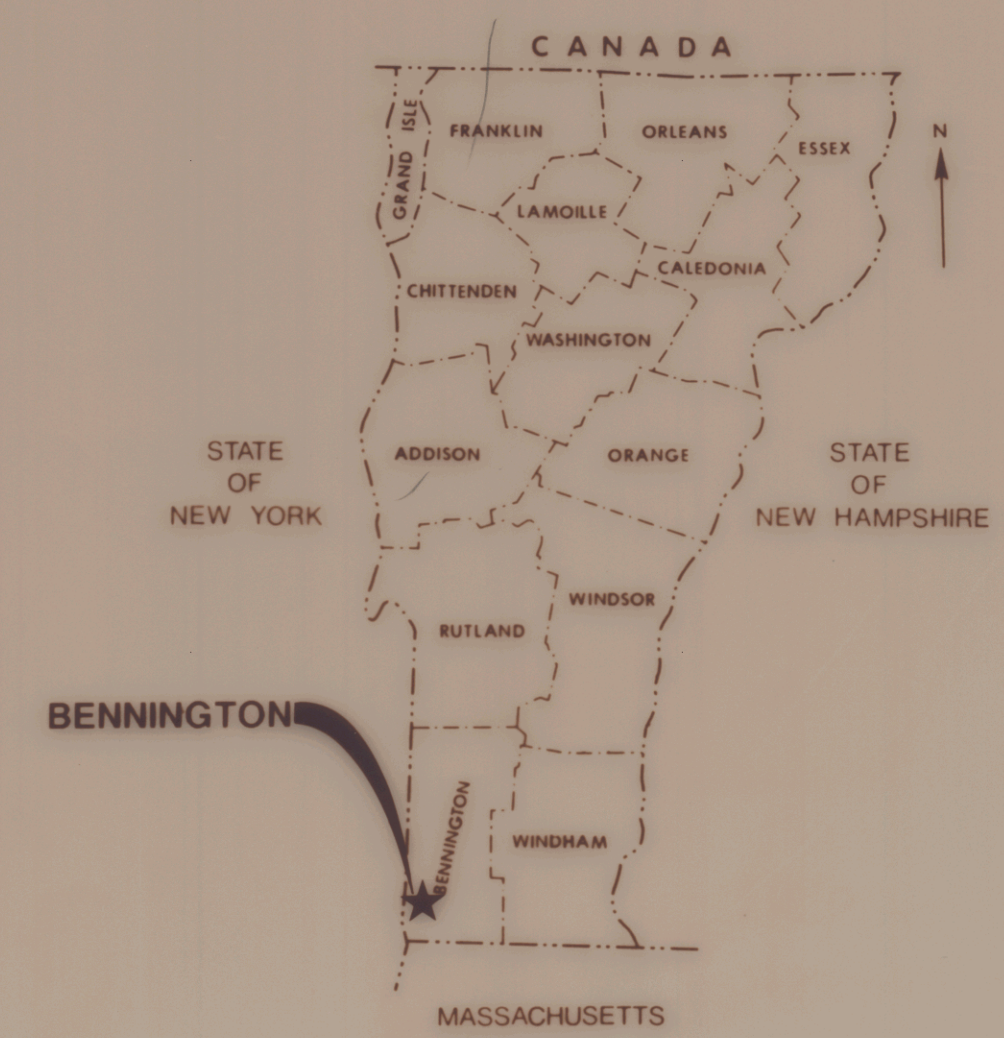

LOCATION MAP
NOT TO SCALE

NOTE: THIS DRAWING REPRESENTS EXISTING FEATURES ON THE DATE OF THE SITE INSPECTION BY DUFFESNE-HENRY. IT IS A COMPILATION DRAWING BASED ON INFORMATION PROVIDED BY THE VERMONT AGENCY OF TRANSPORTATION, THE SYSTEM OPERATOR, AND VERIFIED BY FIELD INSPECTION.



VERMONT AGENCY OF TRANSPORTATION
FUEL SYSTEM STUDY
BENNINGTON STATE AIRPORT
BENNINGTON, VERMONT

 Duffesne-Henry Inc. Precision Park No. Springfield, Vermont 05150	Client No.	217016	 STATE OF VERMONT PETER W. ANDREWS No. 3785 REGISTERED PROFESSIONAL ENGINEER
	Proj. Manager	T.S. REEVES	
	Proj. Designer	T.S. REEVES	
	Drawn By	W. HAZLETT	
	Checked By	P.M. ANDREWS	
	Scale	AS SHOWN	
Approved		Sheet 1 of 11	
Date	FEBRUARY 1, 1988	D	11.166

Rev.	Description	By	Date