


NO.	DATE	DESCRIPTION	BY
1	12/17/84	REVISED	SA MULLER
2	01/20/85	REVISED	SA MULLER
3	02/13/85	REVISED	SA MULLER
4	03/11/85	REVISED	SA MULLER
5	03/11/85	REVISED	SA MULLER
6	03/11/85	REVISED	SA MULLER
7	03/11/85	REVISED	SA MULLER

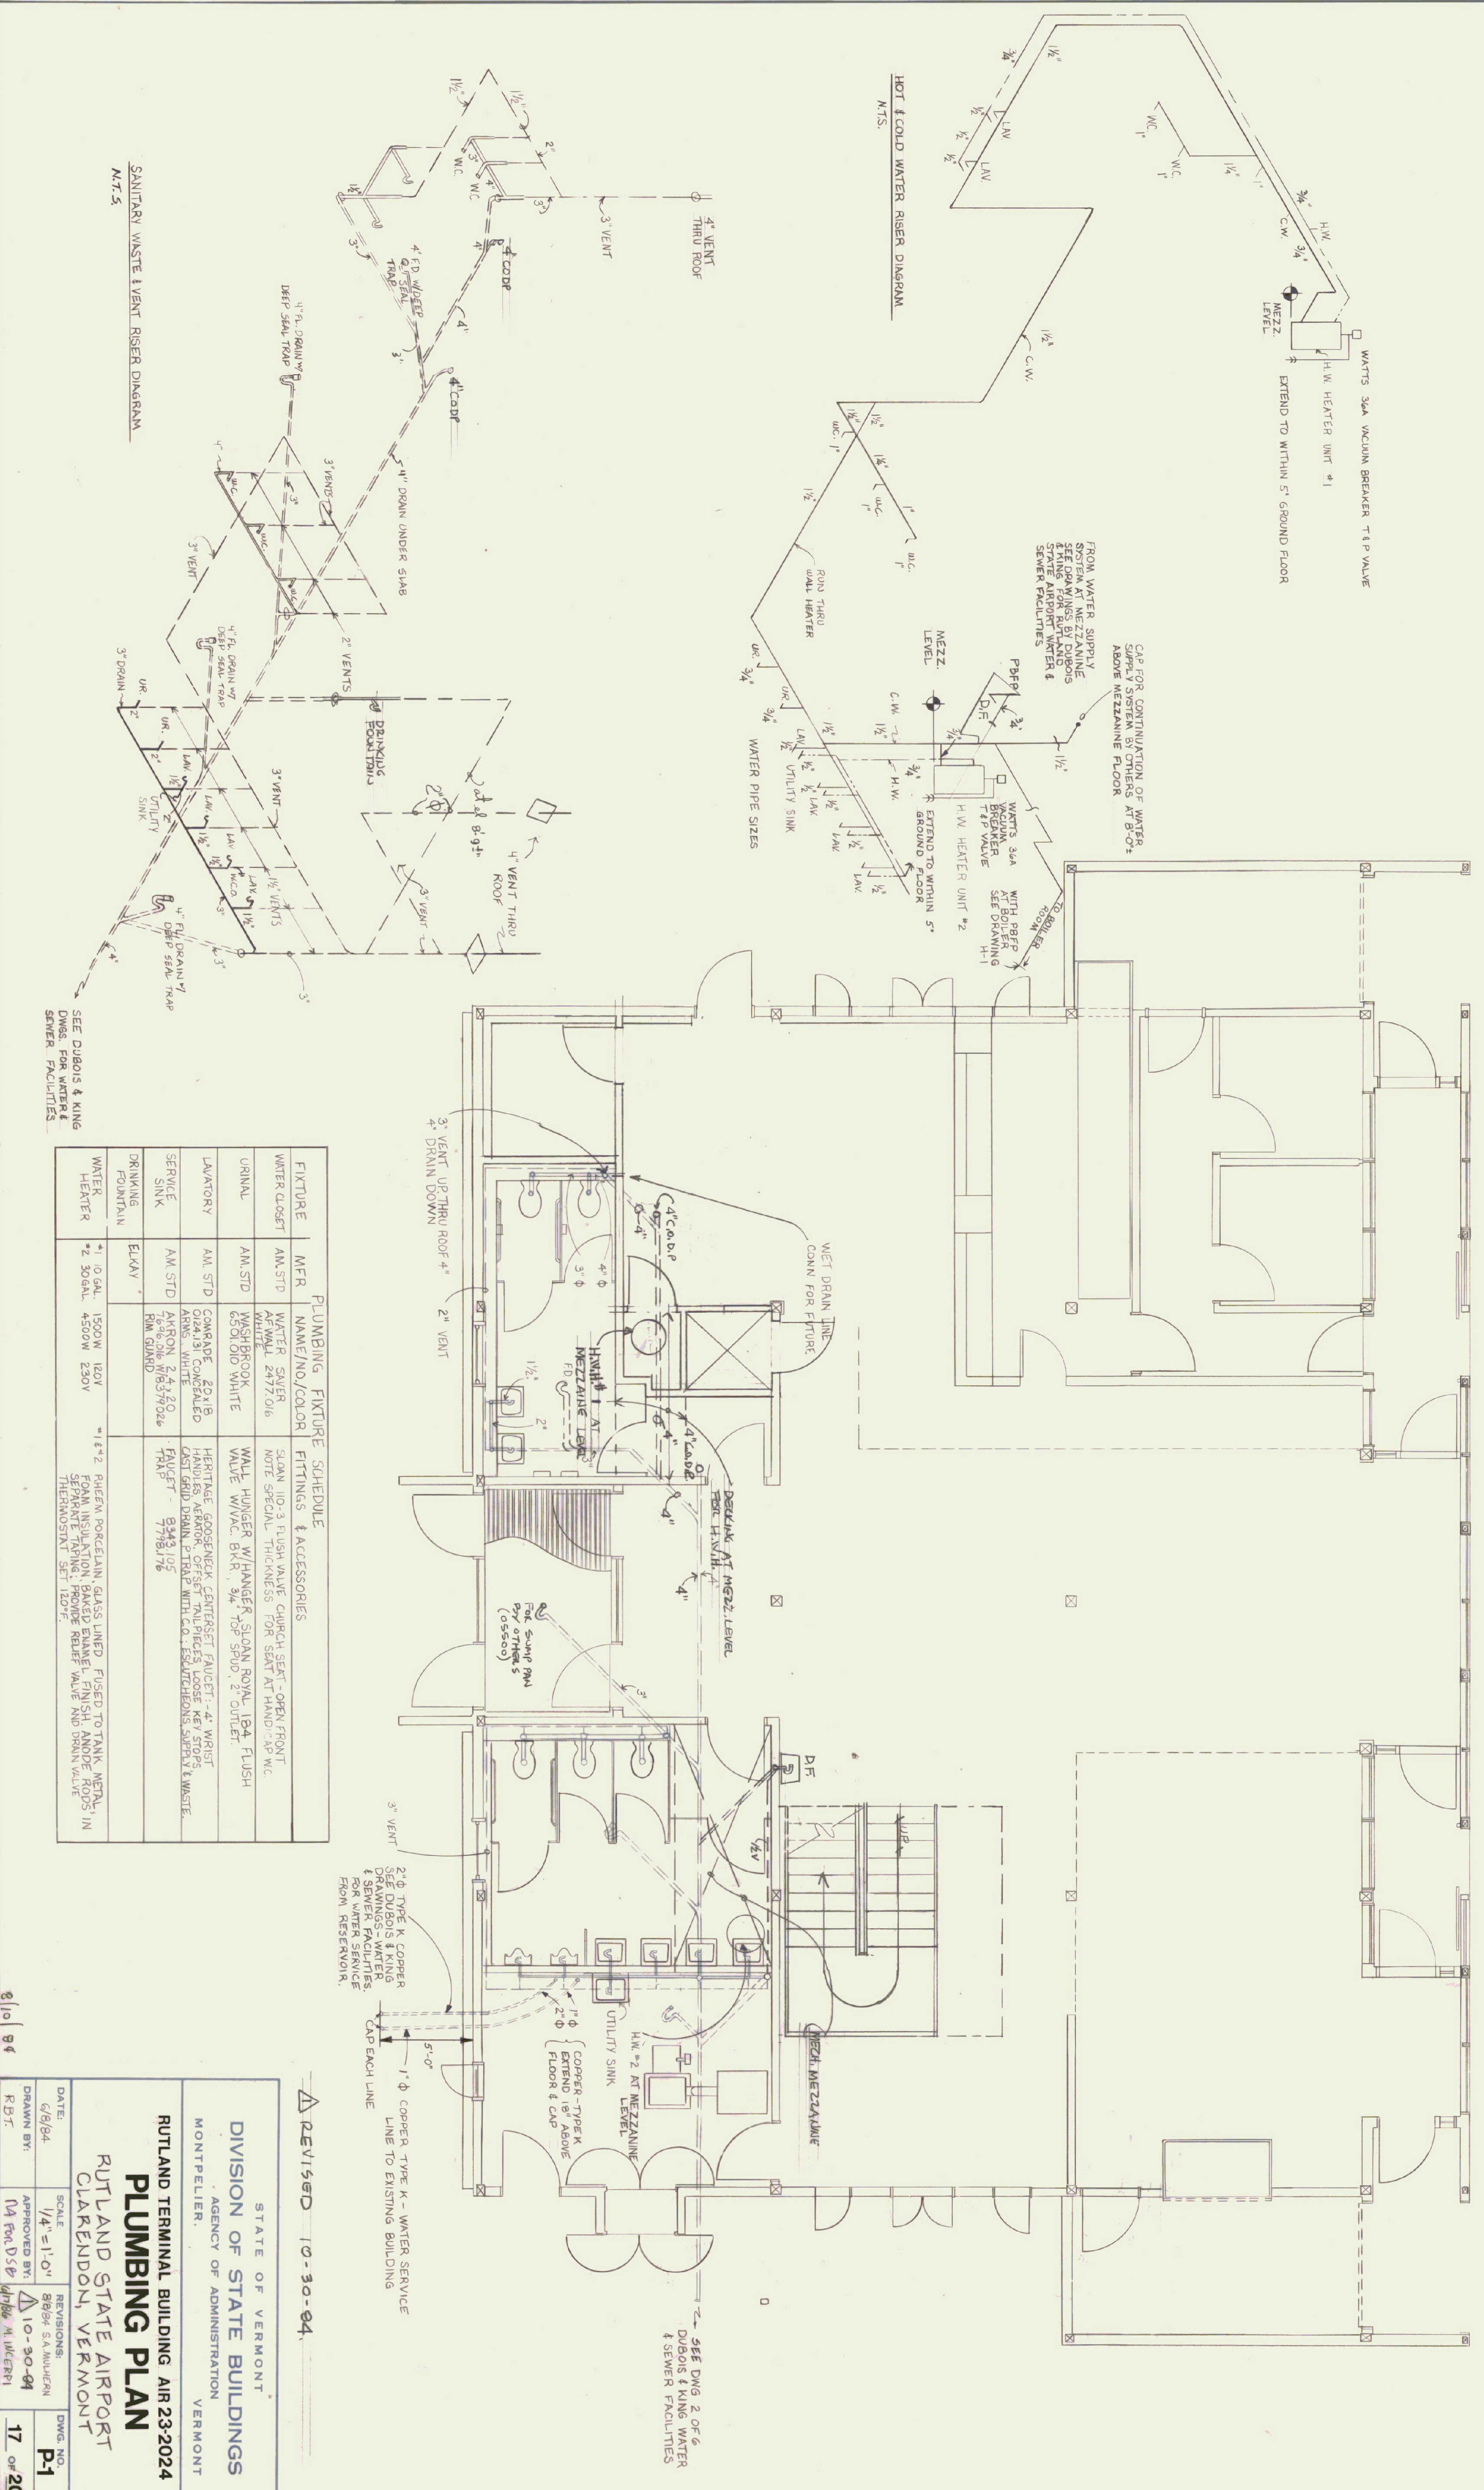

PLUMBING FIXTURE SCHEDULE

FIXTURE	MFR	NAME/NO./COLOR	FITTINGS & ACCESSORIES
WATER CLOSET	AM STD	WATER SAVER AF WALL 2472 016	SLAM 110-3 FLUSH VALVE CHURCH SEAT - OPEN FRONT NOTE SPECIAL THICKNESS FOR SEAT AT HAND CAP WC
URINAL	AM STD	WASHBROOK 6501 010 WHITE	WALL HUNGER W/ HANGER SLOAN ROVAL 184 FLUSH VALVE W/VAC. BKN. 1/2" 18" 3" 2" 2" OUTLET.
LAVATORY	AM STD	COMRADE 20-118 024131 CONCEALED ARNS. WHITE	HERITAGE GOOSENECK CENTERSET FAUCET - 4" WRIST HANDLES ARMOR. OFFSET TAILPIECES LOOSE KEY STOPS CAST GRID DRAIN. PTRAP WITH C.O. ESCUTCHIONS SUPPLY & WASTE.
SERVICE SINK	AM STD	AKRON 2-4 20 6348 SINK W/8379026 FIN. GRANO	FAUCET - 8343 105 7781 176 TRAP
DRINKING FOUNTAIN	ELKAY		
WATER HEATER	1 - 10 GAL. 1500W 120V 2 - 30 GAL. 4500W 230V		1 - 1/2" 2" PHEM PORCELAIN GLASS LINED FLUSH TO TANK METAL IN PHEM INSULATION BAKED ENAMEL FINISH AND DRN RODS IN SEPARATE TANKING. PROVIDE RELIEF VALVE AND DRAIN VALVE THERMOSTAT SET 120°F.

SANITARY WASTE & VENT RISER DIAGRAM
N.T.5

HOT & COLD WATER RISER DIAGRAM
N.T.S.

REVISION 10-30-84

STATE OF VERMONT
DIVISION OF STATE BUILDINGS
AGENCY OF ADMINISTRATION
MONTPELIER, VERMONT

RUTLAND TERMINAL BUILDING AIR 23-2024
PLUMBING PLAN
RUTLAND STATE AIRPORT
CLARENDON, VERMONT

DATE: 6/8/84
SCALE: 1/4" = 1'-0"
DRAWN BY: 88/88 SA MULLER
APPROVED BY: 10-30-84
R.B.T. NA FAC D 5/8
AS BUILT

DWG. NO. P-1
17 OF 20