





FLOOR PLAN
SCALE: 1/8" = 1'-0"

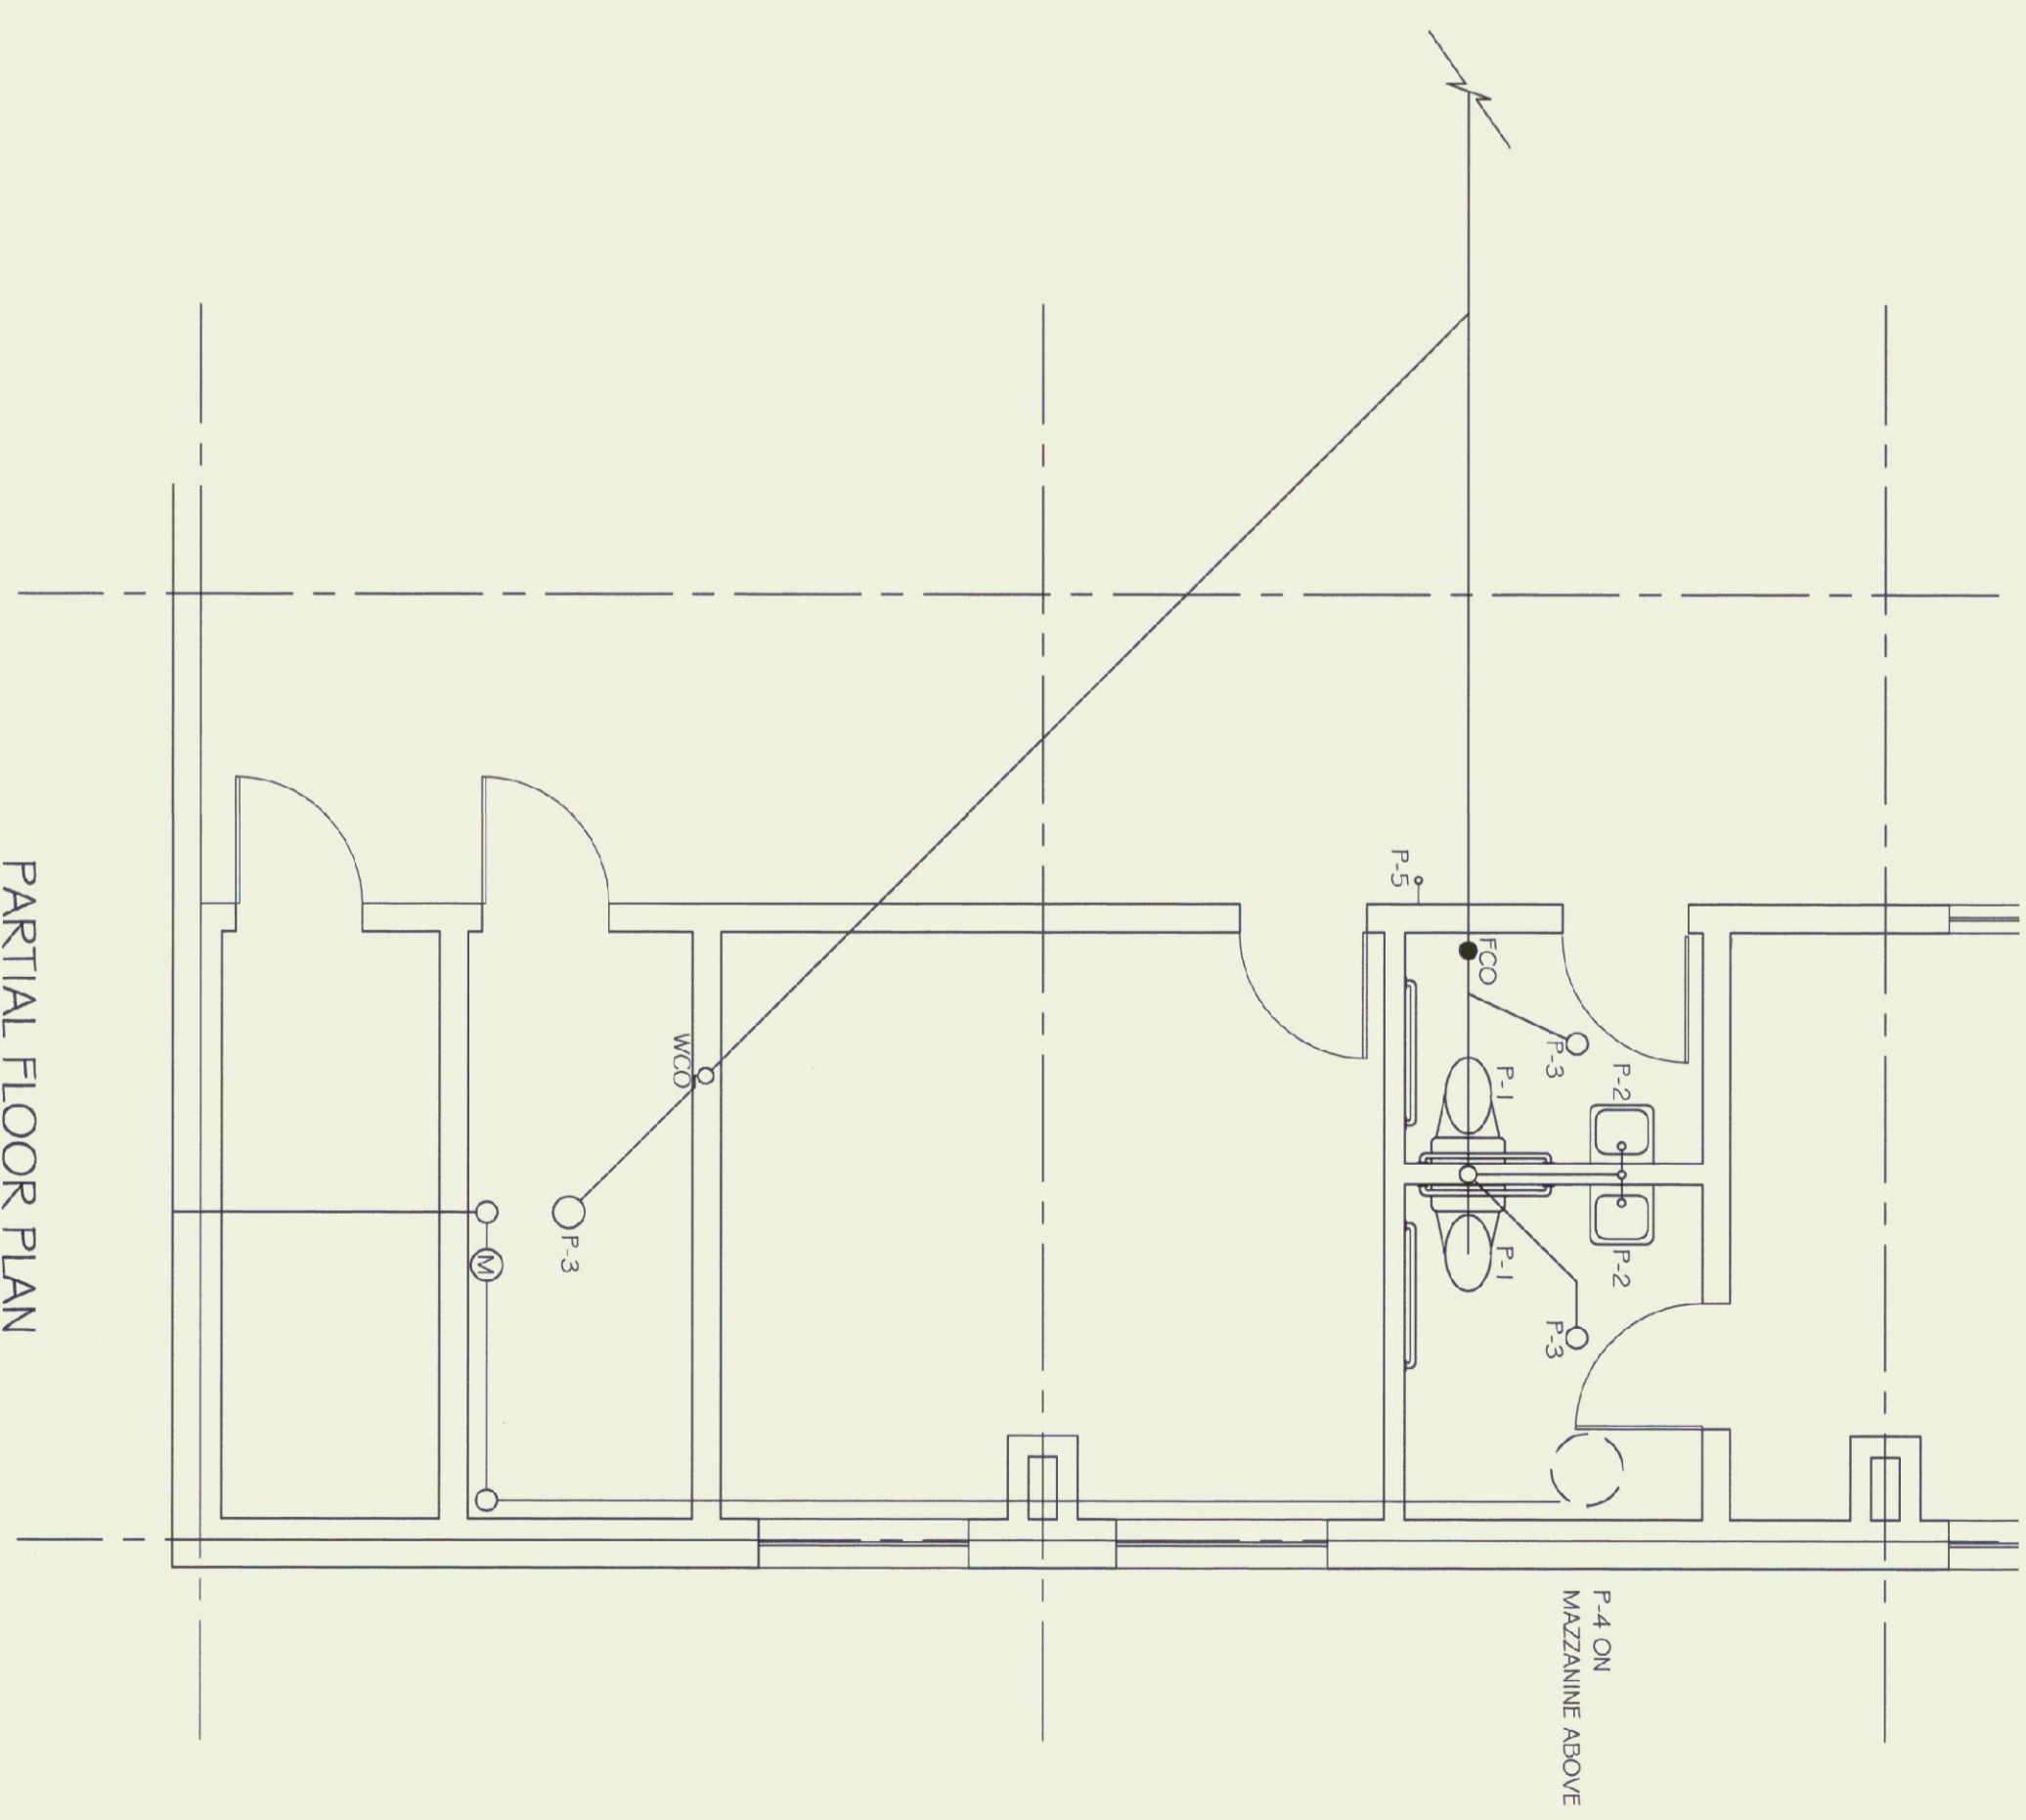


PARTIAL FLOOR PLAN
SCALE: 1/4" = 1'-0"

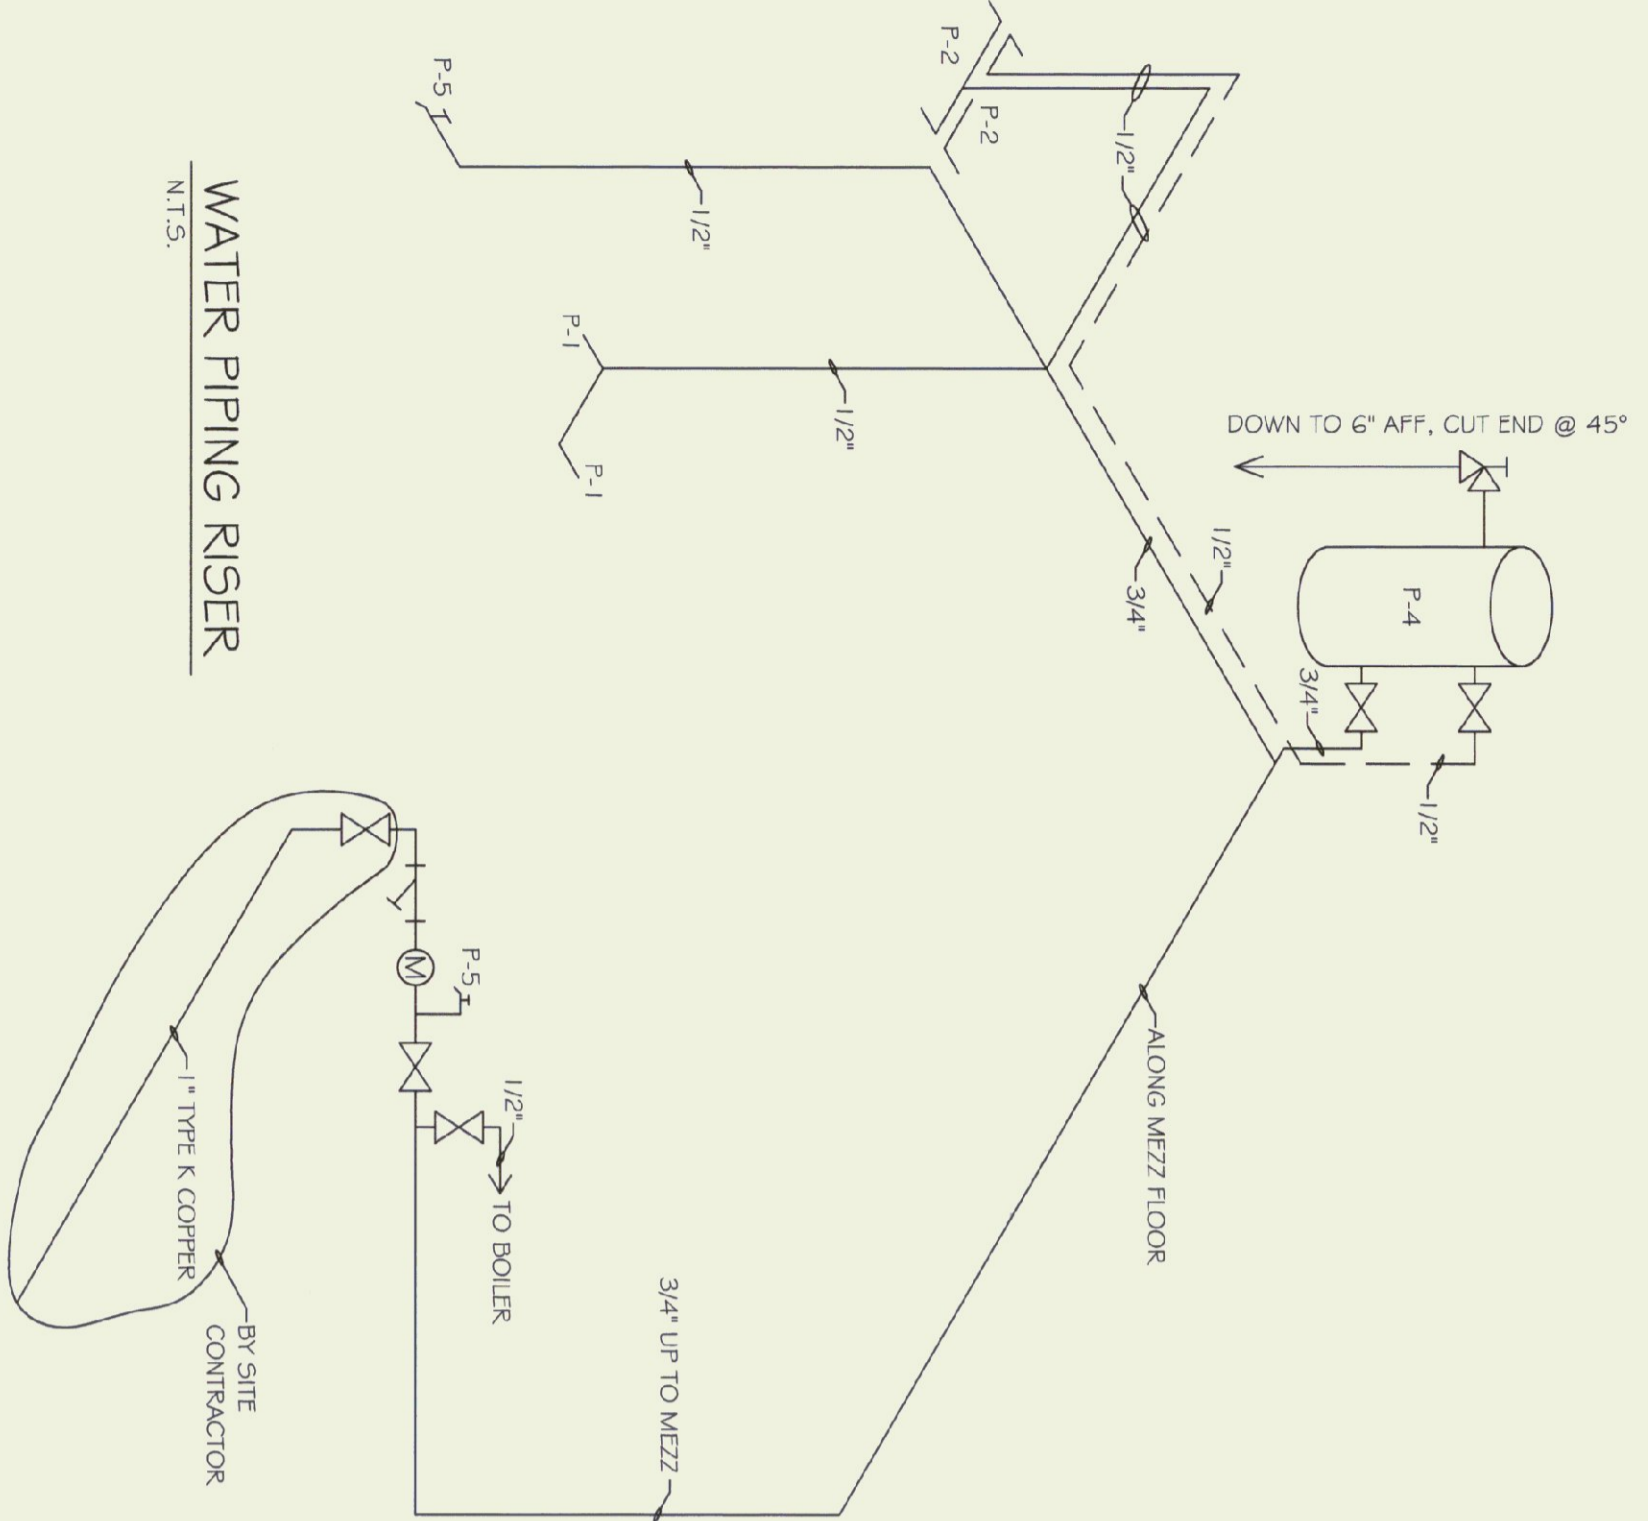

WATER PIPING RISER
N.T.S.

FIXTURE SCHEDULE

| SYMBOL | FIXTURE | DESCRIPTION | CW | HW | WASTE | VENT | REM |
|--------|--------------|---|------|------|-------|--------|-----|
| P-1 | TOILET | AMERICAN STANDARD TOILET # 2168 100 WHITE VITREOUS CHINA, HANDICAP FLOOR MOUNT, TANK TYPE, PRESSURE ASSISTED, ELONGATED, WATERSAVER, FLOOR MOUNT, CLOSURE, 12\"/> | | | | | |
| P-2 | LAVATORY | AMERICAN STANDARD TOILET # 032 1 026 WALL HUNG, WHITE VITREOUS CHINA, SINGLE LEVER CONTROL, W/OP UP DRAIN # P-TRAP AMERICAN STANDARD RELIENT # MODEL # 2305 000 | 1/2" | 1/2" | 2" | 1-1/4" | |
| P-3 | FLOOR DRAIN | SLOTTED ROUND COVER, DRAIN SHALL DISCHARGE THROUGH A P-TRAP OUTLET OF P-TRAP SHALL HAVE A TWO INCH DRAIN WITH INTEGRAL FLOOR CLEANOUT. | | | 2" | 1-1/4" | |
| P-4 | WATER HEATER | BRADYOKED WHITE 6 GALLON ELECTRIC M41J595 | 3/4" | 1/2" | | | |
| P-5 | HOSE BIBB | WATTS SR. 1 WSCS-1 VACUUM BREAKER | 1/2" | | | | |

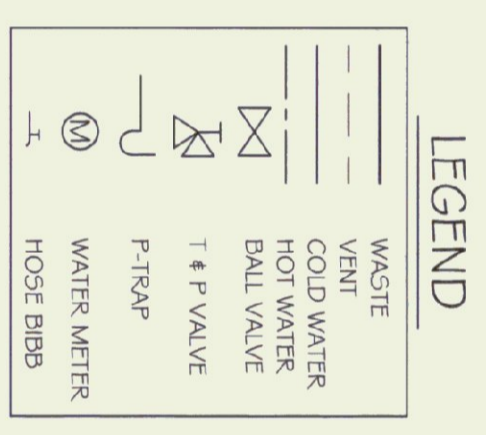

WASTE RISER DIAGRAM
N.T.S.

