


REFUELING ACCESS ROAD INTERSECTION
SCALE 1" = 20'

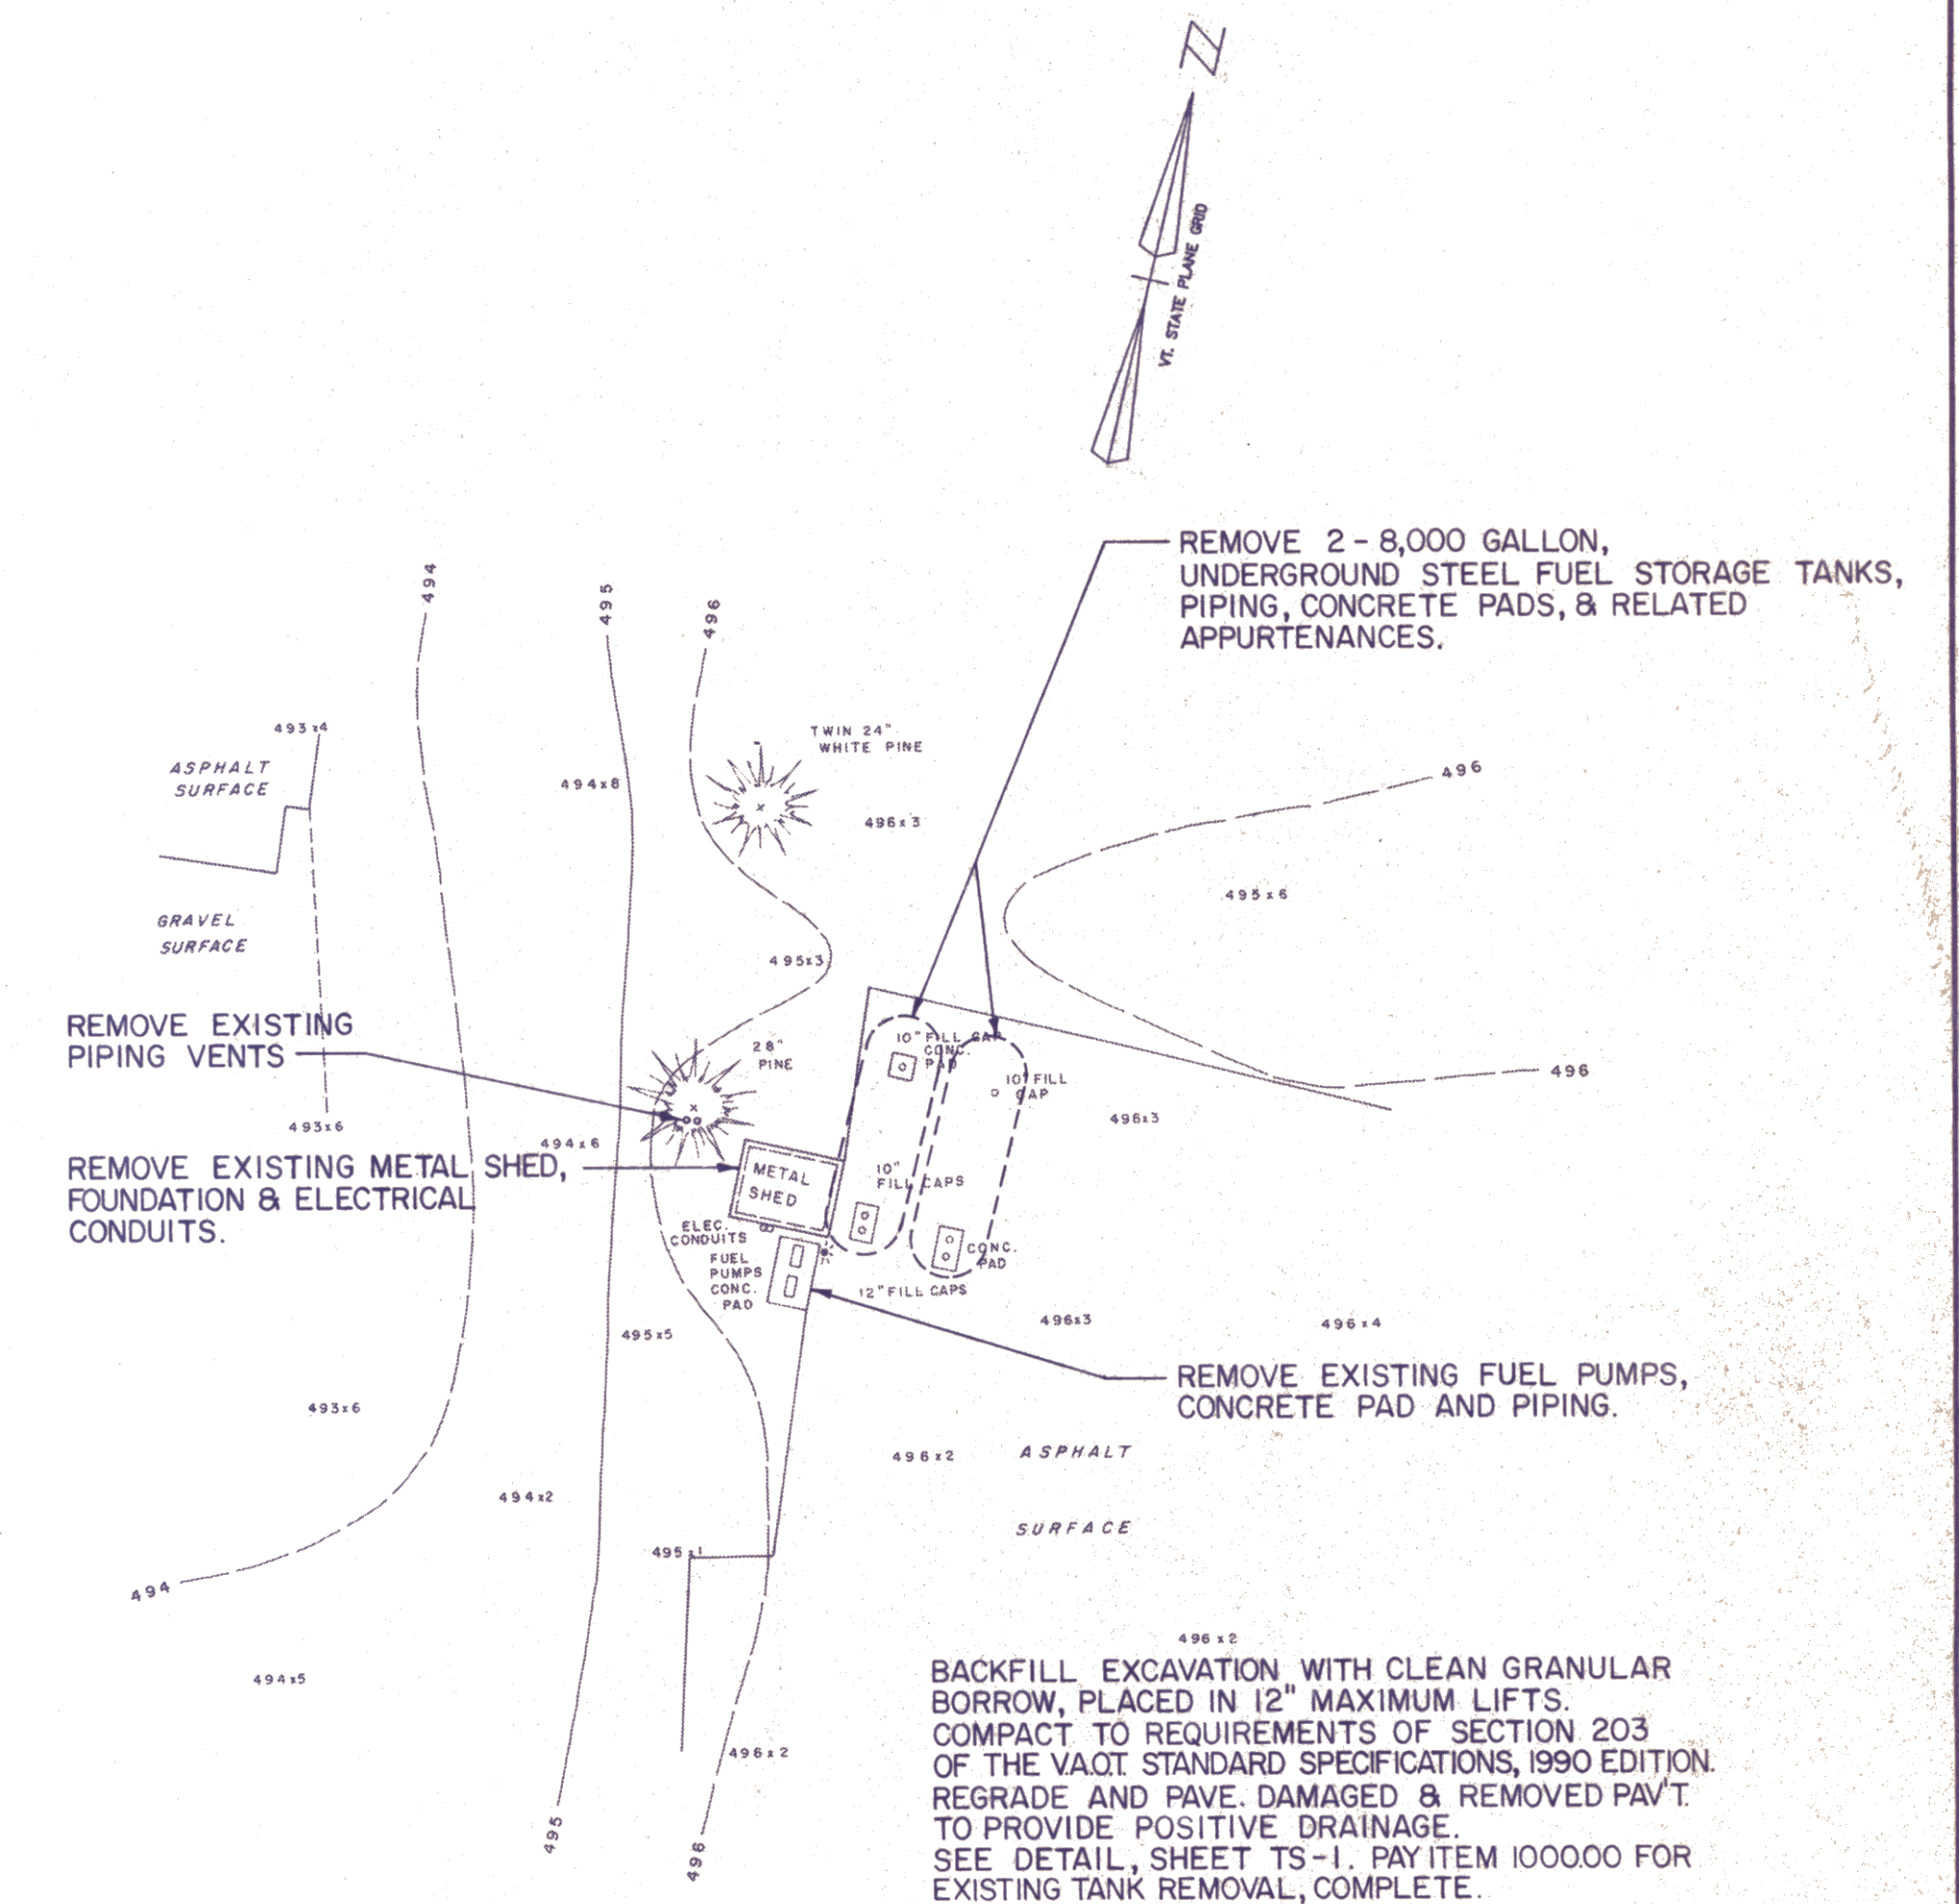

EXISTING STORAGE TANK REMOVAL PLAN
SCALE 1" = 20'

NO.		REVISION	BY	DATE	<p style="text-align: center;">SITE PLAN</p> <p style="text-align: center;">MIDDLEBURY STATE AIRPORT FUELING SYSTEM A.I.R. 03-2069 TOWN OF MIDDLEBURY</p>								
NO.		REVISION	BY	DATE									
<p style="text-align: center;">STATE OF VERMONT LARRY V. FAIRFIELD No. 5653 REGISTERED PROFESSIONAL ENGINEER</p>					<p style="text-align: center;">CHA CLOUGH, HARBOUR & ASSOCIATES ENGINEERS & PLANNERS 3 WINNERS CIRCLE - ALBANY, N.Y. 12205</p>								
PROJECT		1981-03	DATE		JULY 1990	SCALE	AS SHOWN	DWG	SP-2	SHEET	3	OF	10