




FOUNDATION PLAN  
SCALE: 1/8" = 1'-0"

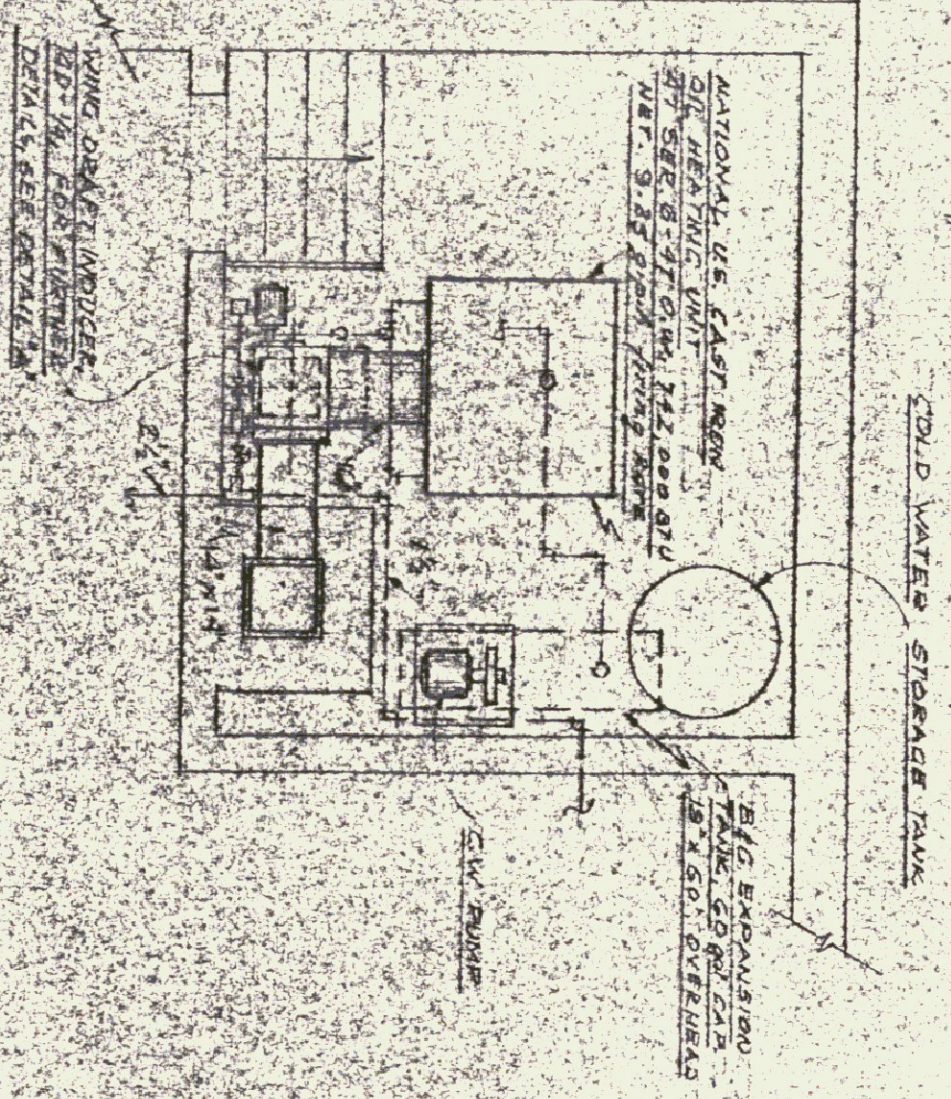


BOILER ROOM PLAN  
SCALE: 1/4" = 1'-0"

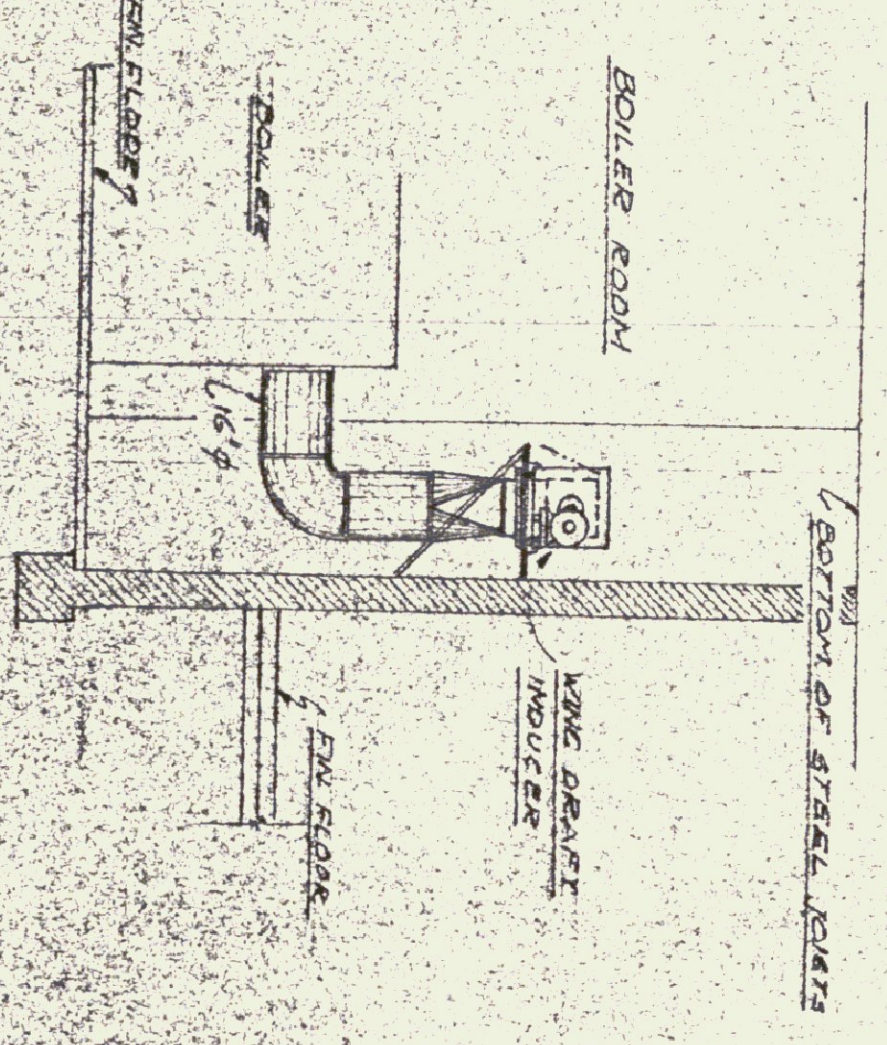


DETAIL A  
SCALE: 1/4" = 1'-0"

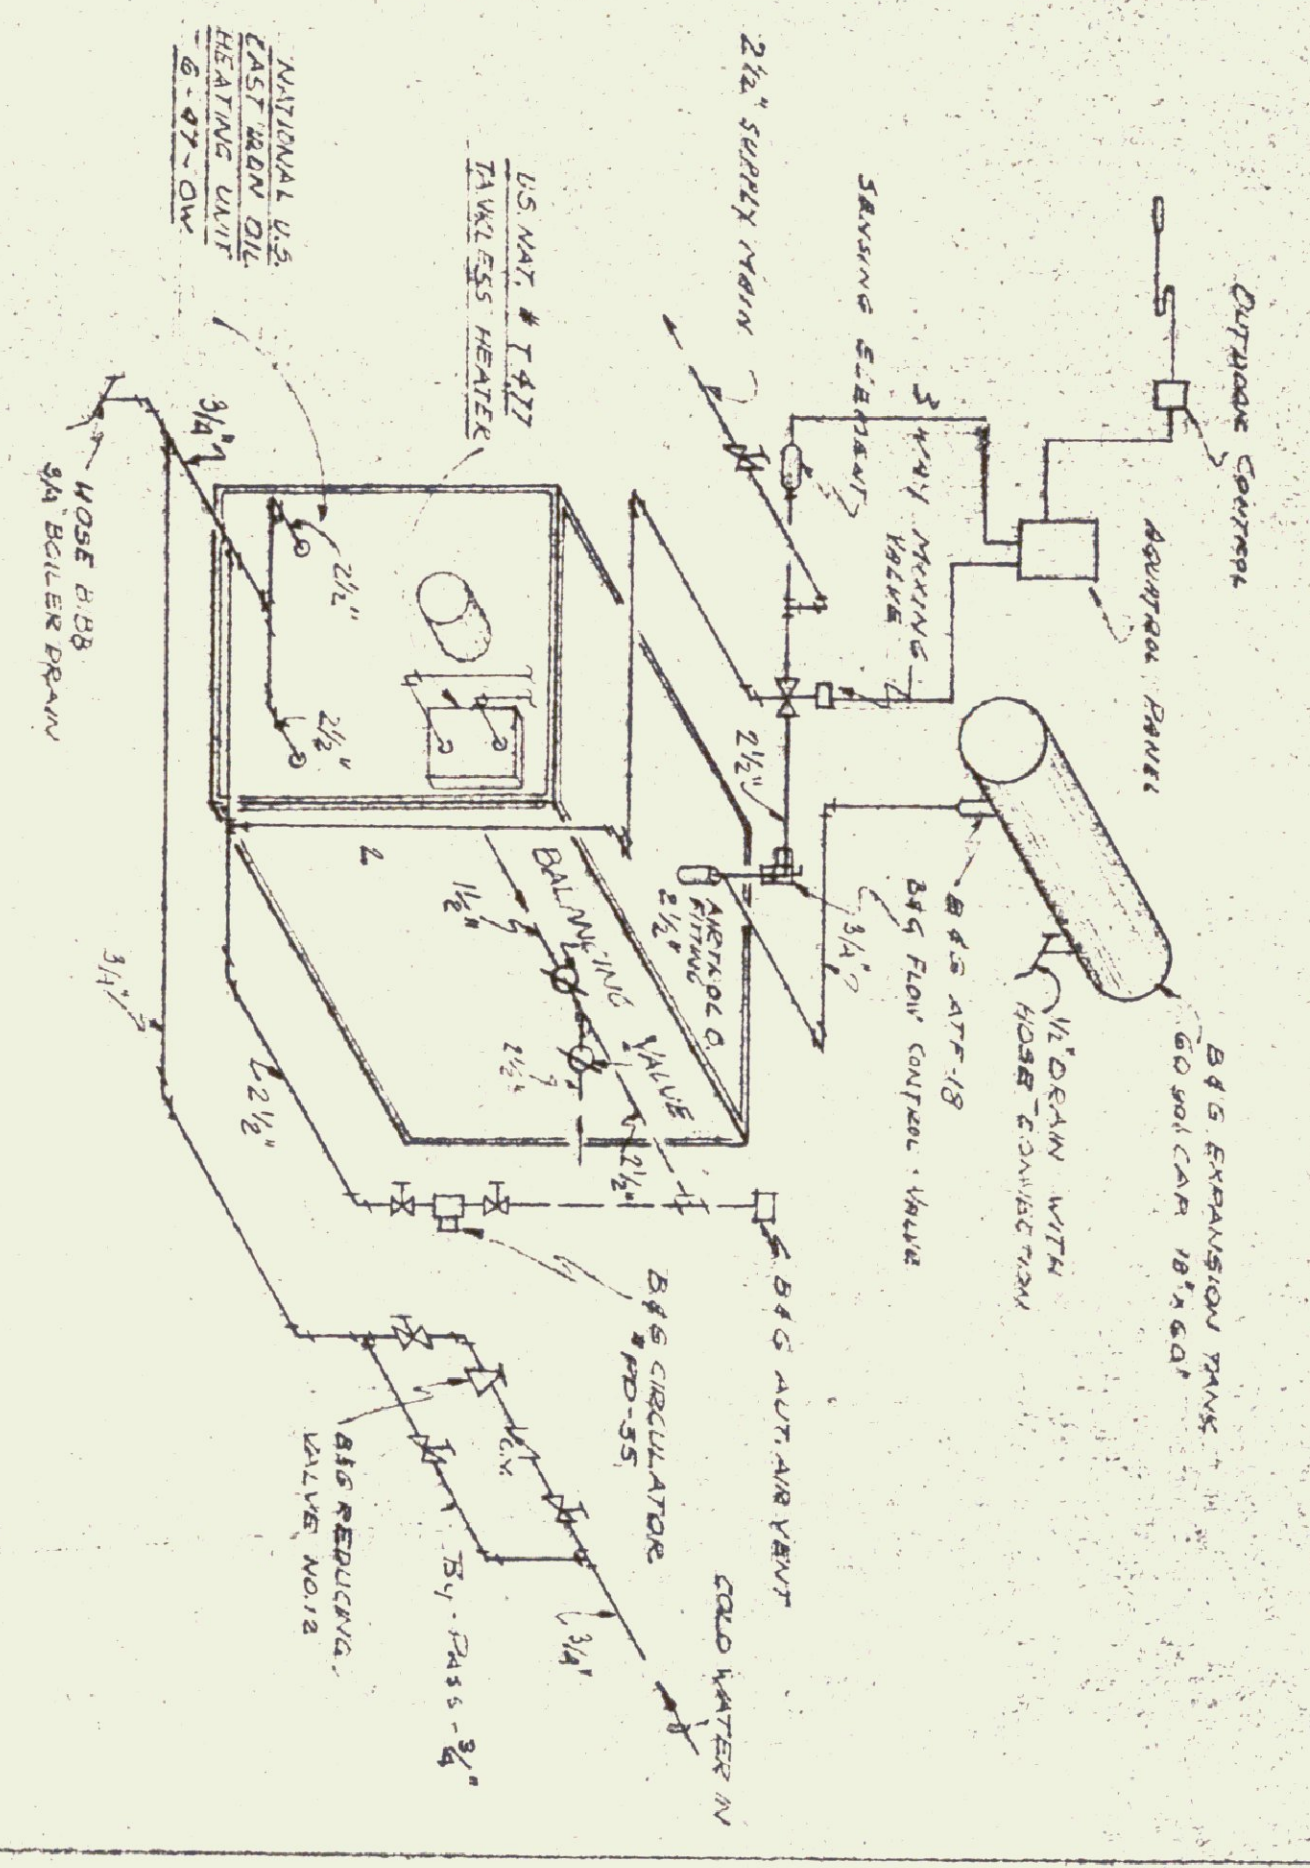

BOILER PIPING DIAGRAM  
SCALE: 1/4" = 1'-0"

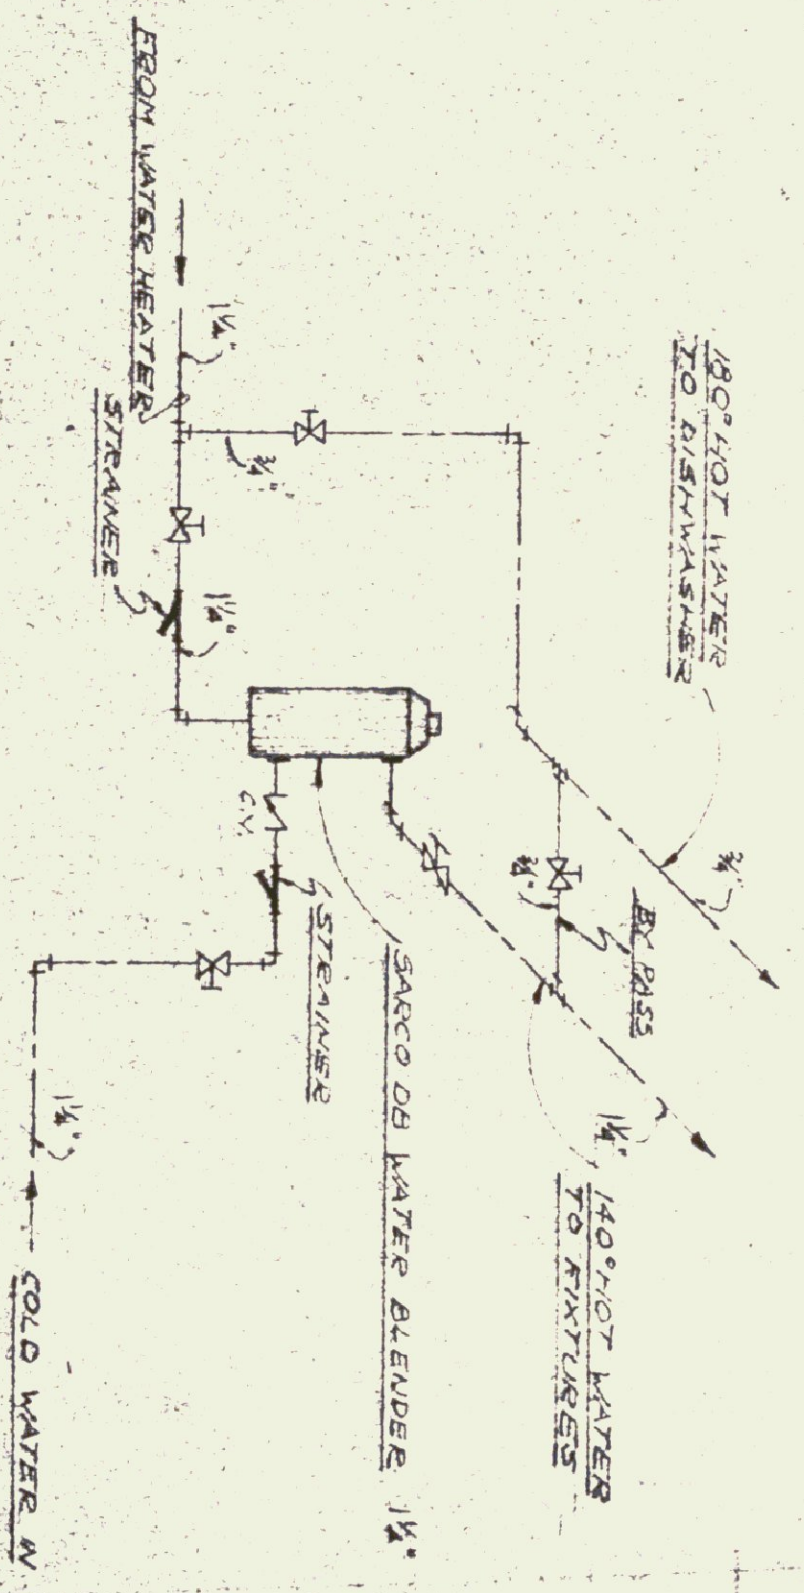


WATER BLENDER DETAIL  
SCALE: 1/4" = 1'-0"

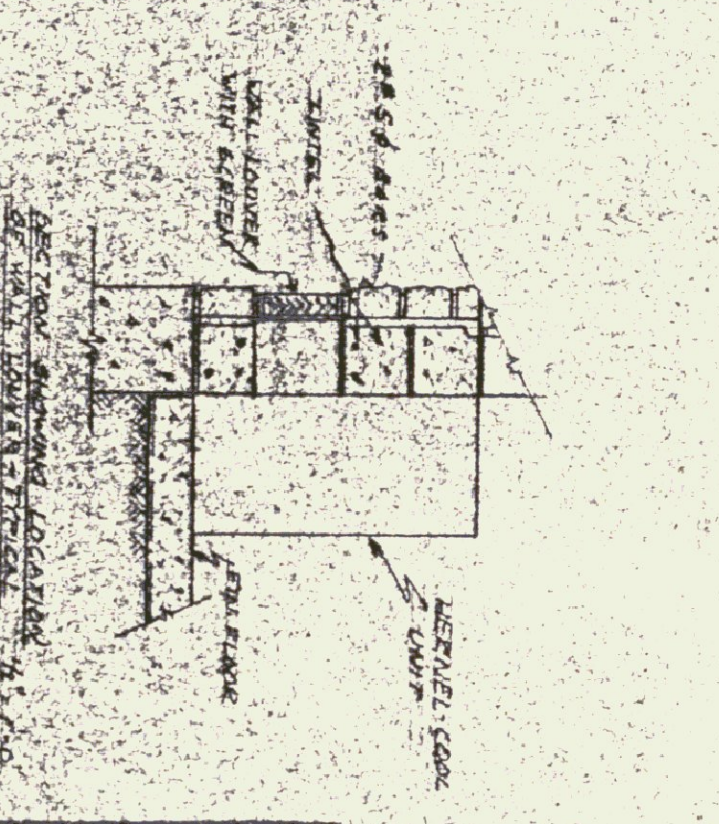

DETAIL B  
SCALE: 1/4" = 1'-0"

SCHEDULE "A"  
HEATING LAYOUT

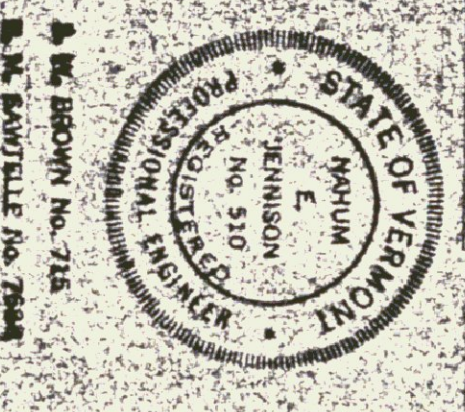

"AS CONSTRUCTED" PLANS  
I hereby certify that all construction required by this sheet has been accomplished as indicated hereon.  
Date: 1/12/52  
Gordon G. Woods, Architect

SYMBOLS

	HOT WATER SUPPLY LINE
	HOT WATER RETURN LINE
	GATE VALVE
	CHECK VALVE
	THERMOSTAT

NEW LEAH VALLEY BUILDING  
R.R. WOODVILLE VERMONT  
JENKINSON ENGINEERING INC.  
CONSULTING ENGINEERS  
15 QUINCY ST. BURLINGTON, VT. 05401  
DATE: 1/12/52  
SHEET NO. 4/1