




VICINITY MAP
1" = 1 MILE

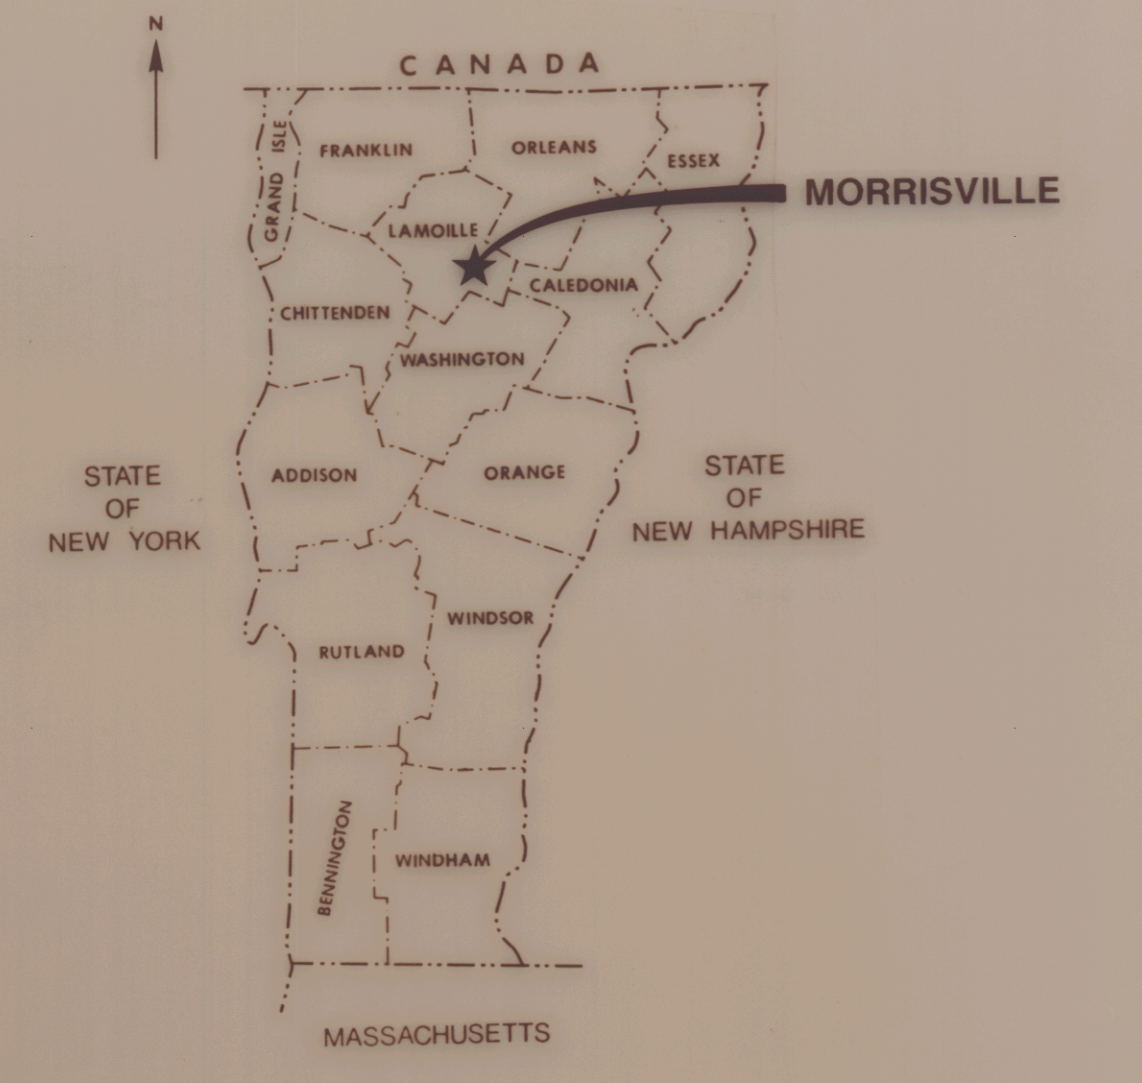

LOCATION MAP
NOT TO SCALE

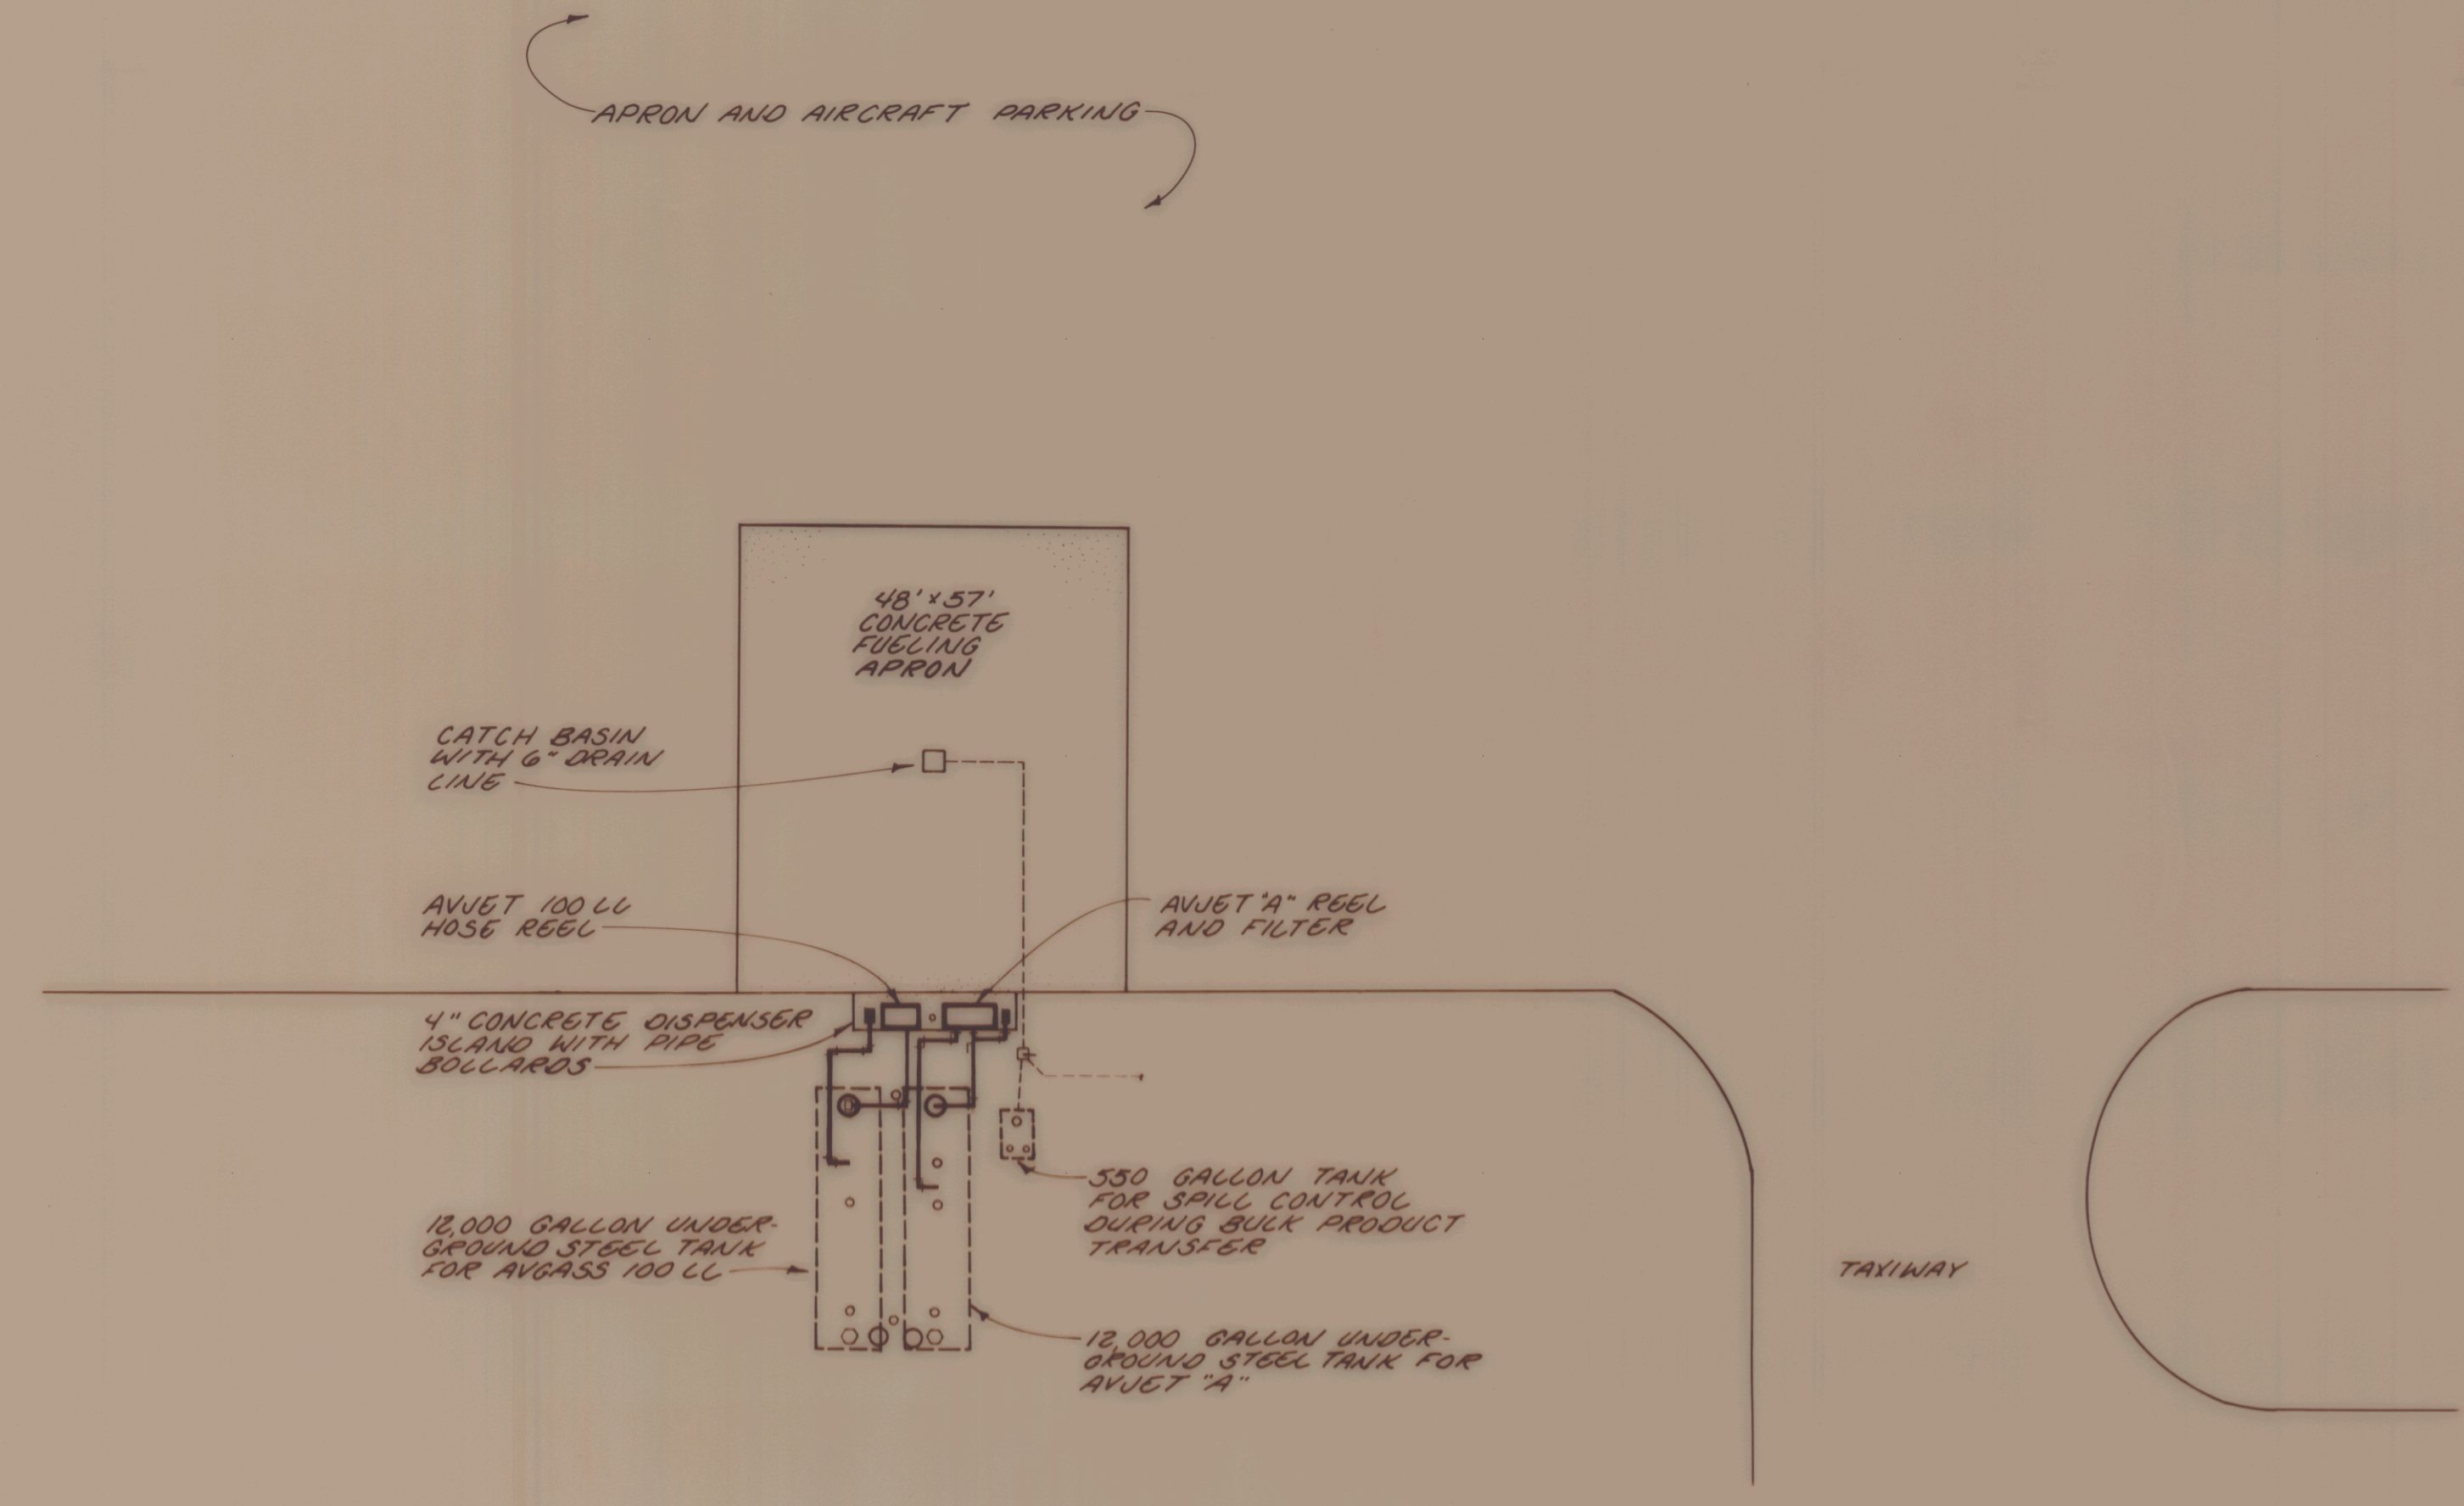

SITE PLAN
1" = 20'

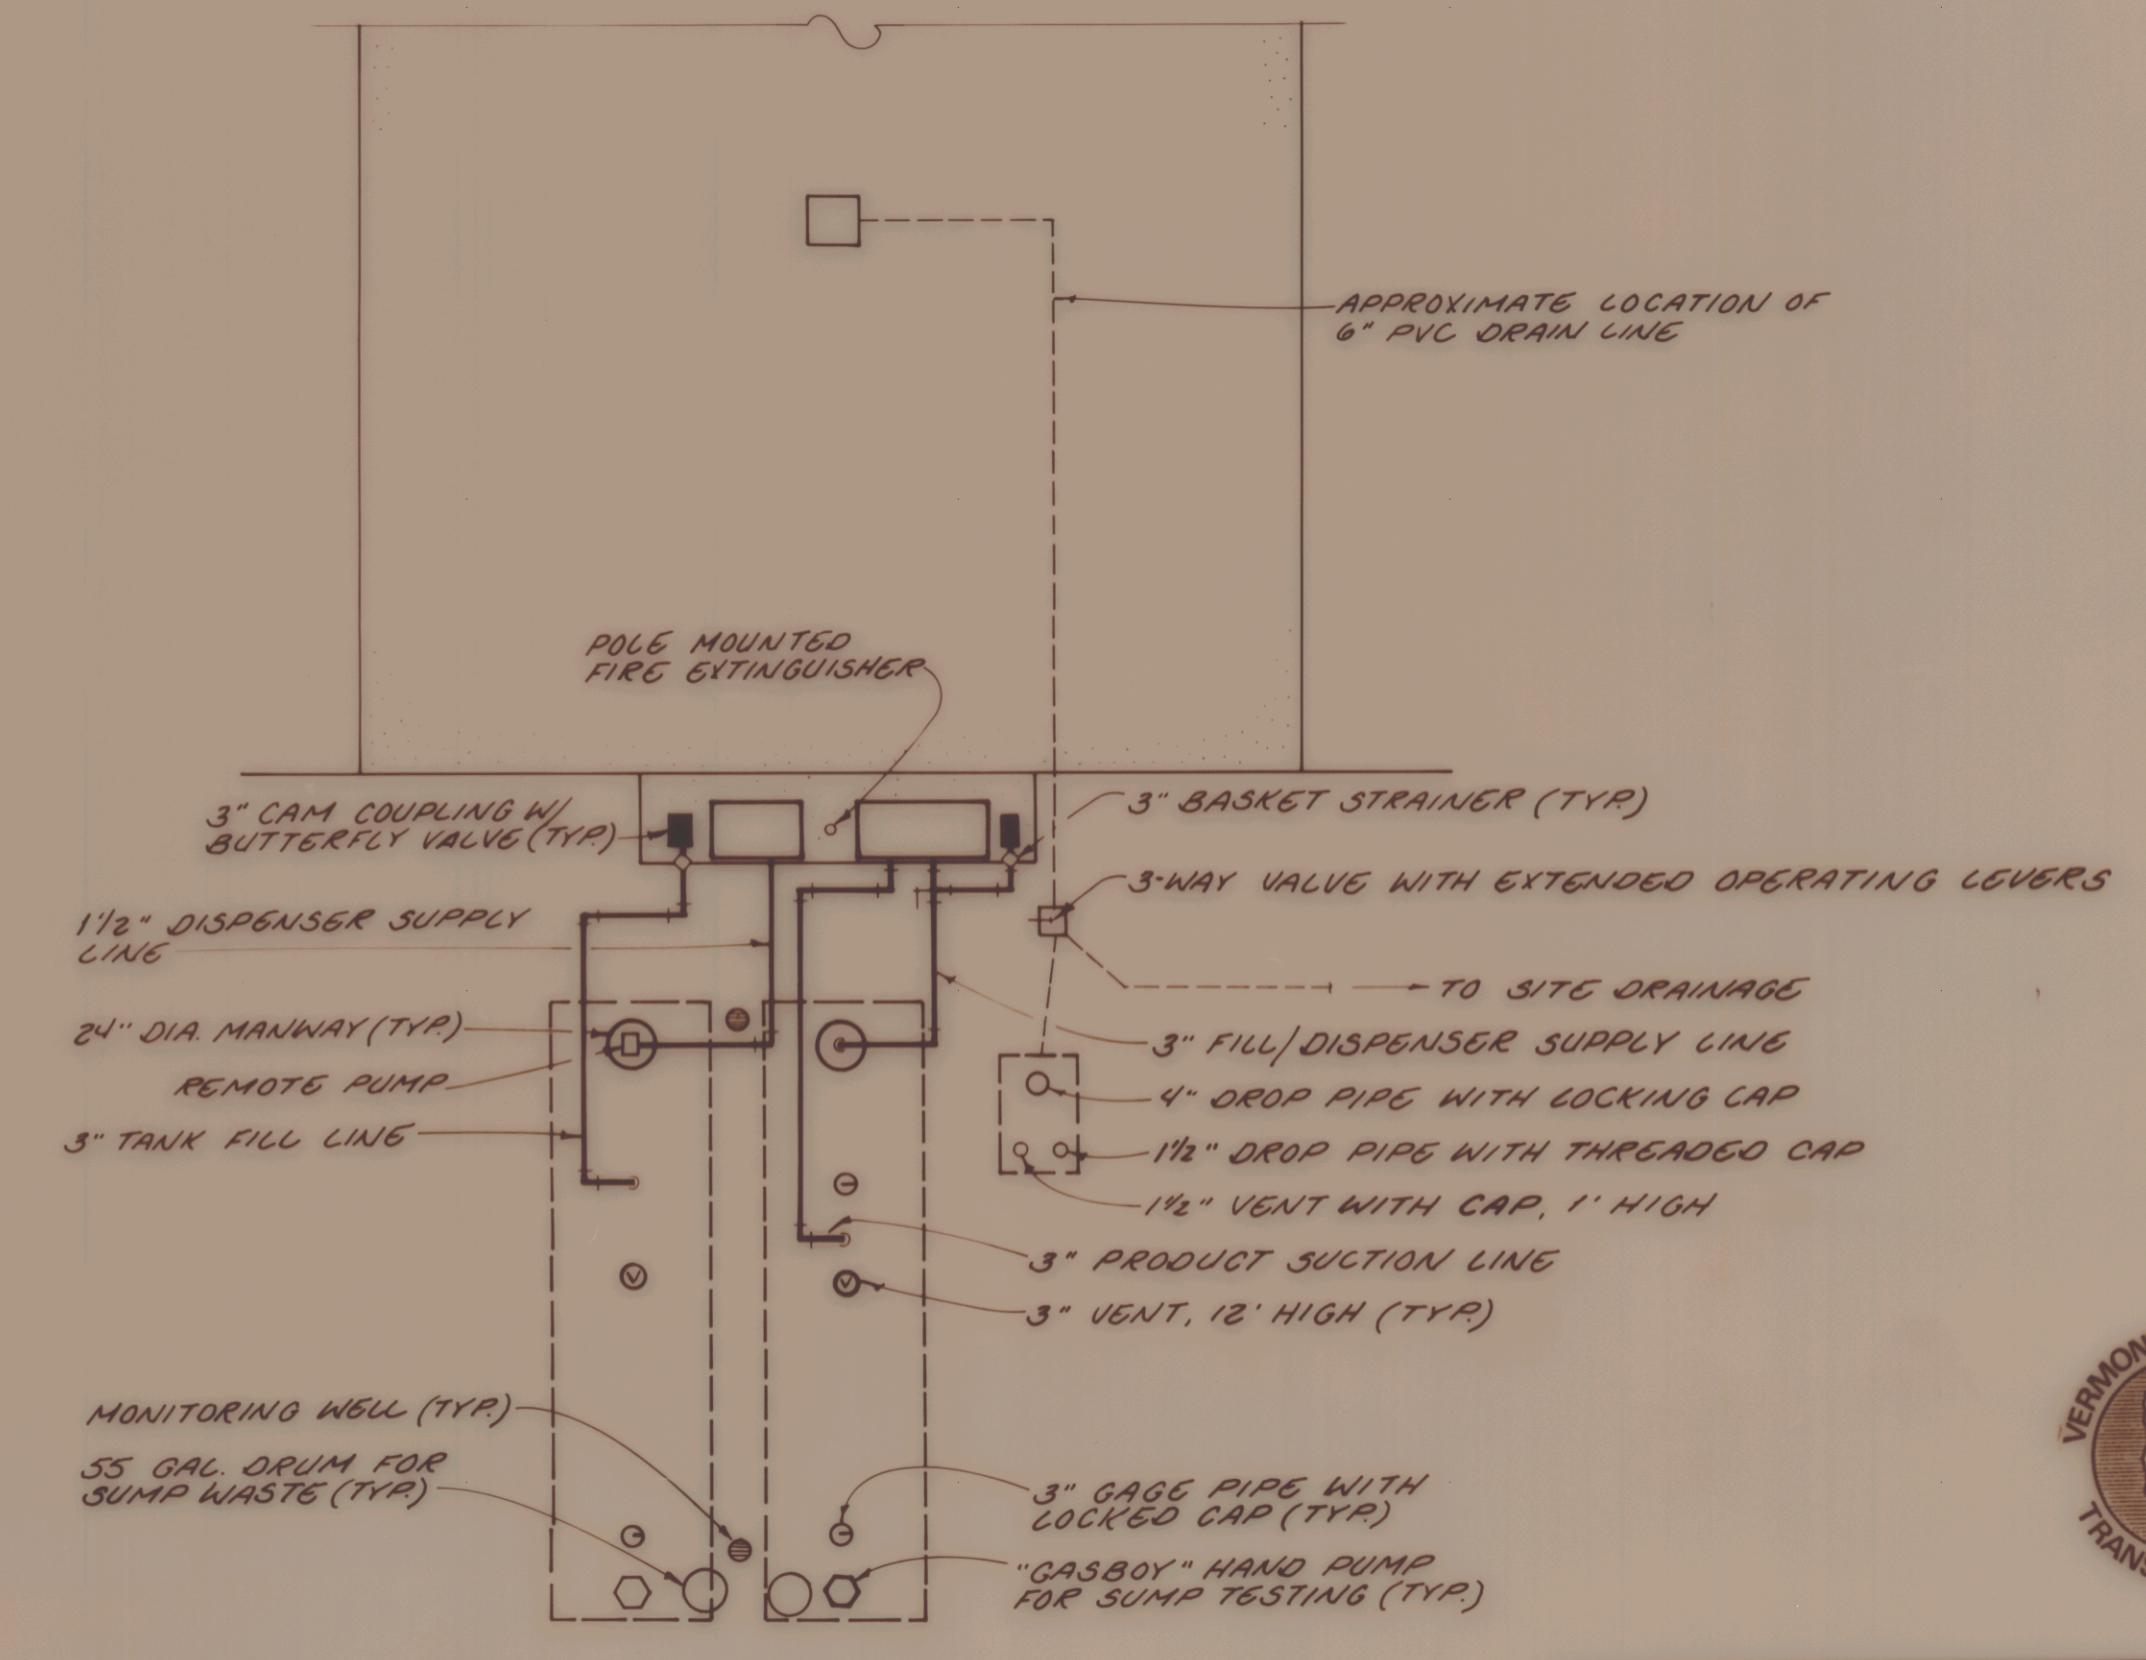

DETAIL ~ FUEL SYSTEM
1" = 10'



NOTE: THIS DRAWING REPRESENTS EXISTING FEATURES ON THE DATE OF THE SITE INSPECTION BY DUFRESNE-HENRY. IT IS A COMPILATION DRAWING BASED ON INFORMATION PROVIDED BY THE VERMONT AGENCY OF TRANSPORTATION, THE SYSTEM OPERATOR, AND VERIFIED BY FIELD INSPECTION.

Rev.	Description	By	Date

VERMONT AGENCY OF TRANSPORTATION
FUEL SYSTEM STUDY
MORRISVILLE-STOWE STATE AIRPORT

MORRISVILLE, VERMONT

	Client No.	217016
	Proj. Manager	T.S. REEVES
	Proj. Designer	T.S. REEVES
	Drawn By	W. HAZLETT
	Checked By	P.N. ANDREWS
	Scale	AS SHOWN
Approved		Sheet 8 of 11
Date		D 11,173

VERMONT AGENCY OF TRANSPORTATION
STATE OF VERMONT
REGISTERED PROFESSIONAL ENGINEER
PETER A. ANDREWS
No. 3183