


UNDERGROUND LP GAS TANK DETAILS

NOT TO SCALE

NOTE:
TANK, REGULATORS, PIPING AND ACCESSORIES, INCLUDING FIRST AND SECOND STAGE REGULATORS, TO BE FURNISHED AND INSTALLED BY THIS CONTRACTOR. COORDINATE WITH G.C. FOR REQUIRED FOR REQUIRED EXCAVATION AND BACKFILL.


SECTION AT OVERHEAD DOOR (TYP.)

NOT TO SCALE

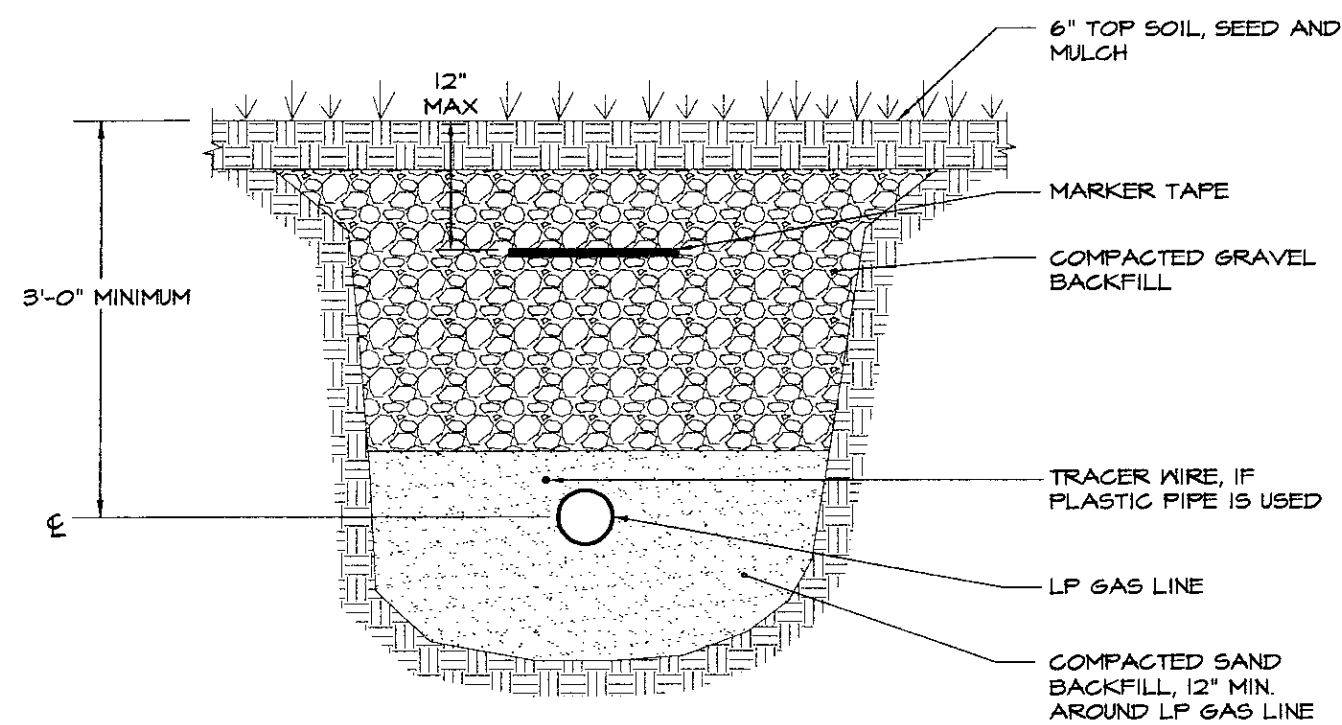


LP GAS SUPPLY PIPE TRENCHING DETAIL

NOT TO SCALE

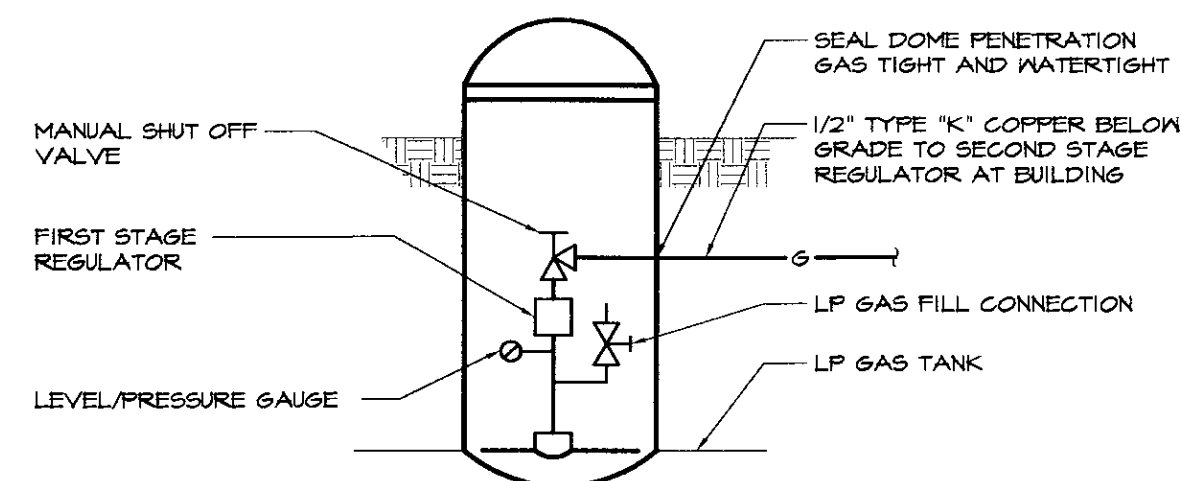

LP GAS TANK ACCESS DOME DETAIL


NOT TO SCALE

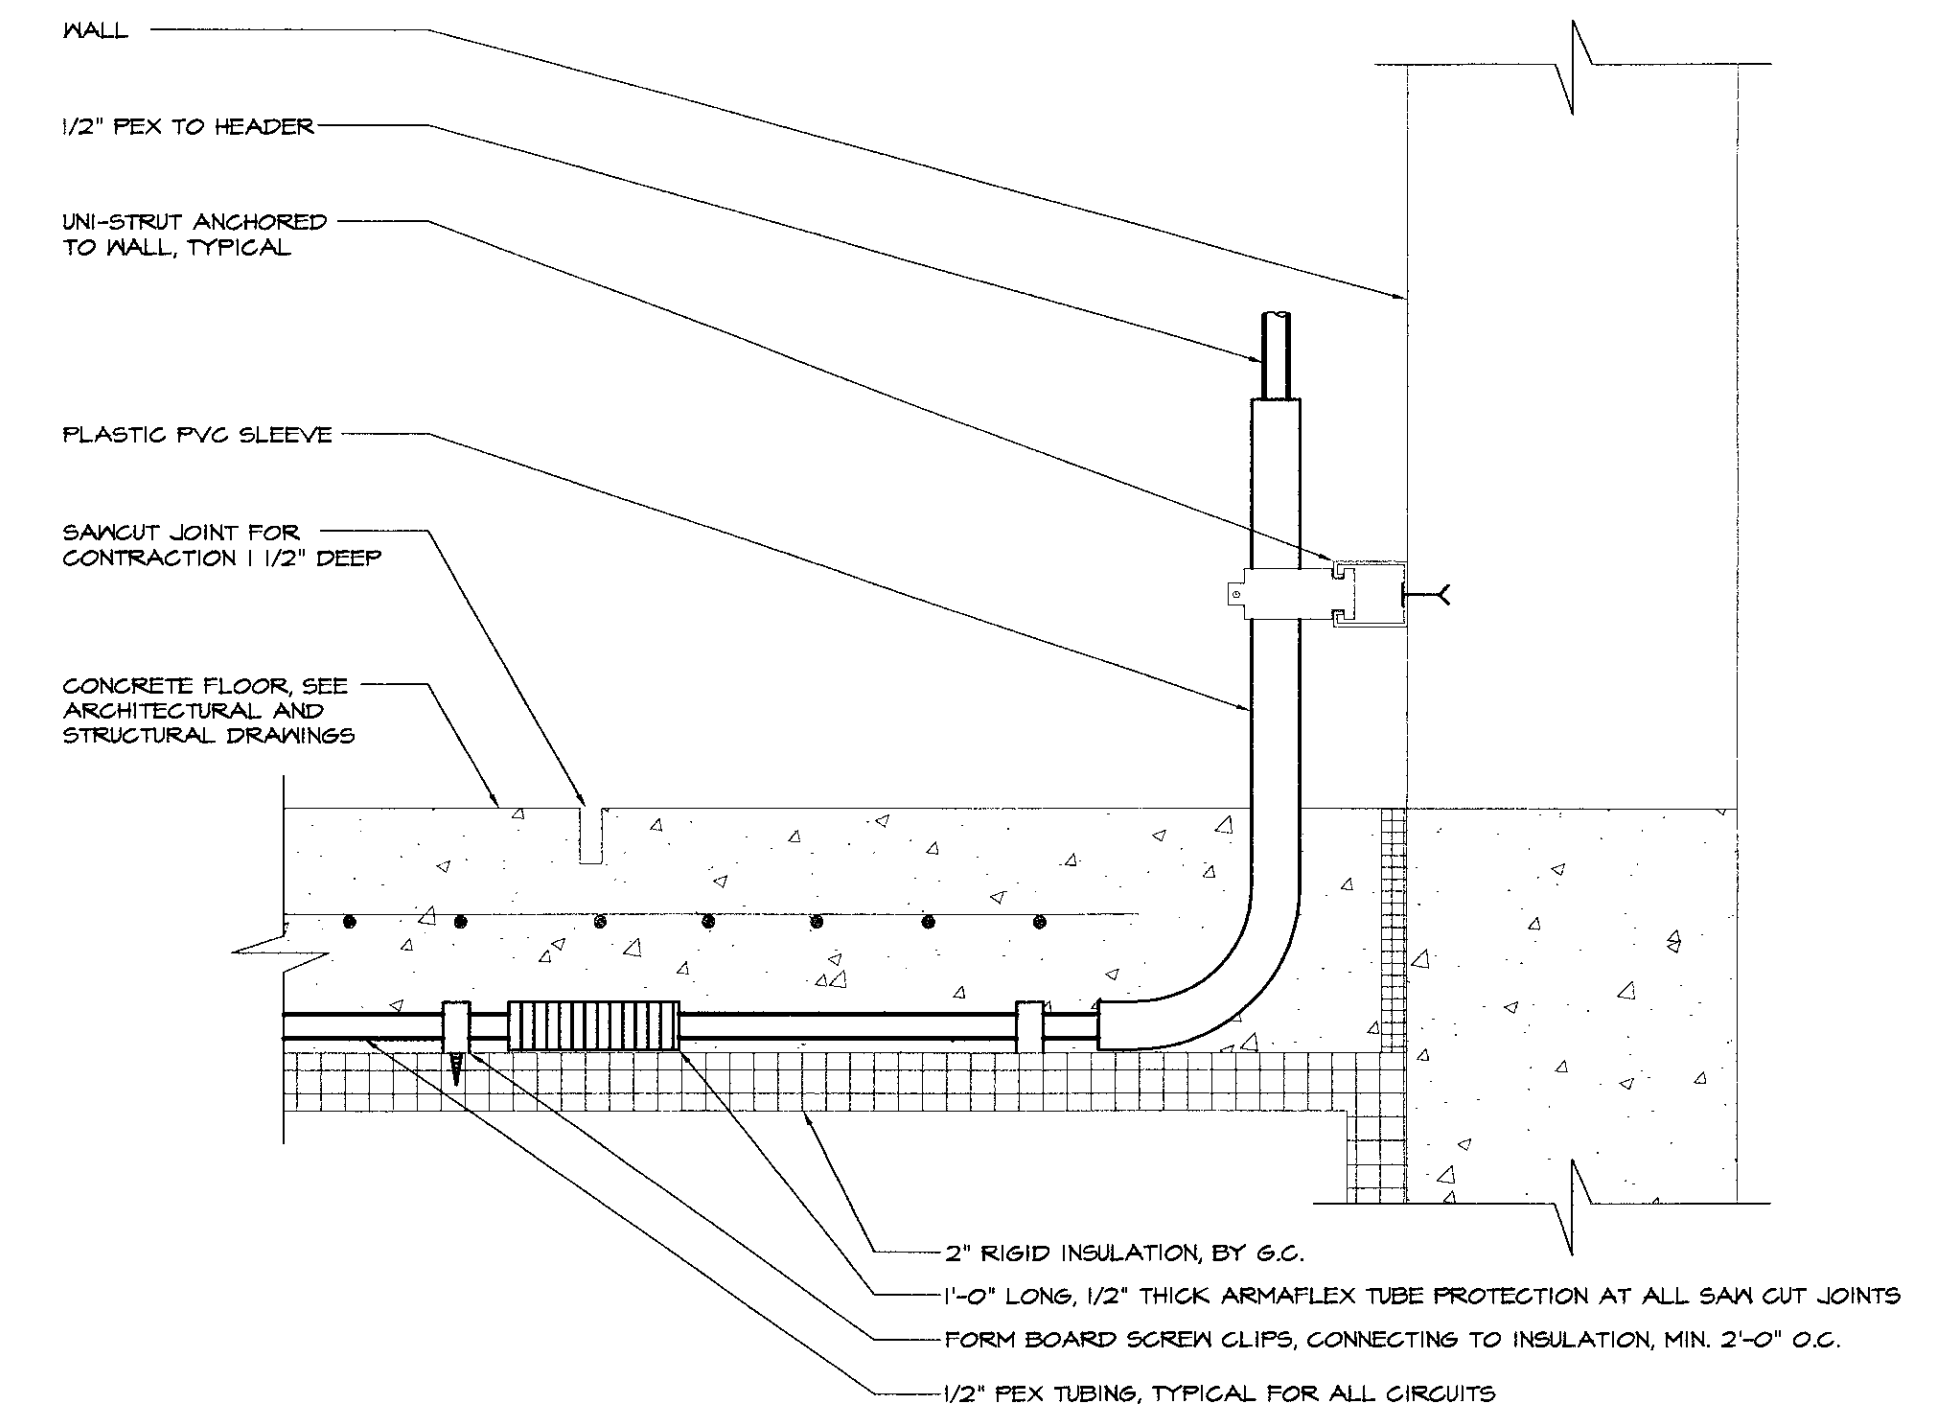

TYPICAL RADIANT TUBING DETAIL


NOT TO SCALE

1. PROVIDE PLASTIC SLEEVE PROTECTION TO WITHIN 6" OF HEADER ASSEMBLY

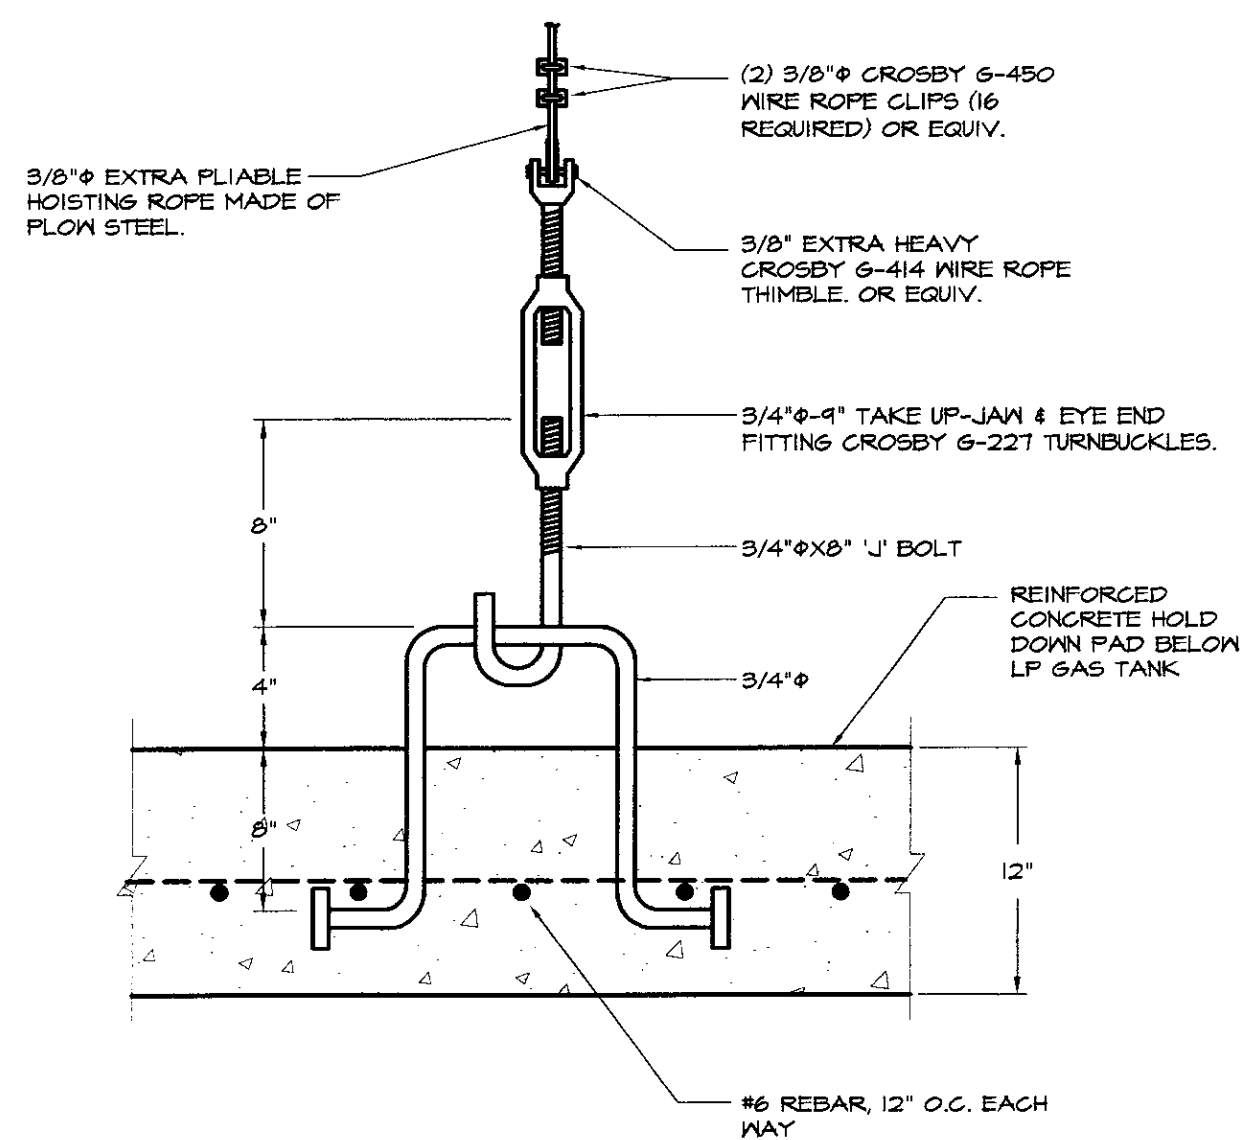

TANK ANCHOR BOLT DETAIL


NOT TO SCALE

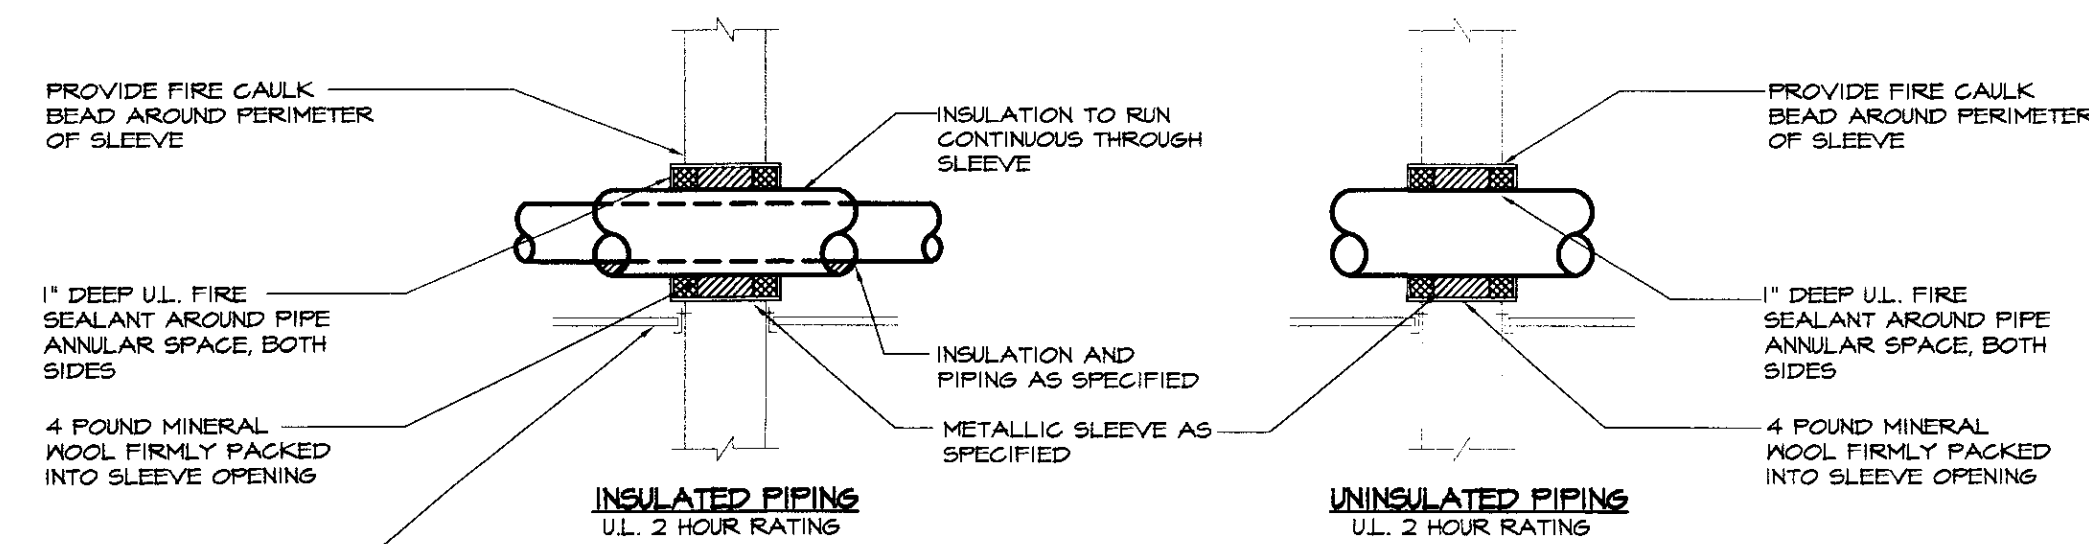

WALL PIPE PENETRATION DETAILS

NOT TO SCALE

NOTE:
1) FOLLOW FIRE SEALANT MANUFACTURER'S WRITTEN INSTALLATION INSTRUCTIONS IN CONJUNCTION WITH REQUIREMENTS AS DETAILED.
2) ALL WALL PIPE PENETRATIONS SHALL BE INSTALLED PER THIS DETAIL.
3) DETAIL BASED ON STI 'SPEC-SEAL' FIRE STOPPING PRODUCTS, ALTERNATE MANUFACTURER'S INSTALLATION REQUIREMENTS MAY VARY.

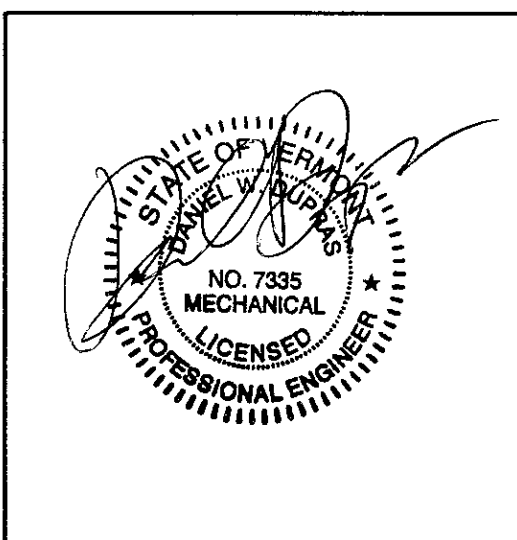

NO.	BIDDING & CONSTRUCTION	04/19/05
NO.	ISSUED FOR	DATE



HEATING, VENTILATION, & AIR CONDITIONING, PLUMBING, FIRE PROTECTION, & ELECTRICAL

CHARLES F. LANE, P.E.
DANIEL W. DUPRAS, P.E.

51 KILLINGTON AVENUE,
RUTLAND, VERMONT 05701
TELEPHONE: (802)747-3346
FAX/MODEM: (802)747-3356

MECHANICAL DETAILS				M 3
NEW HANGER CIVIL AIR PATROL CALEDONIA COUNTY AIRPORT LYNDONVILLE, VT				
APPR:	DVD	DRAWN:	TDL/RRT	SCALE: AS NOTED
PROJ. NO.				0912-14