



PLUMBING FIXTURE CONNECTION SCHEDULE								PLAN SYMBOL P-1
No.	ITEM	SOIL	WASTE	VENT	CM	HM	TRAP	REMARKS
P-1	ADA WATER CLOSET	3"	-	2"	1/2"	-	INTEGRAL	-
P-2	ADA LAVATORY	-	1 1/2"	1 1/2"	1/2"	1/2"	1 1/4" X 1 1/2"-P	-
P-3	ADA URINAL	2"	-	1 1/2"	3/4"	-	INTEGRAL	-
P-4	ADA SHOWER	-	2"	1 1/2"	1/2"	1/2"	2"-P	-
P-5	COUNTER SINK	-	1 1/2"	1 1/2"	1/2"	1/2"	1 1/2"-P	-
P-6	SERVICE SINK	-	2"	1 1/2"	1/2"	1/2"	2"-P	-

PLUMBING LEGEND AND ABBREVIATIONS


- SANITARY PIPING
- VENT PIPING
- COLD WATER PIPING
- HOT WATER PIPING (110°F)
- PRIMER PIPING
- PIPE RISER
- PIPE DROP
- PIPE CAP
- PIPE UNION
- ⊘ BALL VALVE
- ⊘ FIXTURE STOP
- ⊘ CHECK VALVE
- ⊘ BACKFLOW PREVENTER PRZ=REDUCED PRESSURE ZONE
- FCO FLOOR CLEANOUT
- ⊘ PRESSURE REDUCING VALVE
- ⊘ PRESSURE SWITCH
- ⊘ PRESSURE RELIEF VALVE
- ⊘ THERMOSTATIC MIXING VALVE
- ⊘ TEMPERATURE GAUGE
- ⊘ NON-FREEZE WALL HYDRANT
- ⊘ FLOOR DRAIN
- M.C. MECHANICAL CONTRACTOR
- P.C. PLUMBING CONTRACTOR
- E.C. ELECTRICAL CONTRACTOR
- G.C. GENERAL CONTRACTOR

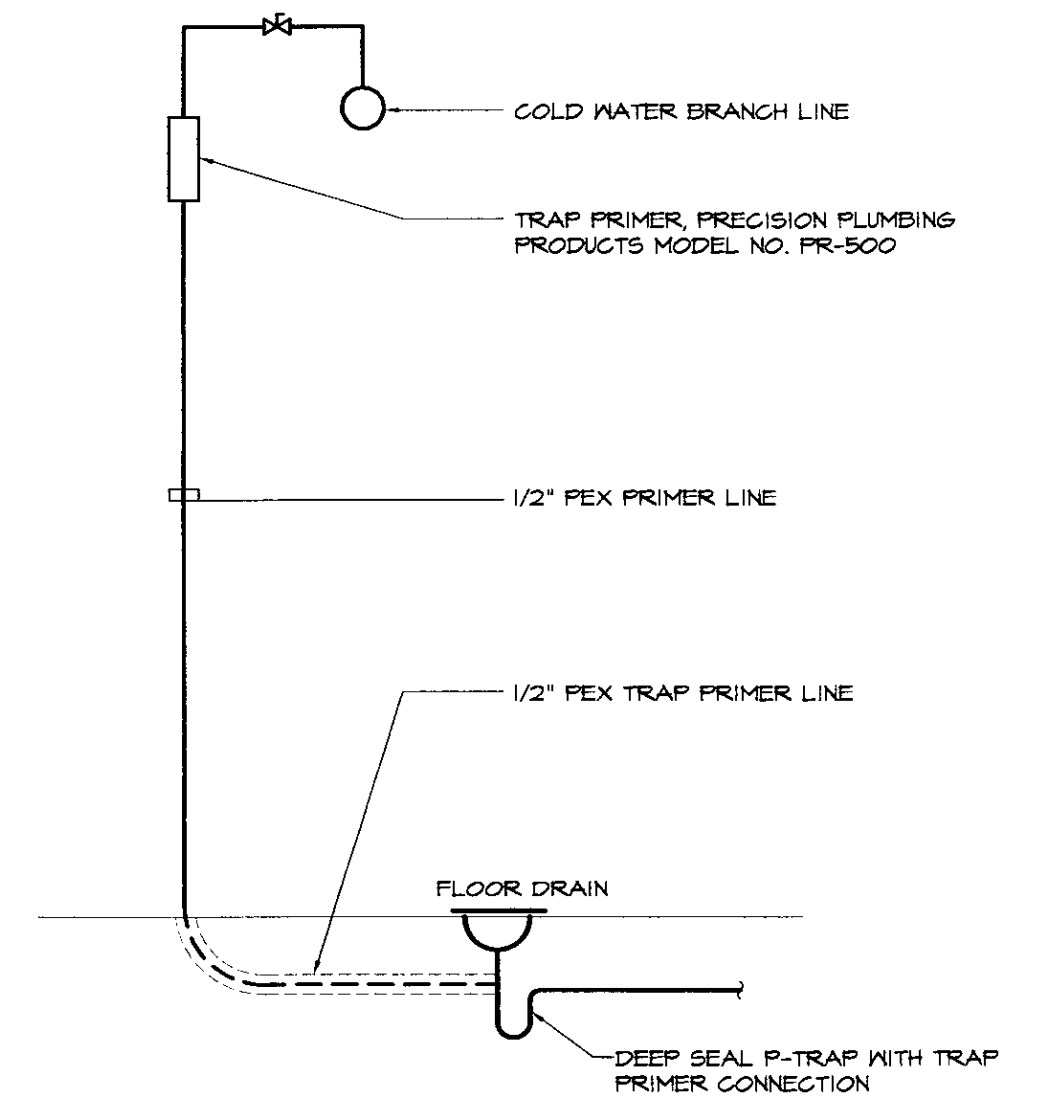


TRAP PRIMER DETAIL
NOT TO SCALE

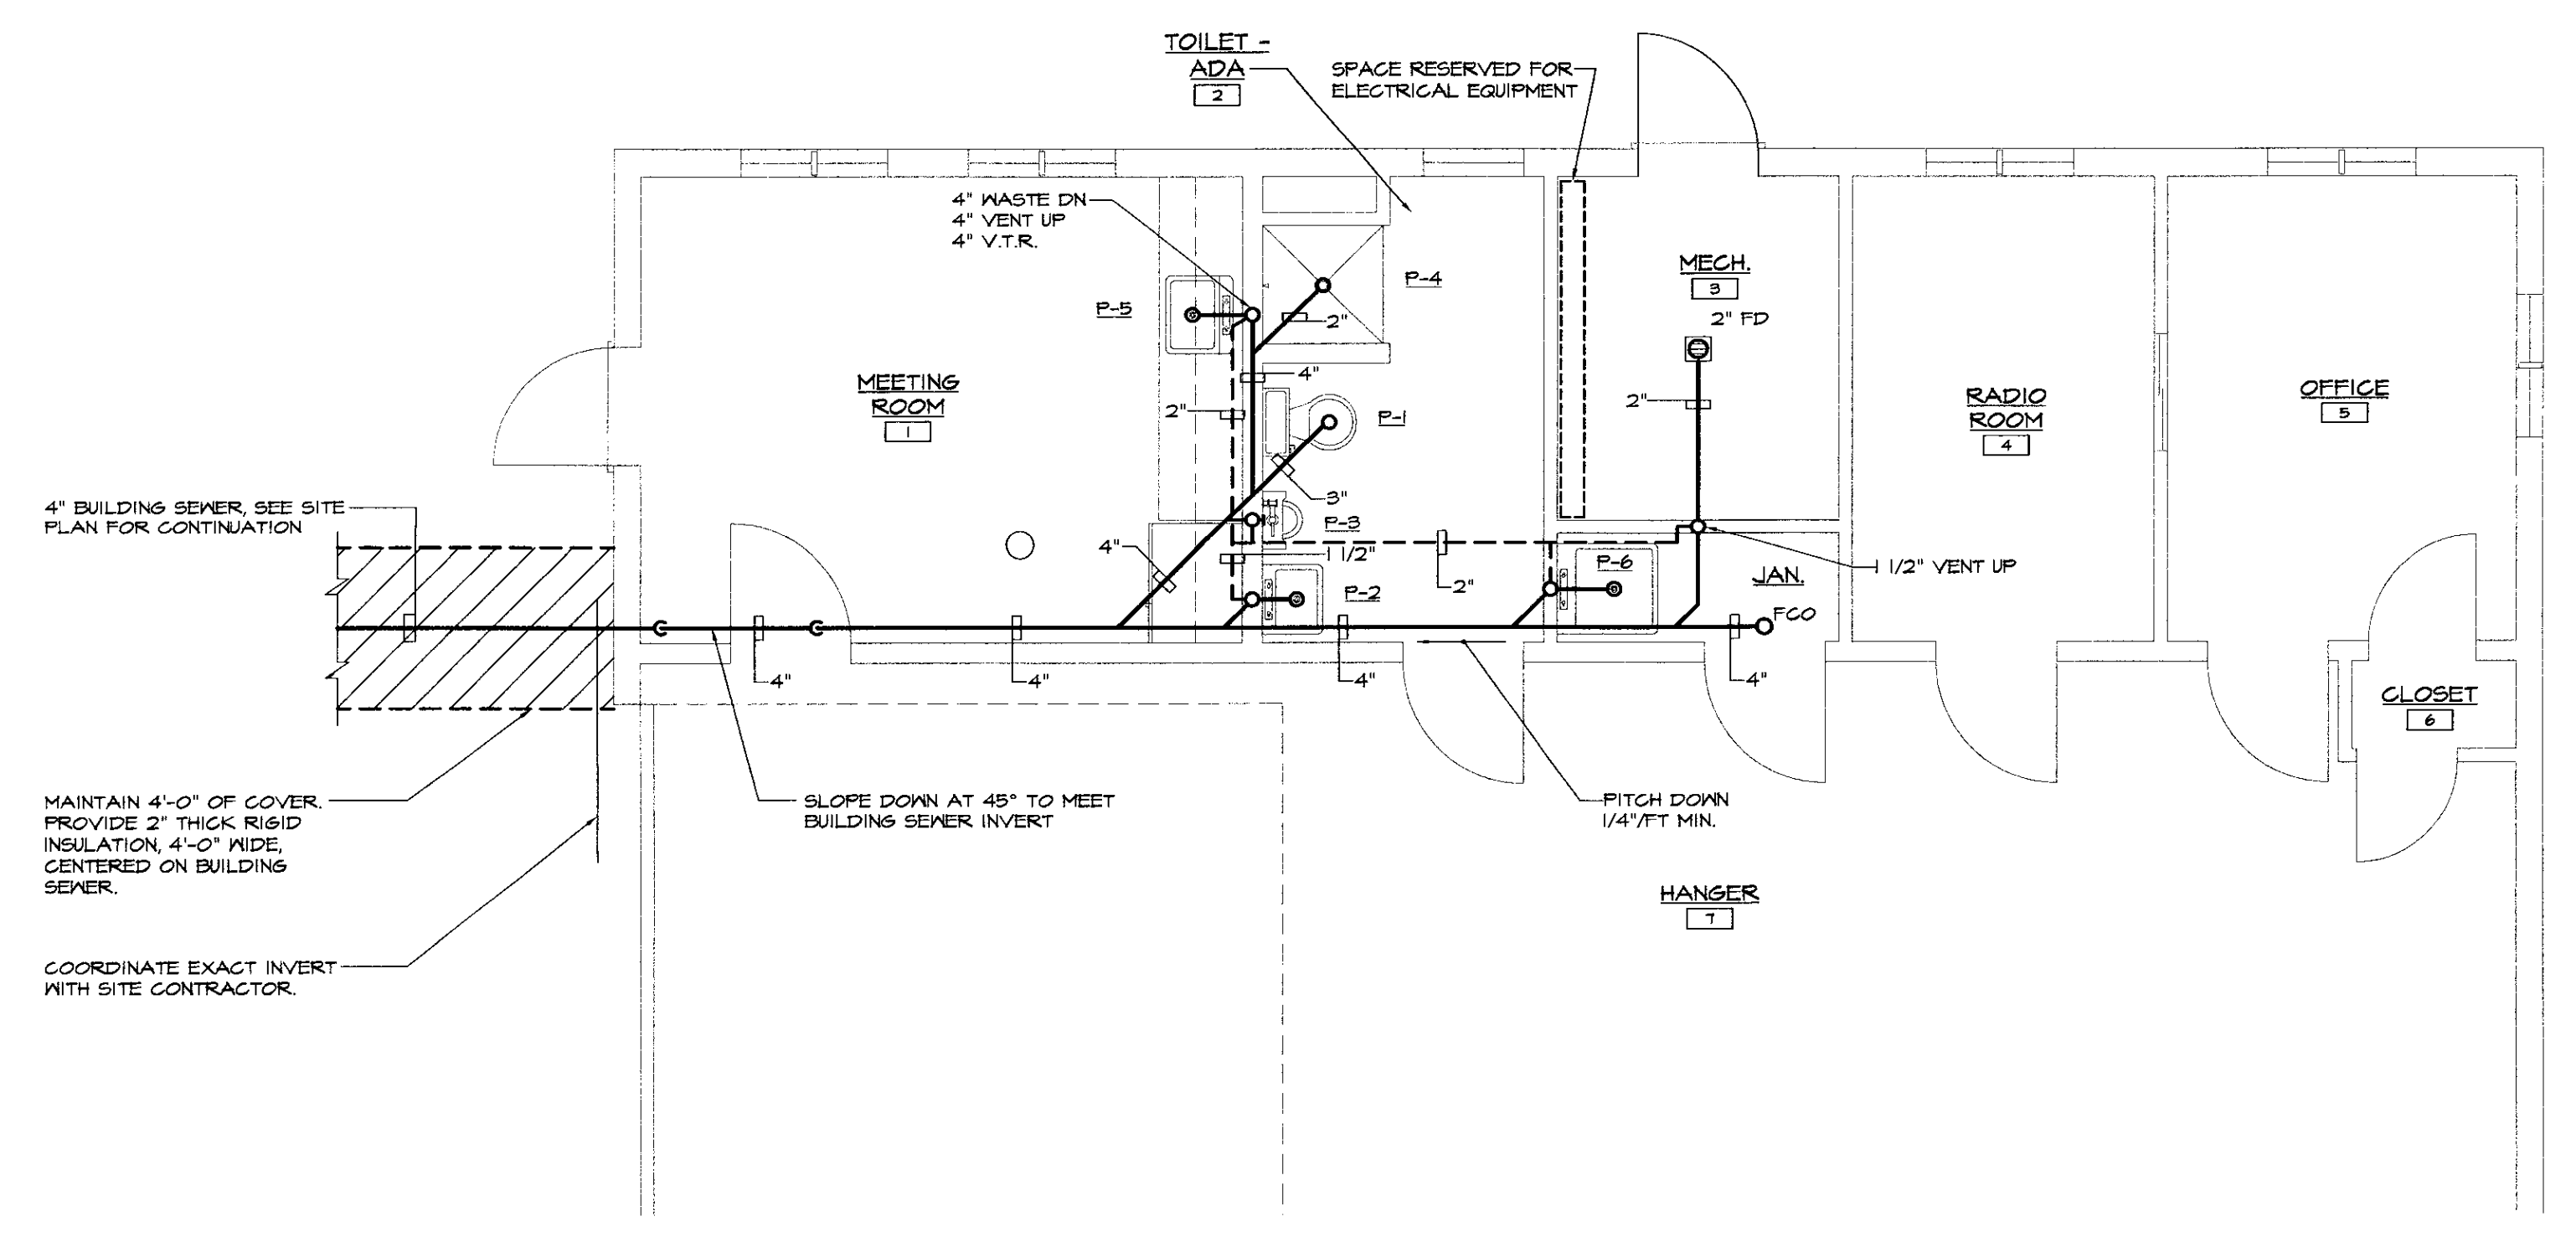


PARTIAL GROUND FLOOR PLAN - PLUMBING WASTE & VENT
SCALE: 1/4"=1'-0"

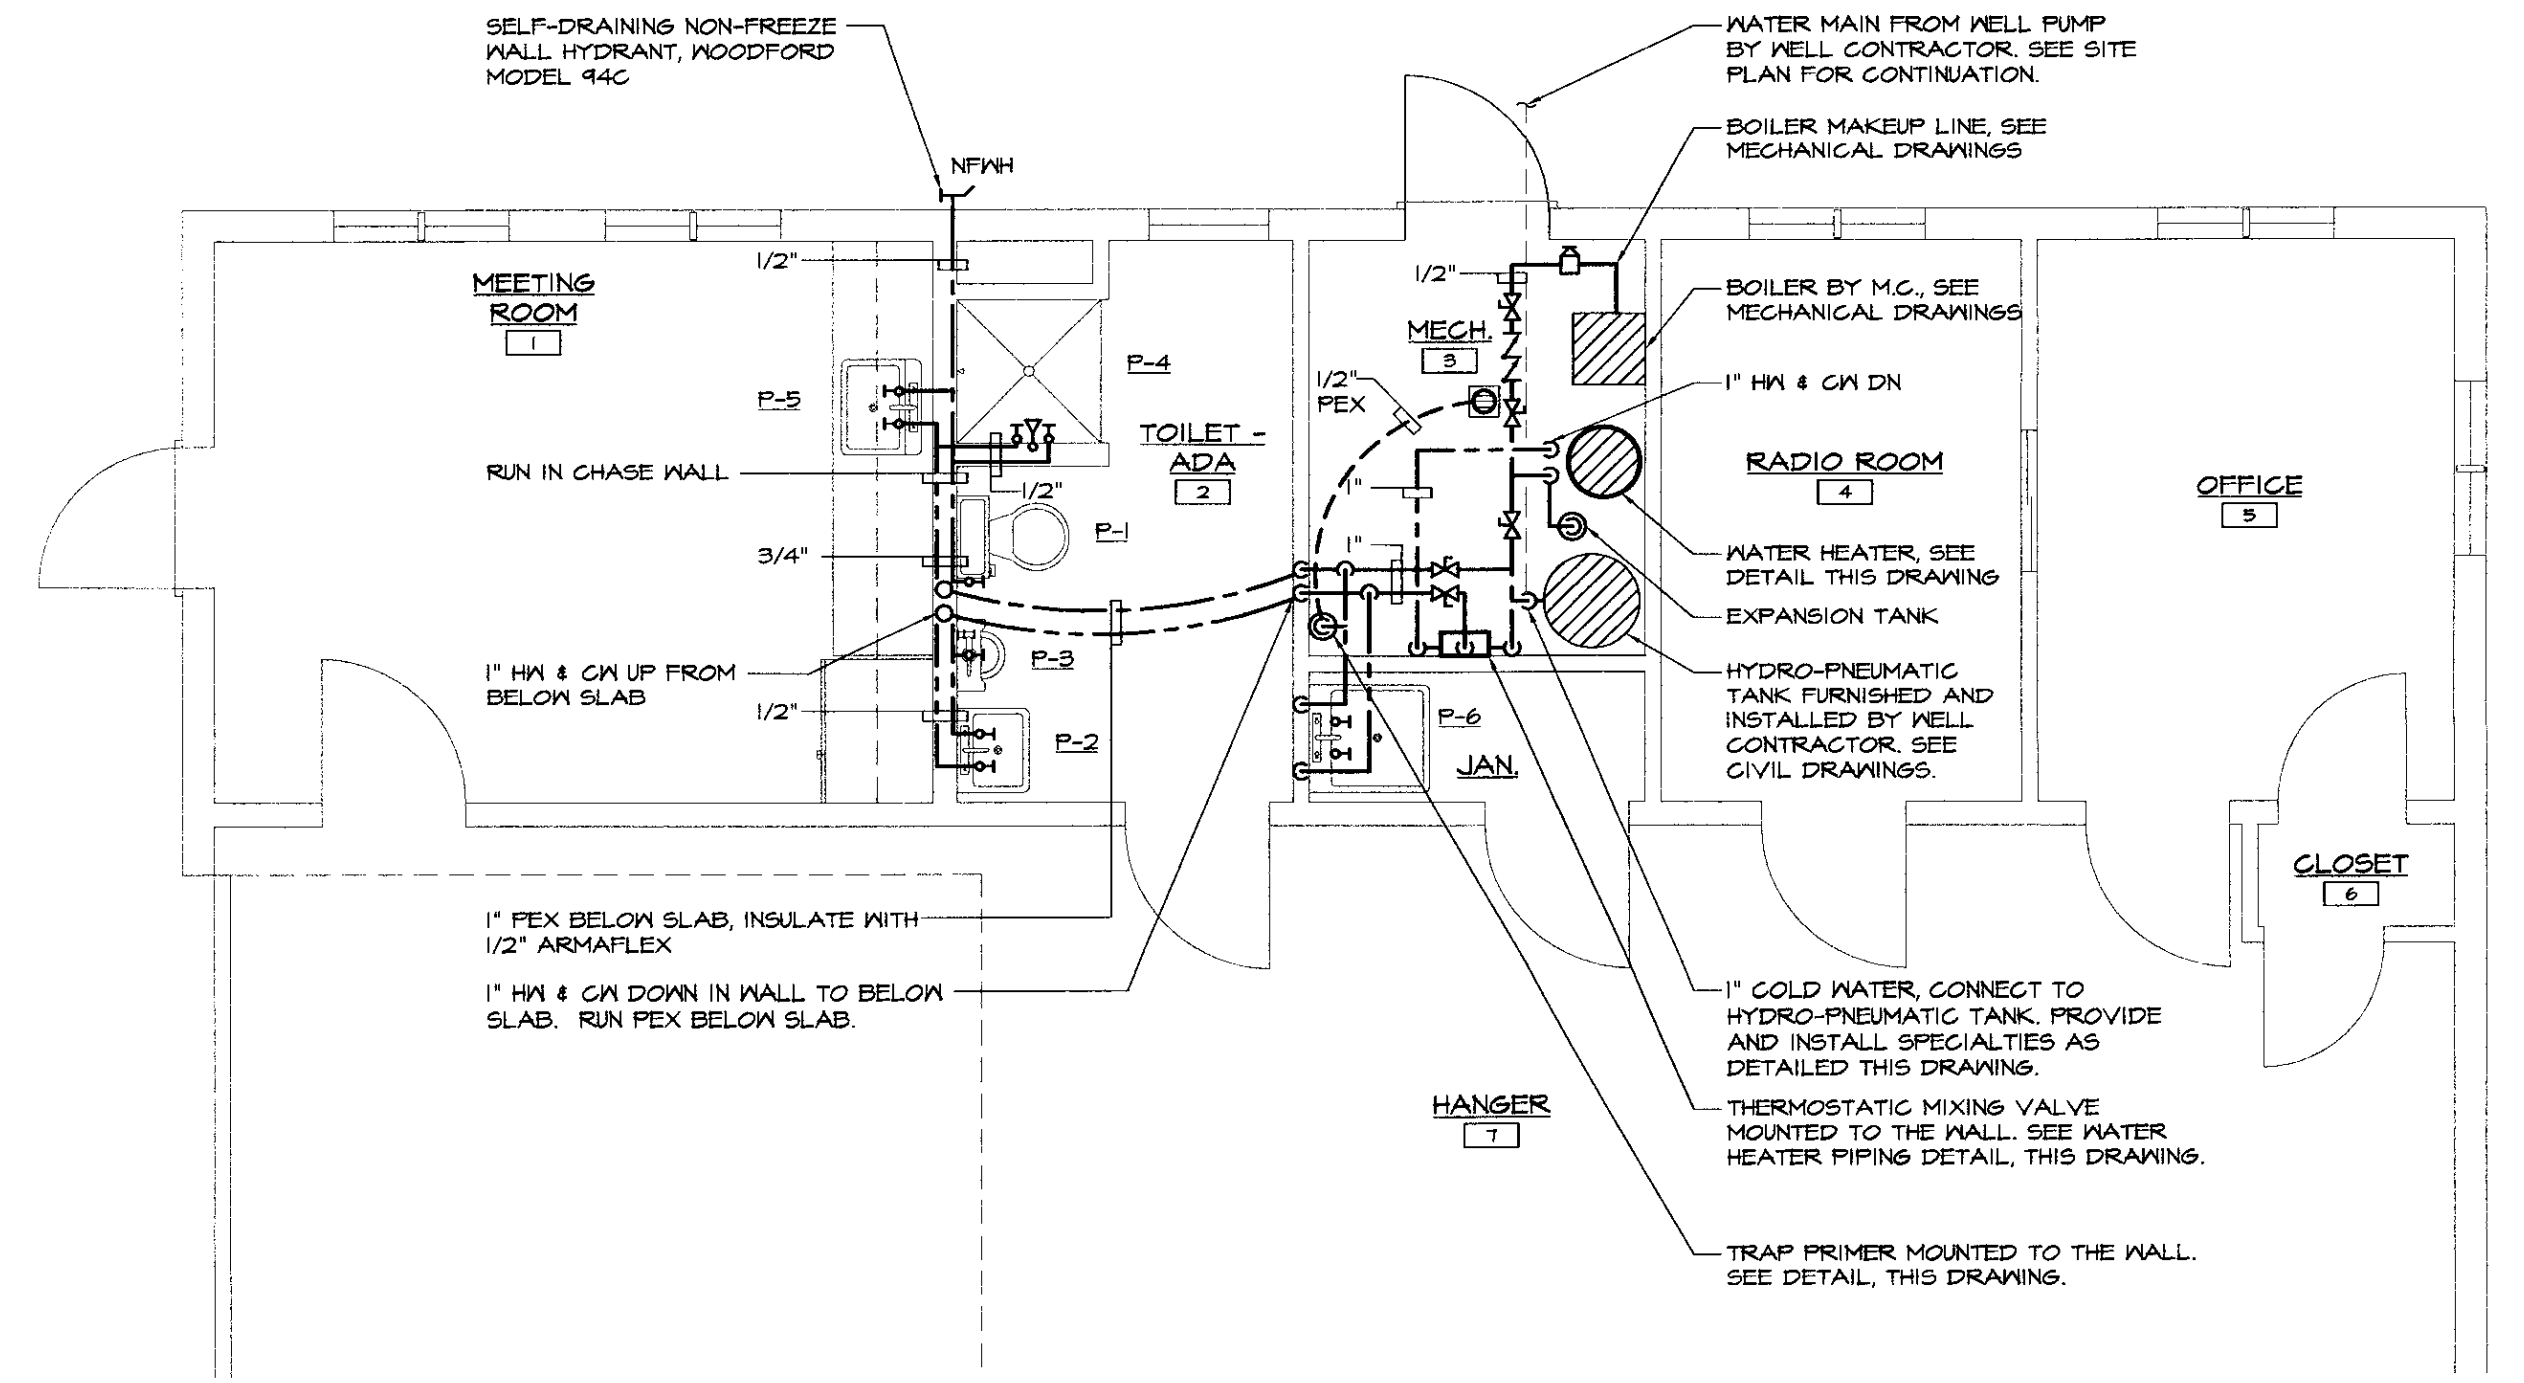



PARTIAL GROUND FLOOR PLAN - PLUMBING WATER PIPING
SCALE: 1/4"=1'-0"

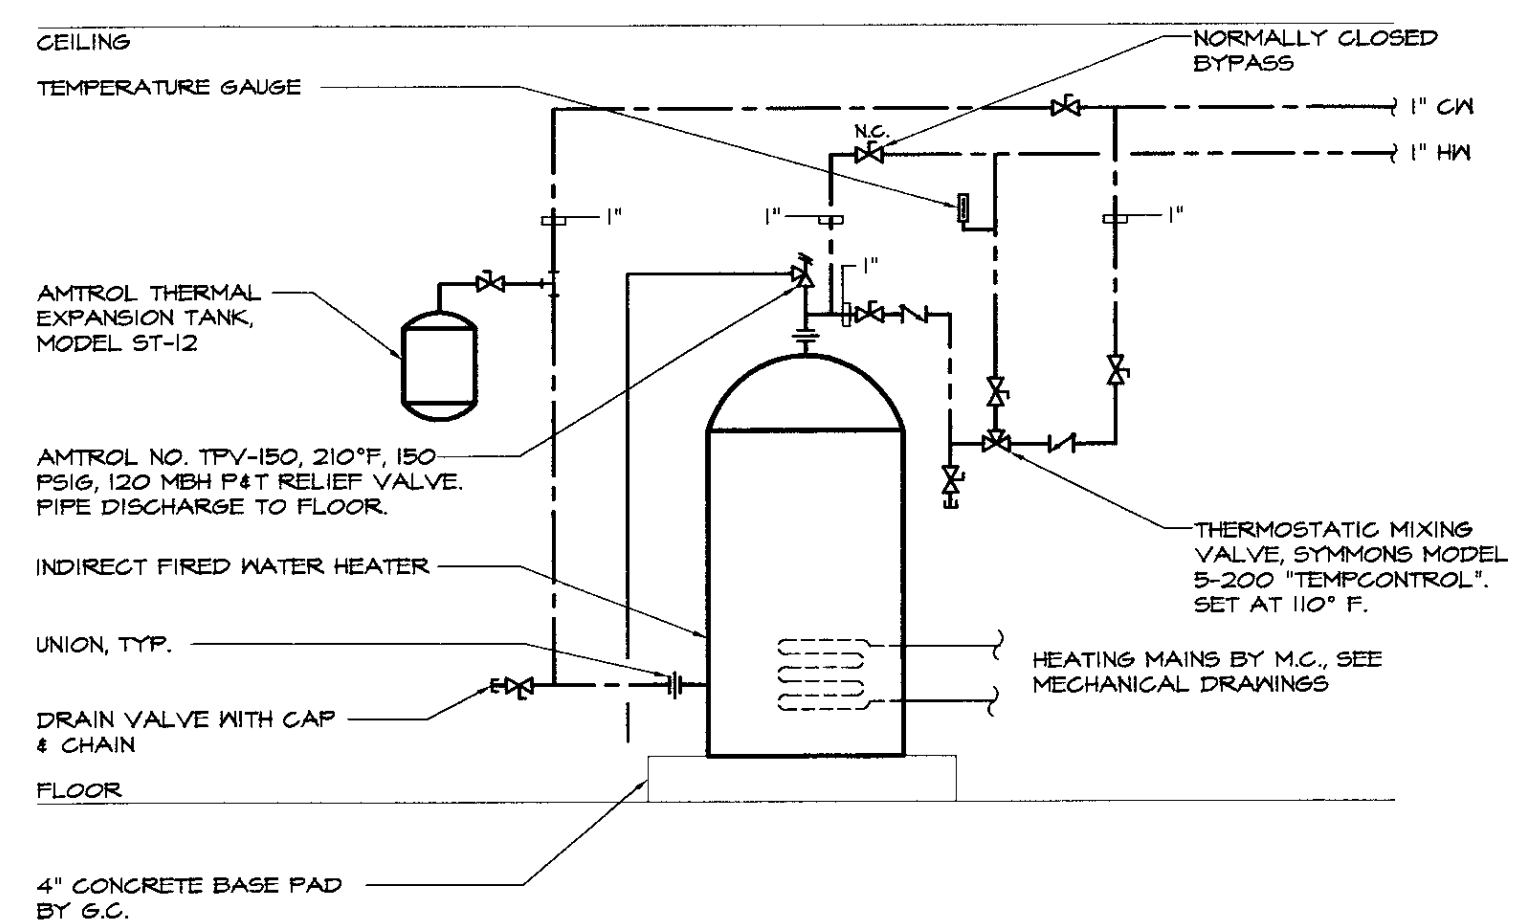

DOMESTIC WATER HEATER PIPING DETAIL
NOT TO SCALE

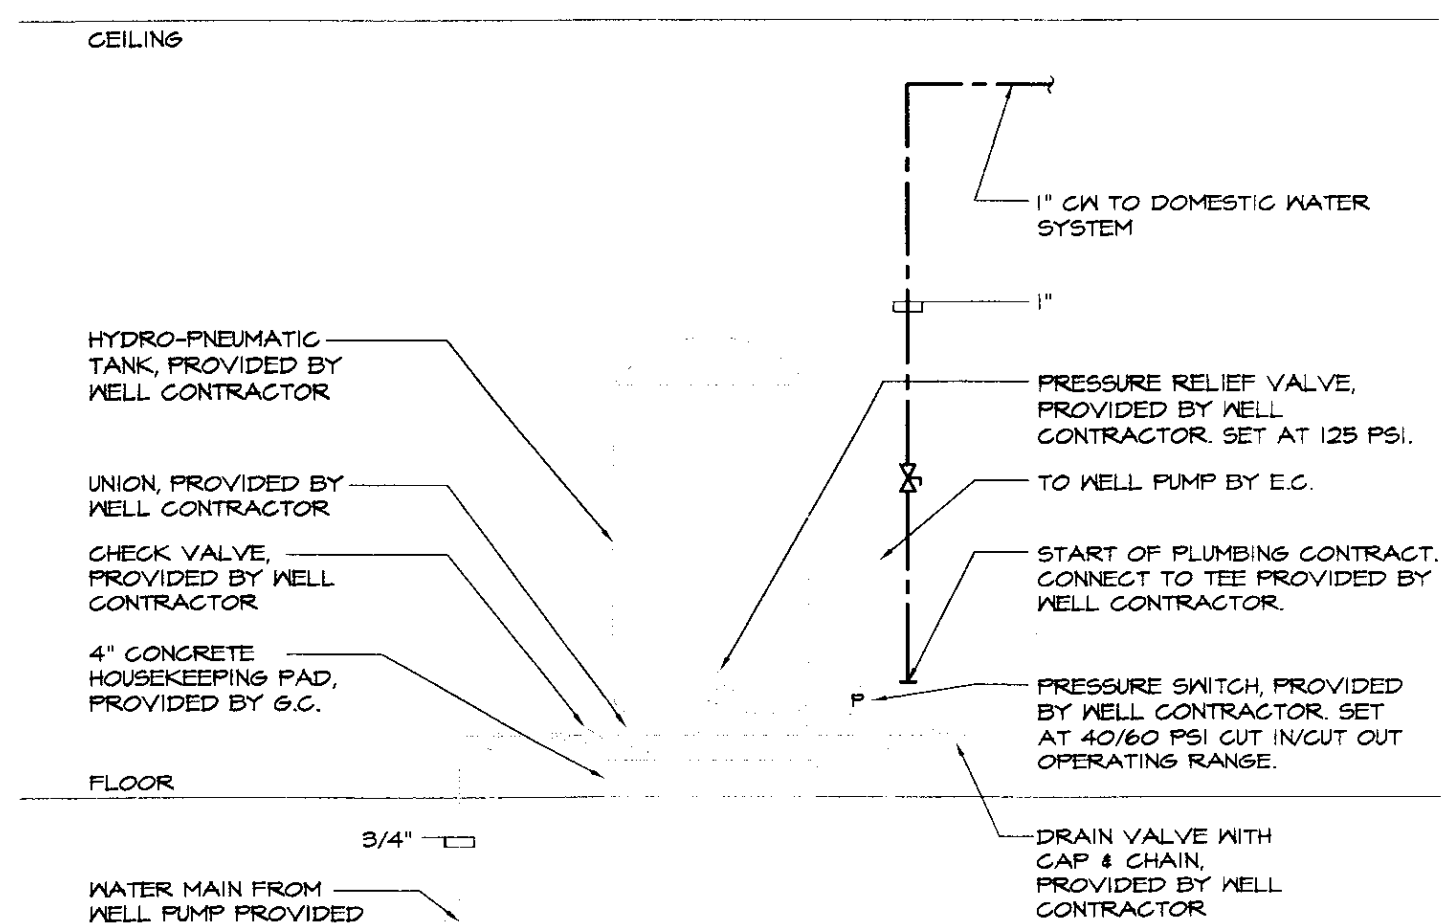

DOMESTIC WATER HYDRO-PNEUMATIC TANK DETAIL
NOT TO SCALE

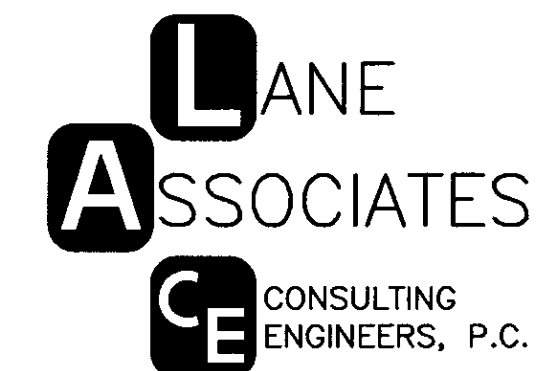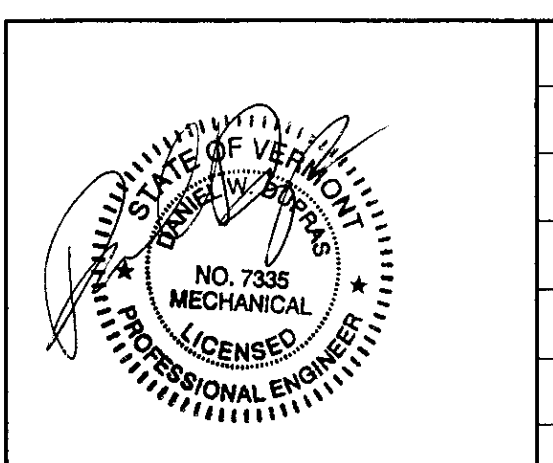

HEATING, VENTILATION, & AIR CONDITIONING,
PLUMBING, FIRE PROTECTION, & ELECTRICAL

CHARLES F. LANE, P.E.
DANIEL W. DUPRAS, P.E.

51 KILLINGTON AVENUE,
RUTLAND, VERMONT 05701
TELEPHONE: (802)747-3346
FAX/MODEM: (802)747-3356

**PARTIAL GROUND FLOOR PLUMBING PLANS,
PLUMBING DETAILS & SCHEDULES**

**NEW HANGER
CIVIL AIR PATROL
CALEDONIA COUNTY AIRPORT
LYNDONVILLE, VT**

**P
1**

APPR: DWD DRAWN: KPG SCALE: AS NOTED PROJ. NO. 0912-14

NO.	ISSUED FOR	DATE
1	BIDDING & CONSTRUCTION	04/19/05

X:\031214\Drawings\Plumbing\031214P01.dwg, P1, 4/19/2005 9:27:05 AM, © LANE ASSOCIATES CONSULTING ENGINEERS PC, 2005