
 


KEY	FEEDER SCHEDULE
△	2-1/2"C, 3-#4/0 CU., 2"C SPARE
△	EXISTING OVERHEAD
△	NEW OVERHEAD LINES INSTALLED BY L.E.C. FEES AND COORD. PROVIDED BY ELECTRICAL CONTRACTOR

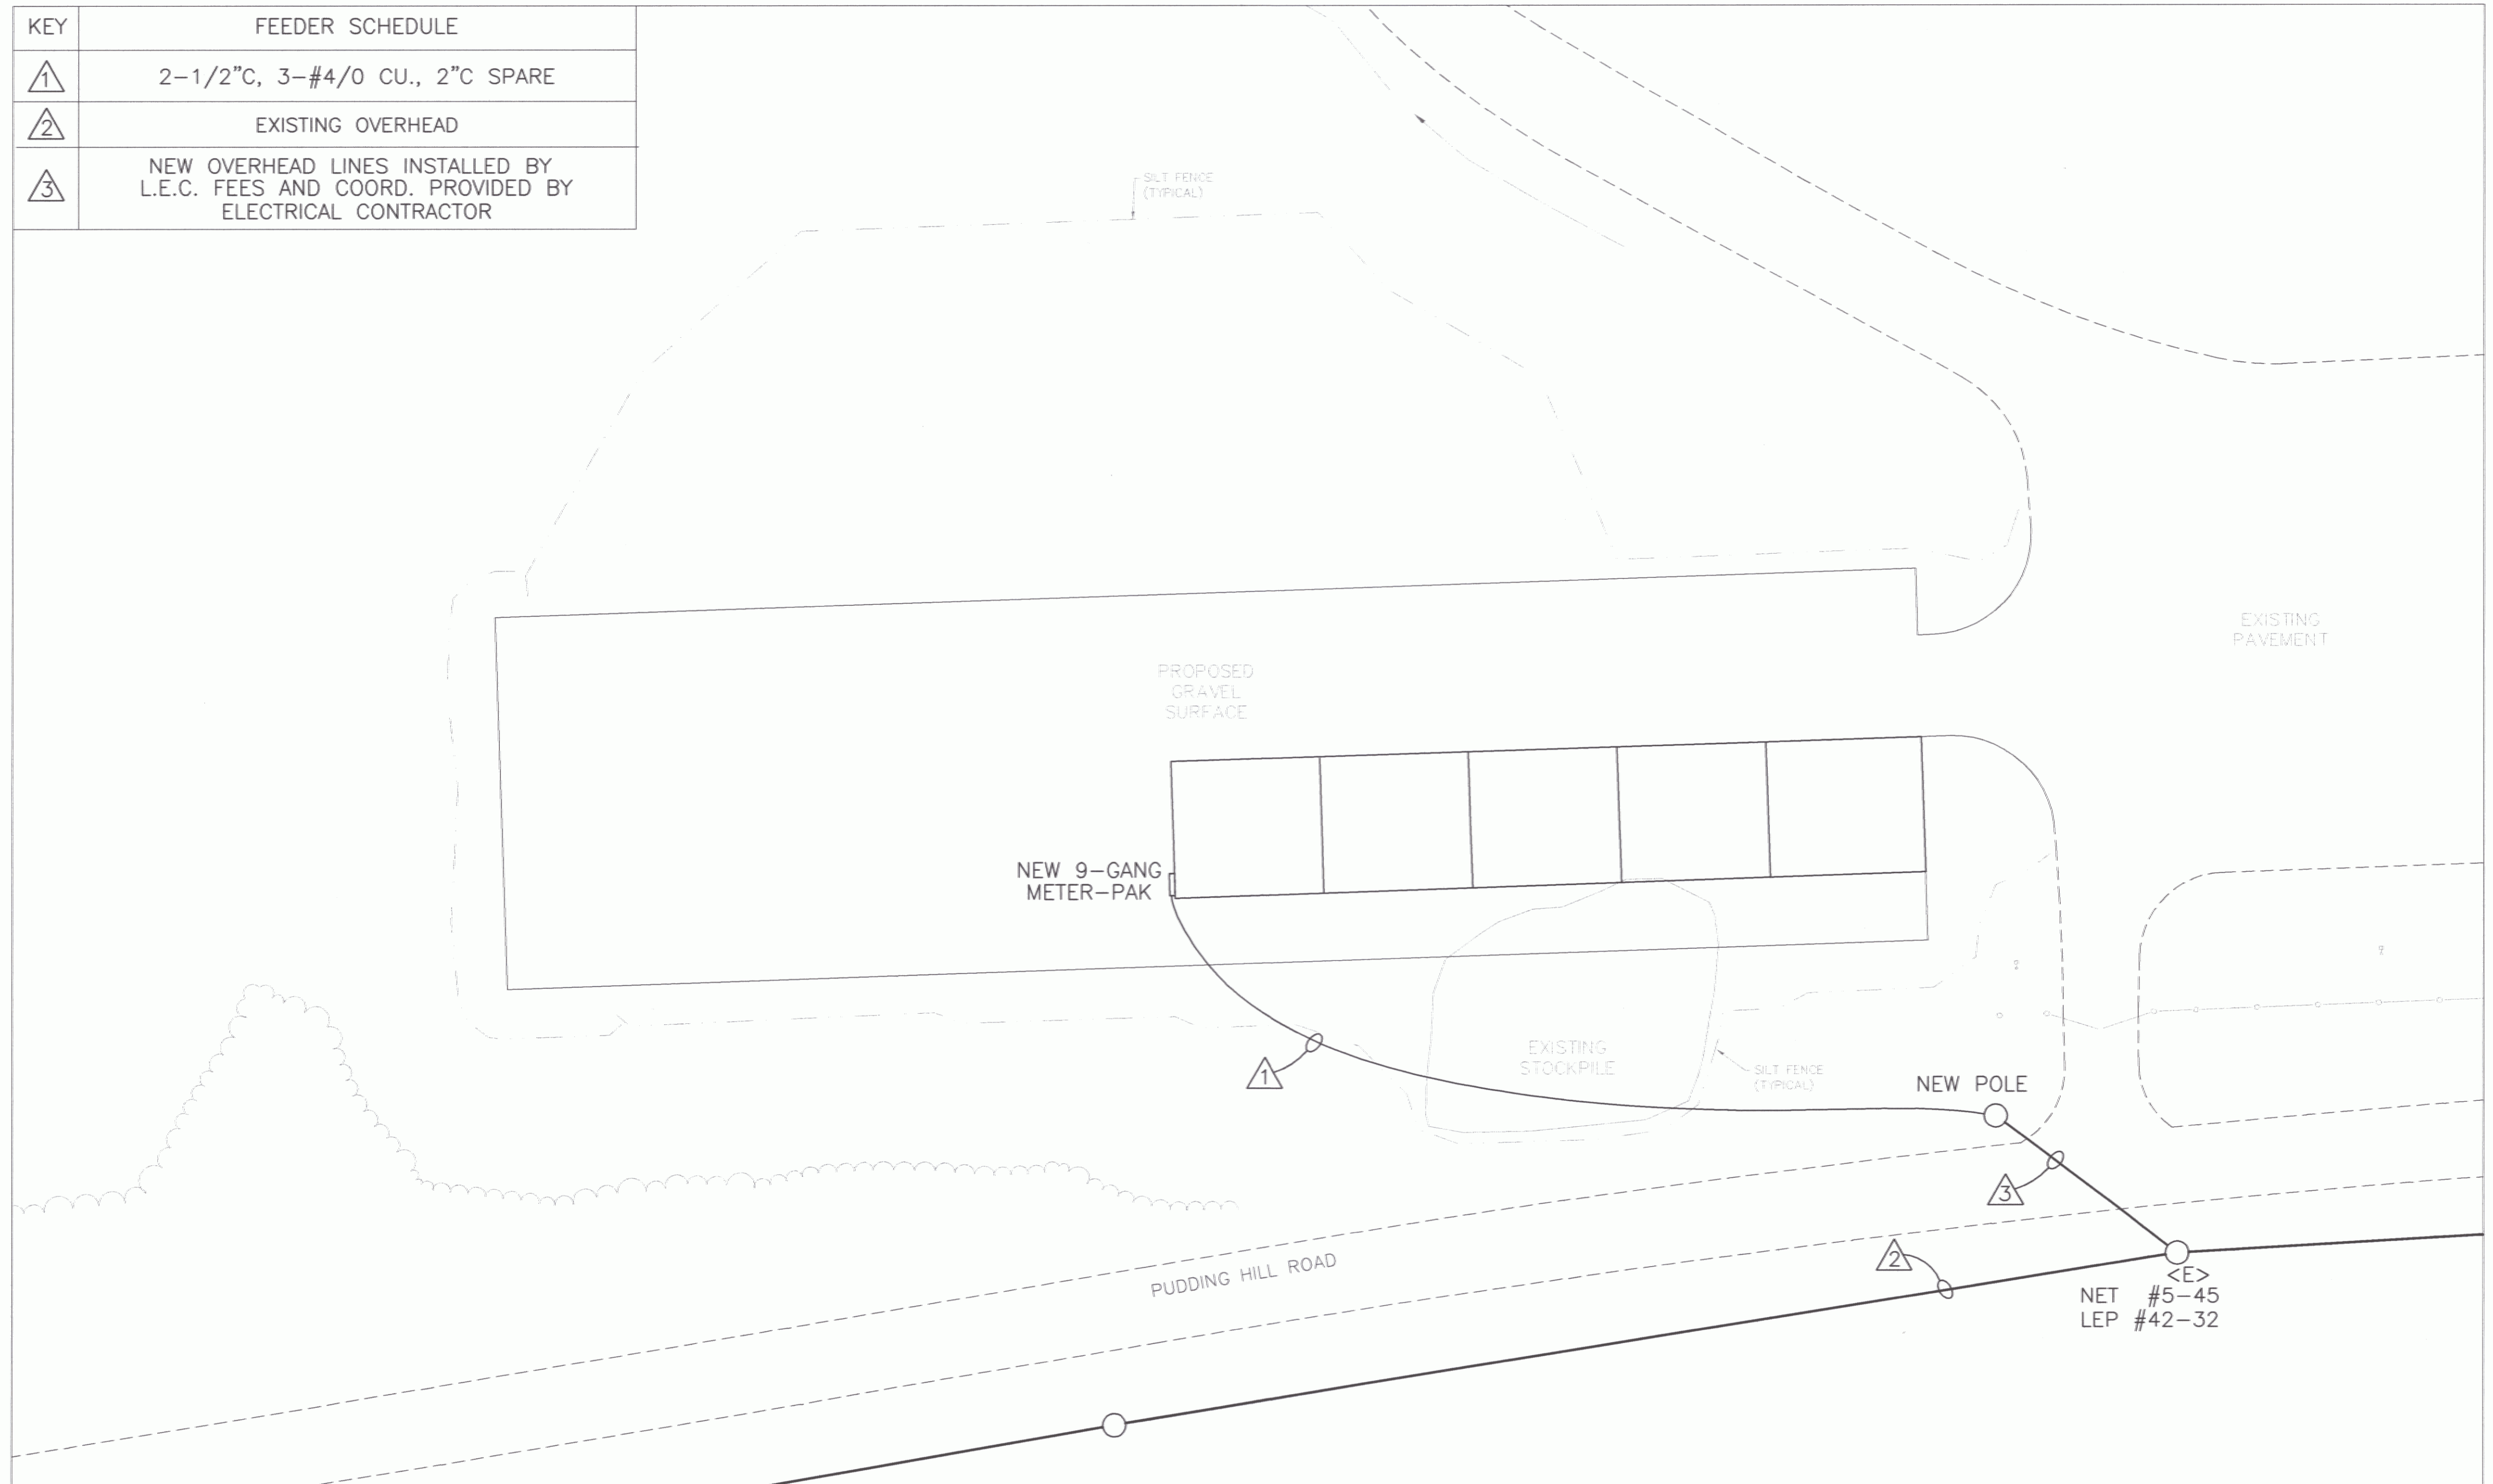

ELECTRICAL SITE PLAN

SCALE: 1" = 30'



STATE OF VERMONT
 Department of Buildings
 and General Services
 Agency of Administration
 Montpelier, Vermont

Pearson & Associates
 MECHANICAL & ELECTRICAL ENGINEERS
 P.O. BOX 810 STONE, VERMONT 05872
 TEL. (802) 253-9607 FAX. (802) 253-9290
 EMAIL: pearson@stonevt.net

NEW 5 BAY HANGAR
 CALEDONIA COUNTY STATE AIRPORT
 LYNDONVILLE VERMONT

REVISIONS
SCALE: AS NOTED
DATE: MAY 2006
DRAWN BY: ASG
APPR. BY: EEP

CALEDONIA COUNTY
 STATE AIRPORT
 ELECTRICAL
 SITE PLAN
 LYNDONVILLE